



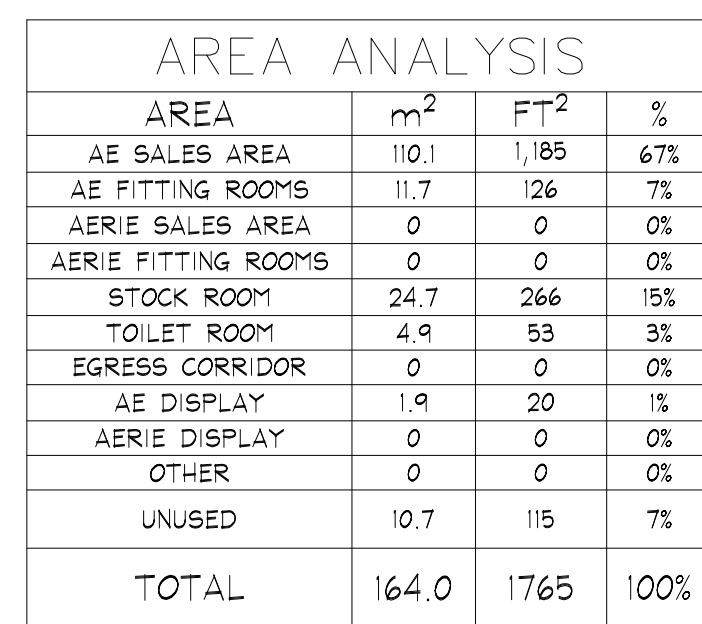

FIXTURE PLAN
SCALE: 1/4" = 1'-0" [1:50]

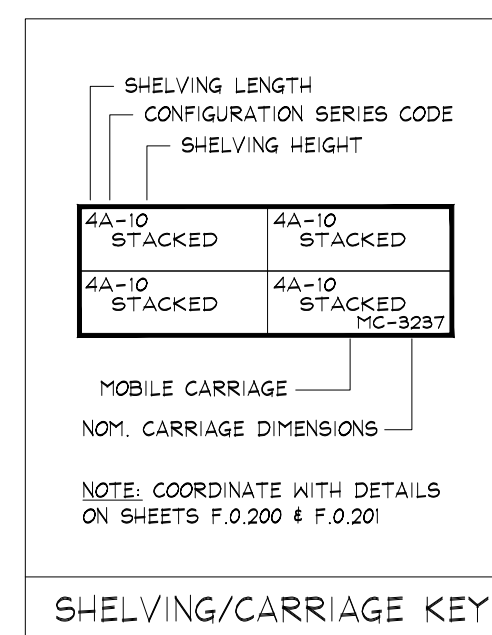

- NOTE:**
- SALES AREA SHELVING SHOWN FOR SCHEMATIC PURPOSES ONLY. ACTUAL CONFIGURATION MAY VARY.
 - SEE SHEET F.2.020 & F.2.021 FOR DETAILS OF ALL STOCKROOM SHELVING & SHELVING COMPONENTS FURNISHED BY TENANT, INSTALLED BY G.C.
 - SEE SHEET F.3.030 FOR DETAILS OF ALL MISC. STOCKROOM FIXTURES FURN. BY TENANT, INST. BY G.C.
 - SEE SHEETS F.1.400, F.1.401 & F.2.400 FOR DETAILS OF ALL MISC. SALES/FITTING ROOM FIXTURES FURN. BY TENANT, INST. BY G.C.
 - G.C. SHALL STRUCTURALLY BRACE ALL "END CAP" SHELVING AS REQUIRED TO WITHSTAND POSSIBLE IMPACT FROM ROLLING SHELVING.
 - PRIOR TO INSTALLATION OF STOCKROOM SHELVING & STOCKROOM ACCESSORY ITEMS, G.C. SHALL VERIFY THAT ALL STOCKROOM COMPONENTS CAN BE INSTALLED AS SHOWN ON THIS DRAWING. IF FIELD CONDITIONS PROHIBIT INSTALLATION AS SHOWN, OR PRESENT OPPORTUNITIES FOR EXPANSION, G.C. SHALL NOT CONTINUE WITH ANY INSTALLATION AND NOTIFY TENANT FIELD REP IMMEDIATELY.

NOTE:
SEE SHEET D.0.300-F.0.300 &
F.0.301 FOR DETAILS OF ALL
MISC. STOCKROOM FIXTURES
FURN. BY TENANT, INST. BY G.C.

SYMBOL LEGEND

- SUPPLY AIR DIFFUSER, WHITE COLOR, DIFUSOR CIRCULAR PARA ZONAS SIN PLAFON.
- SUPPLY AIR DIFFUSER (LINEAR), WHITE COLOR, DIFUSOR LINEAL PARA ZONAS CON PLAFON.
- SUPPLY AIR DIFFUSER, WHITE COLOR, DIFUSOR CUADRADO PARA ZONAS CON PLAFON.
- AREA PARA CORTINA DE AIRE EN ACCESO A TIENDA.
- RETURN / EXHAUST REGISTER (OR GRILLE), WHITE COLOR.
- PENDANT MTD. EMERGENCY LIGHT.
- SURFACE EMERGENCY LIGHT.
- EXIT SIGN COLOCAR SOBRE MOLDURA/FALDON (VER PLANO A.1.300).
- ESTROBO COLOCAR SOBRE MOLDURA/FALDON (VER PLANO A.1.300).
- SHOPPER TRACK ALTURA LIBRE ACORDE A PROYECTO. (VER PLANO A.1.300).

KEY NOTES:

2e STOCKROOM CEILING - NO CEILING, UNLESS REQUIRED BY LANDLORD OR LOCAL BUILDING CODES - (CT-2a); SUSPENSION SYSTEM SHALL BE AS MANUFACTURED BY USG INTERIORS, INC. DONN CEILING SUSPENSION DXL SERIES, WHITE EXPOSED 2'x4' GRID SYSTEM.

3e SIGN - FURNISHED BY SIGN CONSULTANT, INSTALLED BY G.C. SEE SHEET A.1.800 FOR MORE INFORMATION.

4e REGISTRO EN MURO Y/O PLAFON DE 1'-3 3/4" (400) x 1'-3 3/4" (400) EN ACABADO A IGUALAR INDICADO EN UBICACION REQUERIDA, POR G.C.

ACCESS PANELS SHALL BE AS MANUFACTURED BY WIND-LOCK, STEALTH PANEL #STR-AP024 (P-3e) (TYP). G.C. SHALL FURNISH AND INSTALL ACCESS PANELS FOR ALL NEW AND EXISTING ABOVE CEILING COMPONENTS REQUIRING MAINTENANCE ACCESS (e.g. HVAC UNIT CONTROLS, SHUT OFF VALVES, DAMPER CONTROLS, J-BOXES, ETC.). - LANDLORD AND/OR TENANT PROVIDED. G.C. TO VERIFY IN THE FIELD. COORDINATE ALL LOCATIONS WITH TENANT FIELD REPRESENTATIVE.

NOTE:

- ALL SUPPORT TRACK AND RELATED COMPONENTS, REQUIRED TO SUPPORT TRACK LIGHTING FIXTURES ONLY, ARE TO BE FURNISHED BY TENANT & INSTALLED BY G.C. - G.C. SHALL ENSURE THAT ALL SUPPORT TRACK IS INSTALLED WITH FIRST CLASS WORKMANSHIP: LEVEL, STRAIGHT, & ALIGNED.
- ALL OTHER EQUIPMENT/COMPONENT SUPPORTS (UNISTRUT, CLAMPS, NUTS, BOLTS, WASHERS, ETC.) FURN. & INST. BY G.C.

NOTE:

ALL COMPONENTS REQUIRED TO SUPPORT AND INSTALL THE SUSPENDED CEILING SYSTEM (WHETHER DRYWALL AND/OR ACOUSTIC TILE) ARE TO BE FURNISHED AND INSTALLED BY G.C. - G.C. SHALL CONSULT WITH MALL/BUILDING DEPARTMENT TO DETERMINE REQUIRED METHODS FOR SUPPORTING CEILING FROM MALL STRUCTURE, PRIOR TO SUBMITTING BID.

NOTE:

- NO WIRING SHALL EXTEND FROM SUPPORT TRACK TO ANY OTHER SUPPORT TRACK, WALL, OR PERIMETER CONSTRUCTION.
- ALL WIRING RUNS SHALL BE STRAIGHT HORIZONTAL OR VERTICAL. STRAP AND SECURE AS REQUIRED TO MAINTAIN ORGANIZED LOOK.
- ALL WIRING AT PERIMETER WALLS SHALL BE STRAPPED NEATLY HORIZONTAL OR VERTICAL AS REQUIRED.
- ALL VALANCE OR PERIMETER WIRING SHALL BE STRAPPED TIGHTLY TO THE TOP OF VALANCE CASE TO ELIMINATE VIEW FROM SALES FLOOR.
- ALL ELECTRICAL BOXES SHOULD BE HELD TIGHT TO WALLS.

NOTE:

ALL EMERGENCY LIGHTING SHALL BE WIRED 'HOT' UN-SWITCHED.

NOTE:

SEE SHEET 'A.0.200' FOR FIXTURE LOCATING DIMENSIONS.

NOTE:

SECURE ALL LIGHTING TRACK TO CEILING WITH TOGGLE BOLTS WHERE OCCURS.

NOTE:

SEE SHEET A.0.200 FOR ALL CEILING HEIGHTS.

NOTE:

SEE SHEET E.0.400 AND/OR E.0.401 FOR ELECTRICAL INSTALLATION DETAILS.

NOTE:

ALL HVAC INSTALLATION SHALL BE WHITE COLOR TO MATCH (P-5e); ALL DIFFUSERS SHALL BE GRAY COLOR.

NOTE:

- G.C. TO PAINT EVERYTHING ABOVE 11'-0" (P-5e).
- DO NOT PAINT EQUIPMENT INFORMATION TAGS!!

NOTE:

REFER TO SHEET E.0.500 FOR ALL CEILING MOUNTED LOW VOLTAGE DEVICES. REFER TO SHEET E.0.501 FOR INSTALLATION OF LOW VOLTAGE DEVICES.

NOTE:


SEE SHEET E.0.100 FOR LIGHTING FIXTURE AND TRACK SCHEDULES.

NOTE:


PRIOR TO START ANY INSTALLATION WORK, G.C. SHALL VERIFY FINAL LOCATION SYSTEM PLANS AS REQUIRED FOR THIS PROJECT (CCTV, SENSORMATIC, ETC.).

NOTA:

SE DEBERA REVISAR LA ALTURA TOTAL EXISTENTE EN LOCAL.

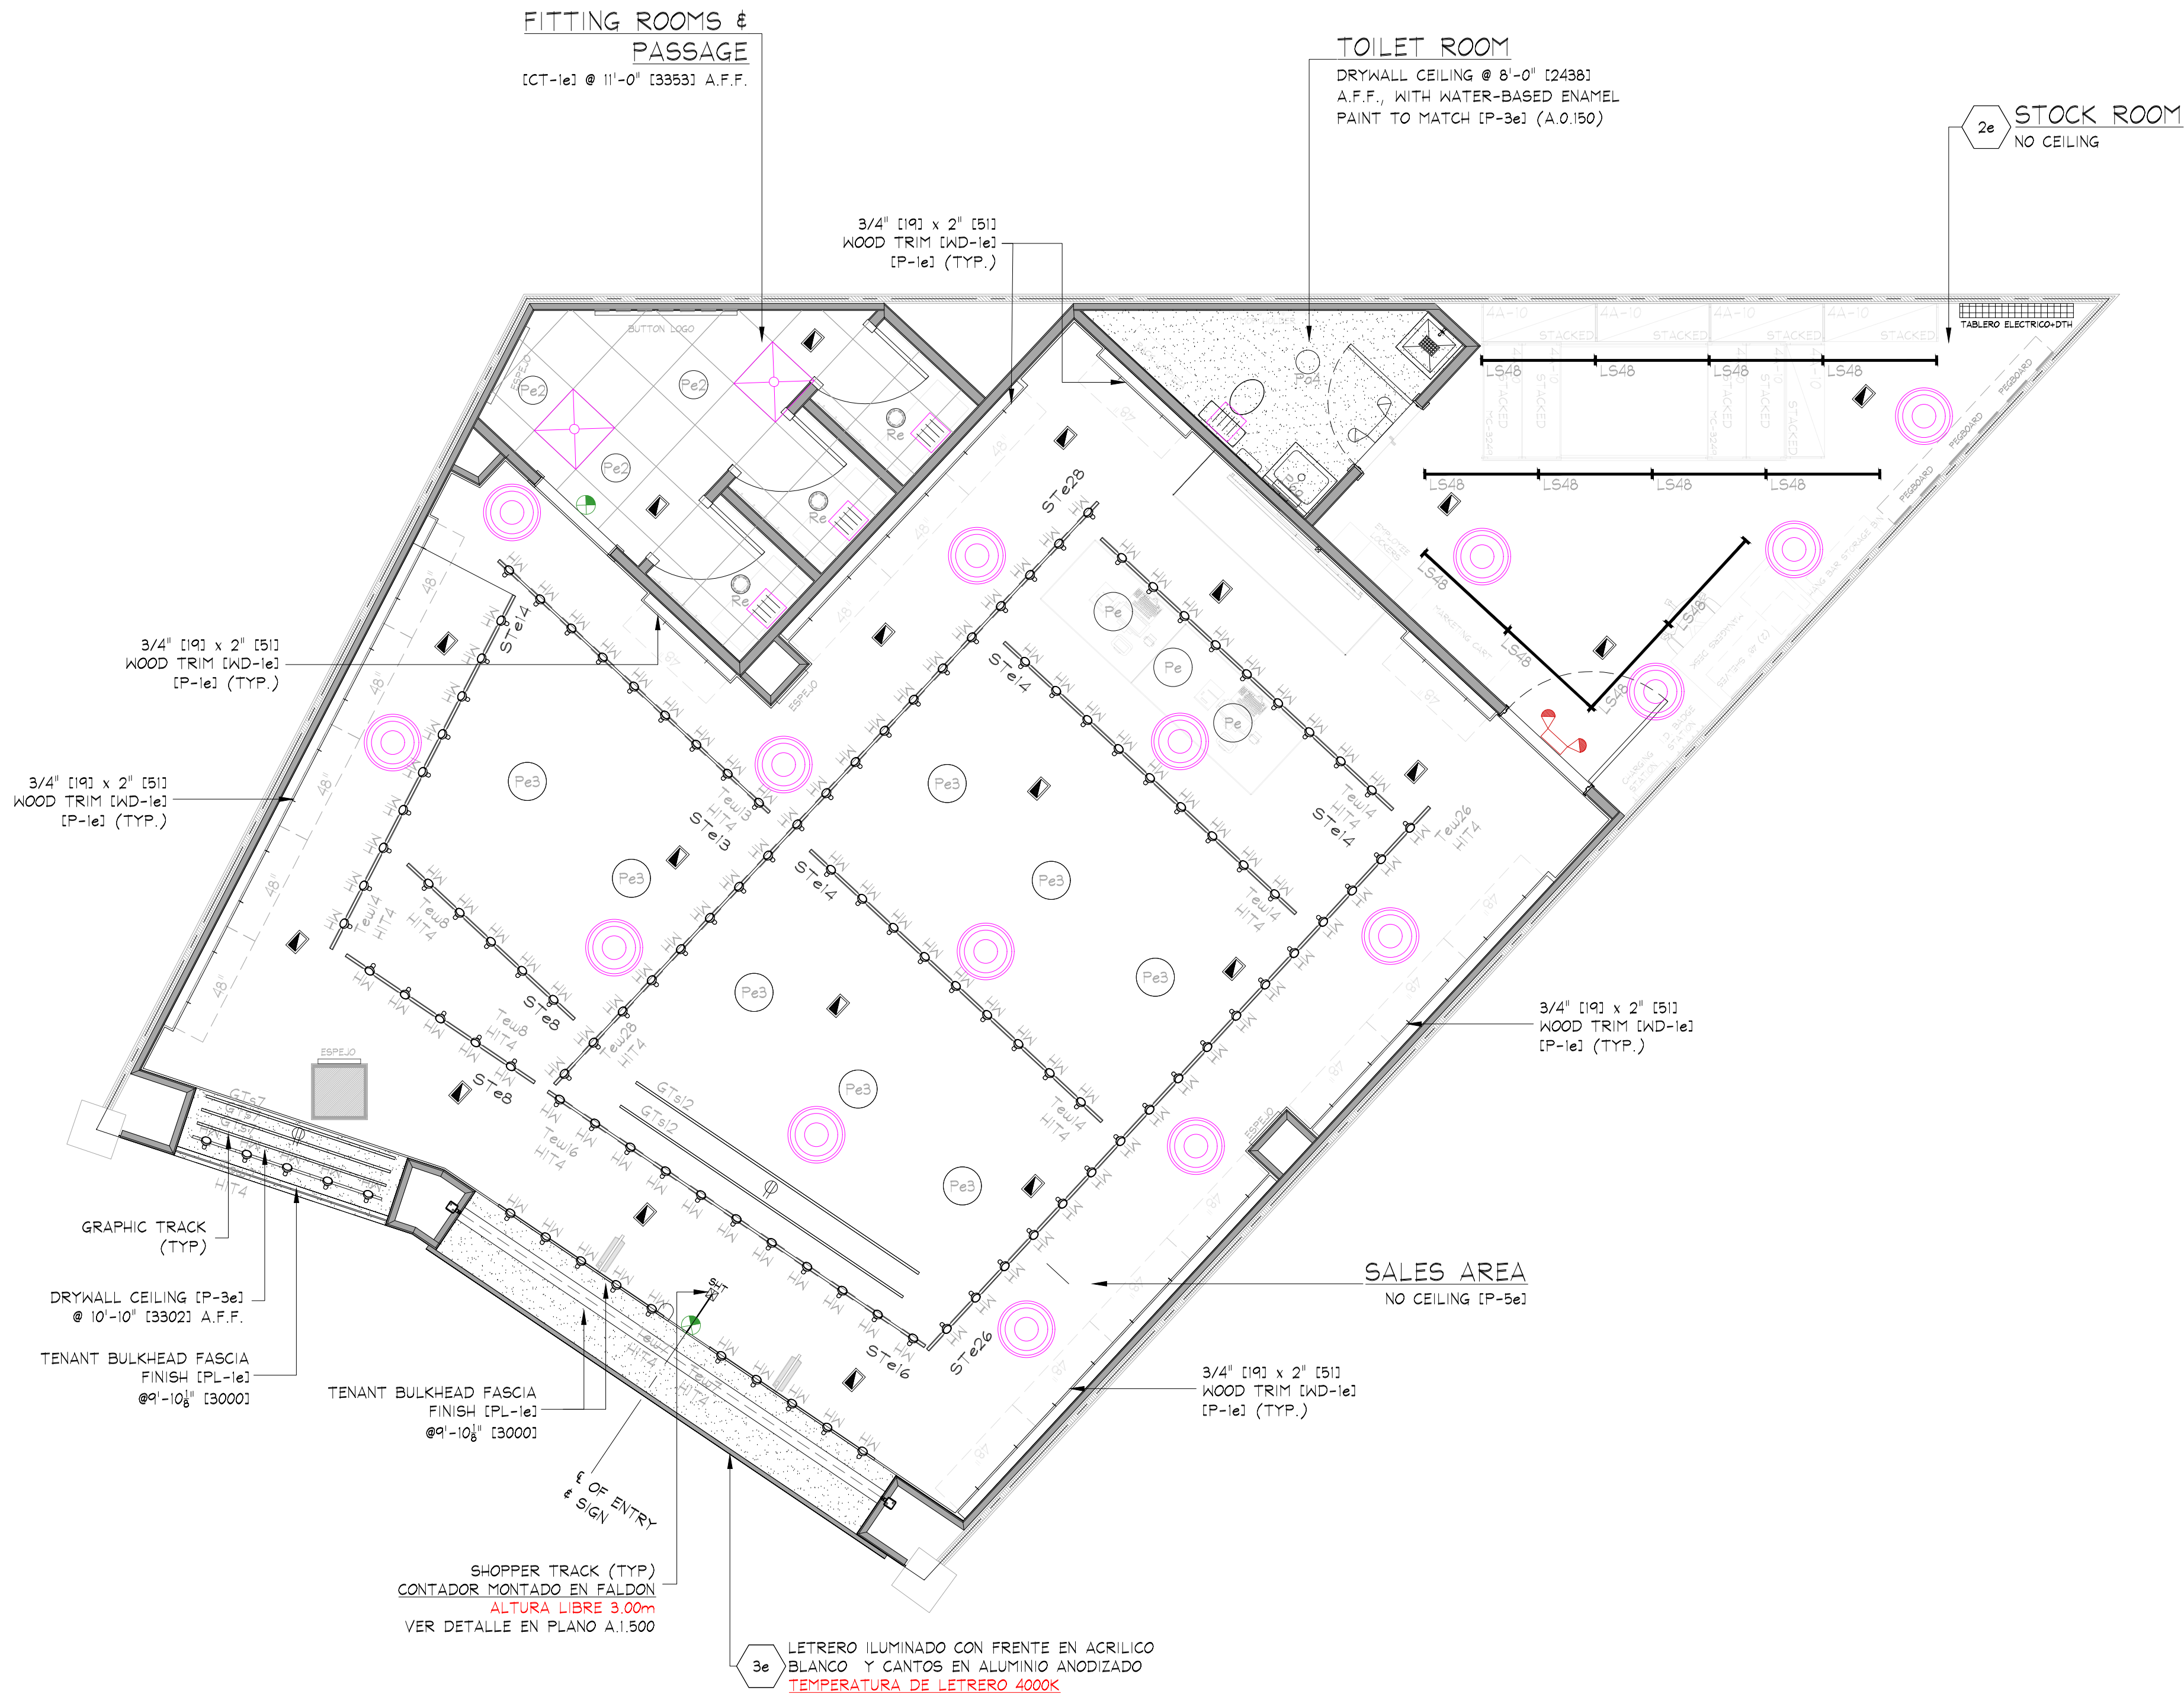

IMPORTANTE
 REVISAR EN SITIO ALTURAS FINALES PREVIO A CUALQUIER TRABAJO EN FACHADA
 NO REALIZAR TRABAJOS DE FACHADA SIN VISTO BUENO POR PARTE DE C.C.

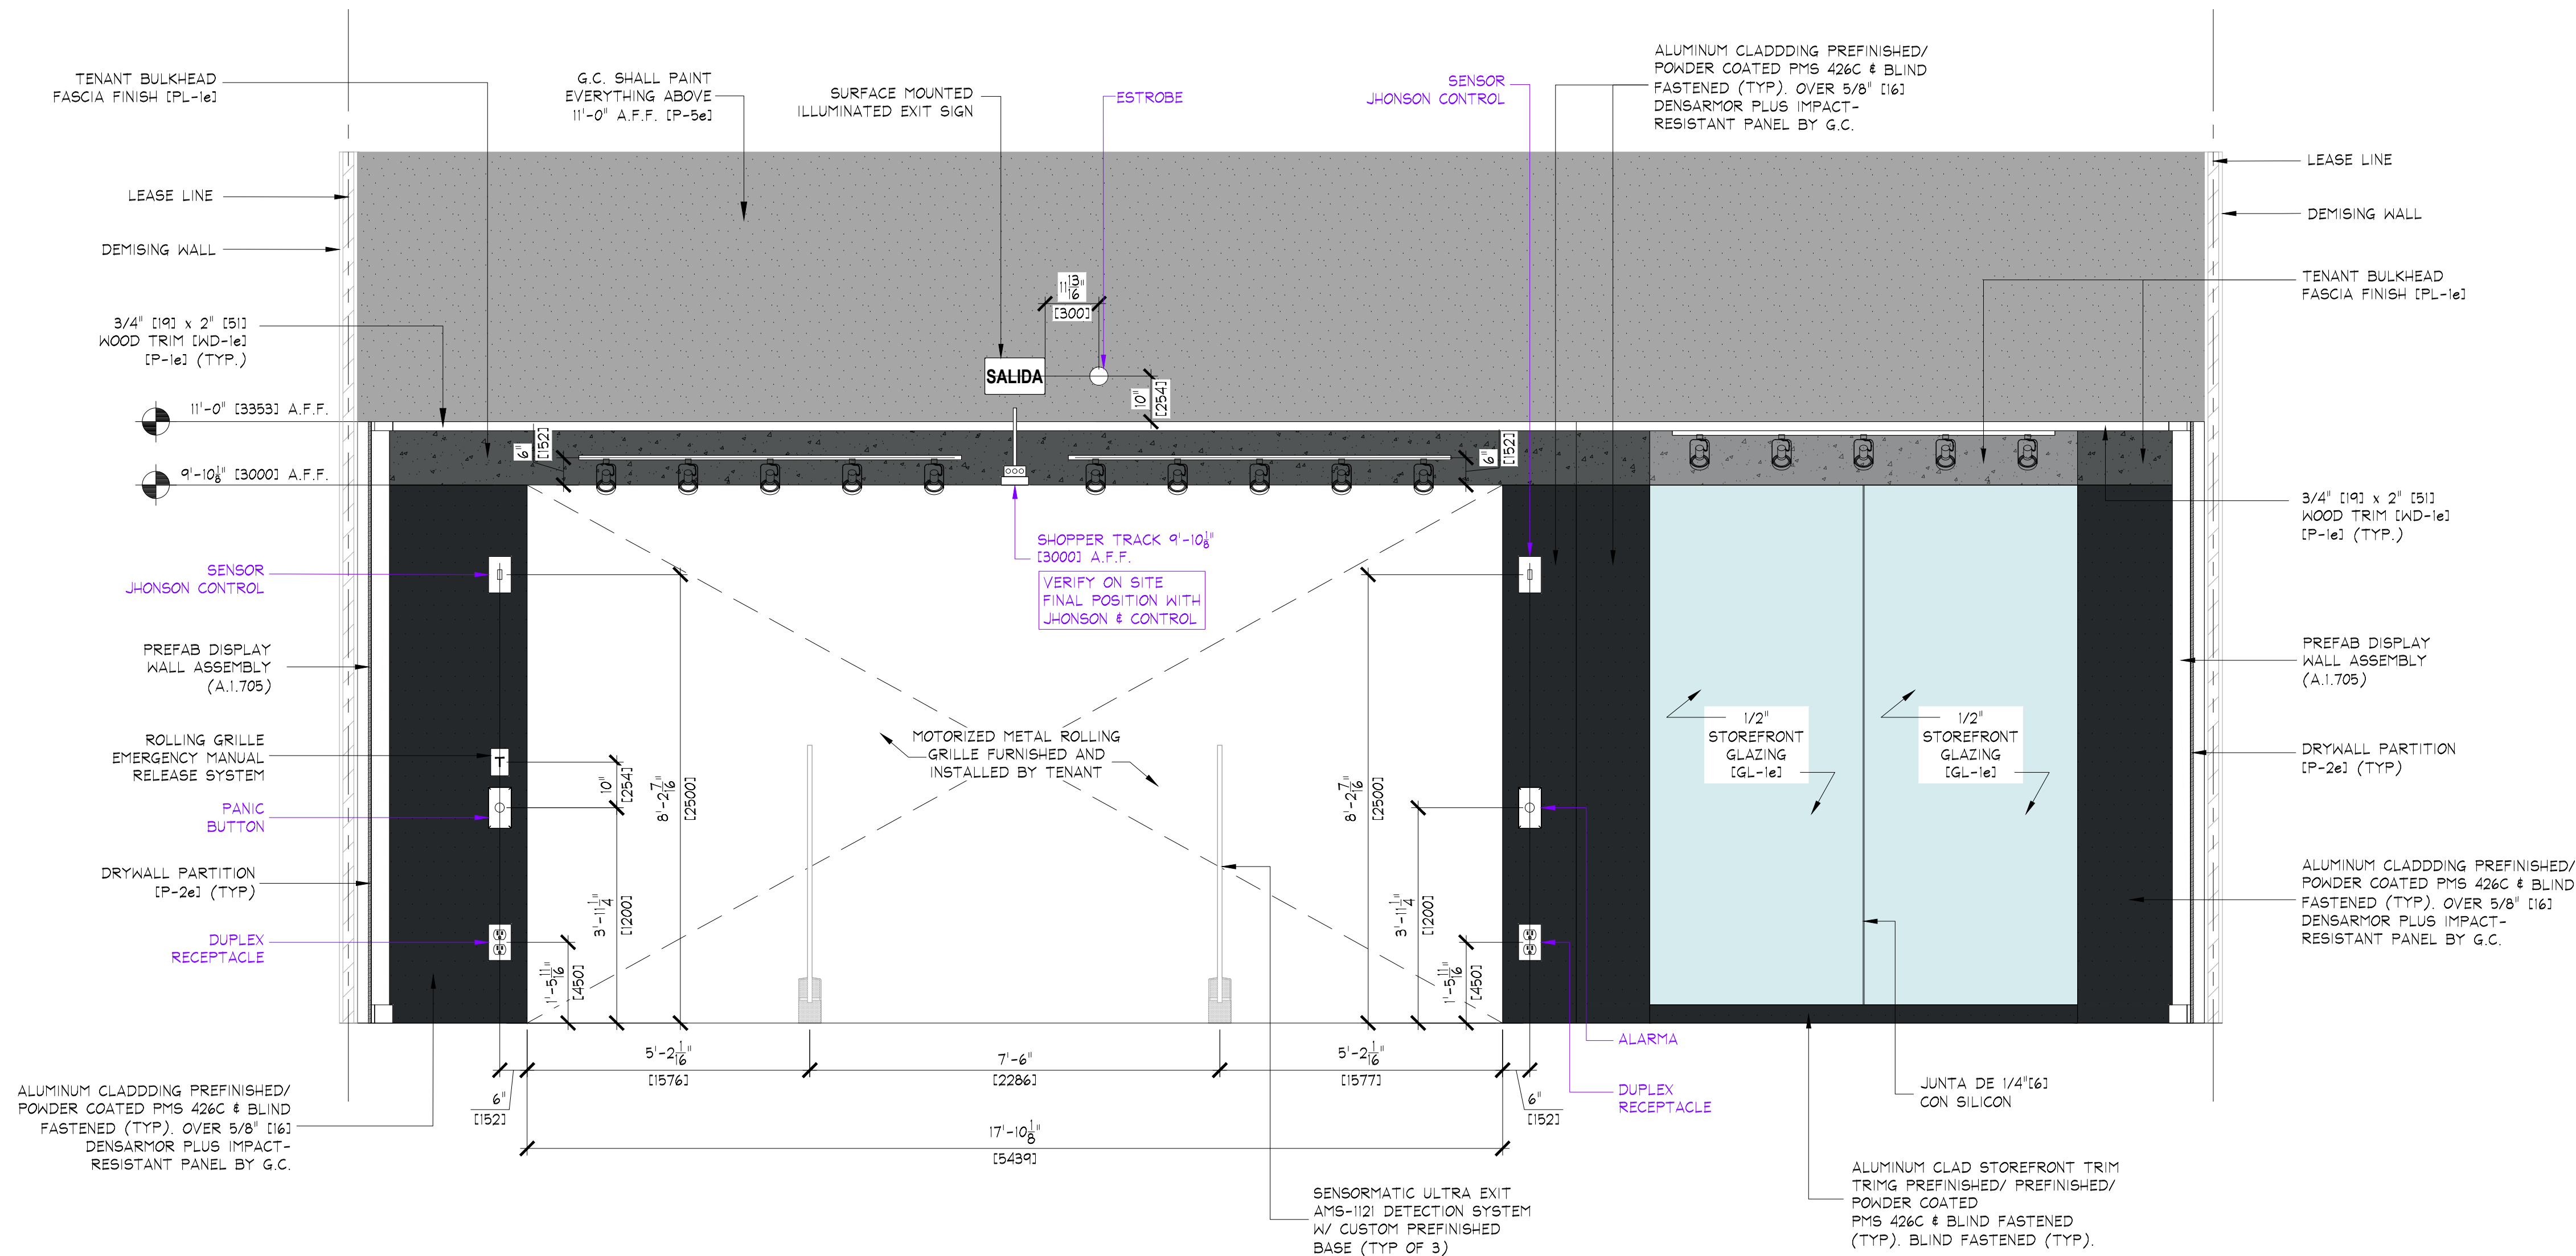

B STOREFRONT INTERIOR ELEVATION
 A.1.300 SCALE: 1/2" = 1'-0" (1/25)

IMPORTANT NOTE:
 VERIFY IN FIELD ALL DIMENSIONS BEFORE ANY WORK.

NOTE:
 DETAILS, NOTES, AND/OR SPECIFICATIONS ON
 THIS SHEET NOT LISTED ALPHABETICALLY OR
 NUMERICALLY HAVE BEEN PURPOSELY OMITTED
 AND DO NOT PERTAIN TO THIS PROJECT.

NOTAS IMPORTANTES:
 • REVISAR CON CENTRO COMERCIAL REQUERIMIENTOS
 DE FACHADA PREVIO A CUALQUIER TRABAJO
 RELACIONADO CON ESTA.

STOREFRONT ELEVATIONS

AMERICAN EAGLE OUTFITTERS

Megacentro
 Republica Dominicana

Store No.
 3803

Drawn by:

Approved

Drawing No.

A.1.301

THINK ARCHITECTURE S.A. DE C.V.
 Descartes 93, 1er piso Col. Anzures
 Miguel Hidalgo C.P. 11550 Mexico
 THINK
 AMERICAN EAGLE OUTFITTERS, INC.
 77 Hot Metal Street
 Pittsburgh, PA 15203
 (412) 452-3300

AMERICAN EAGLE

PROYECTO
 SUJETO A
 CAMBIOS

