



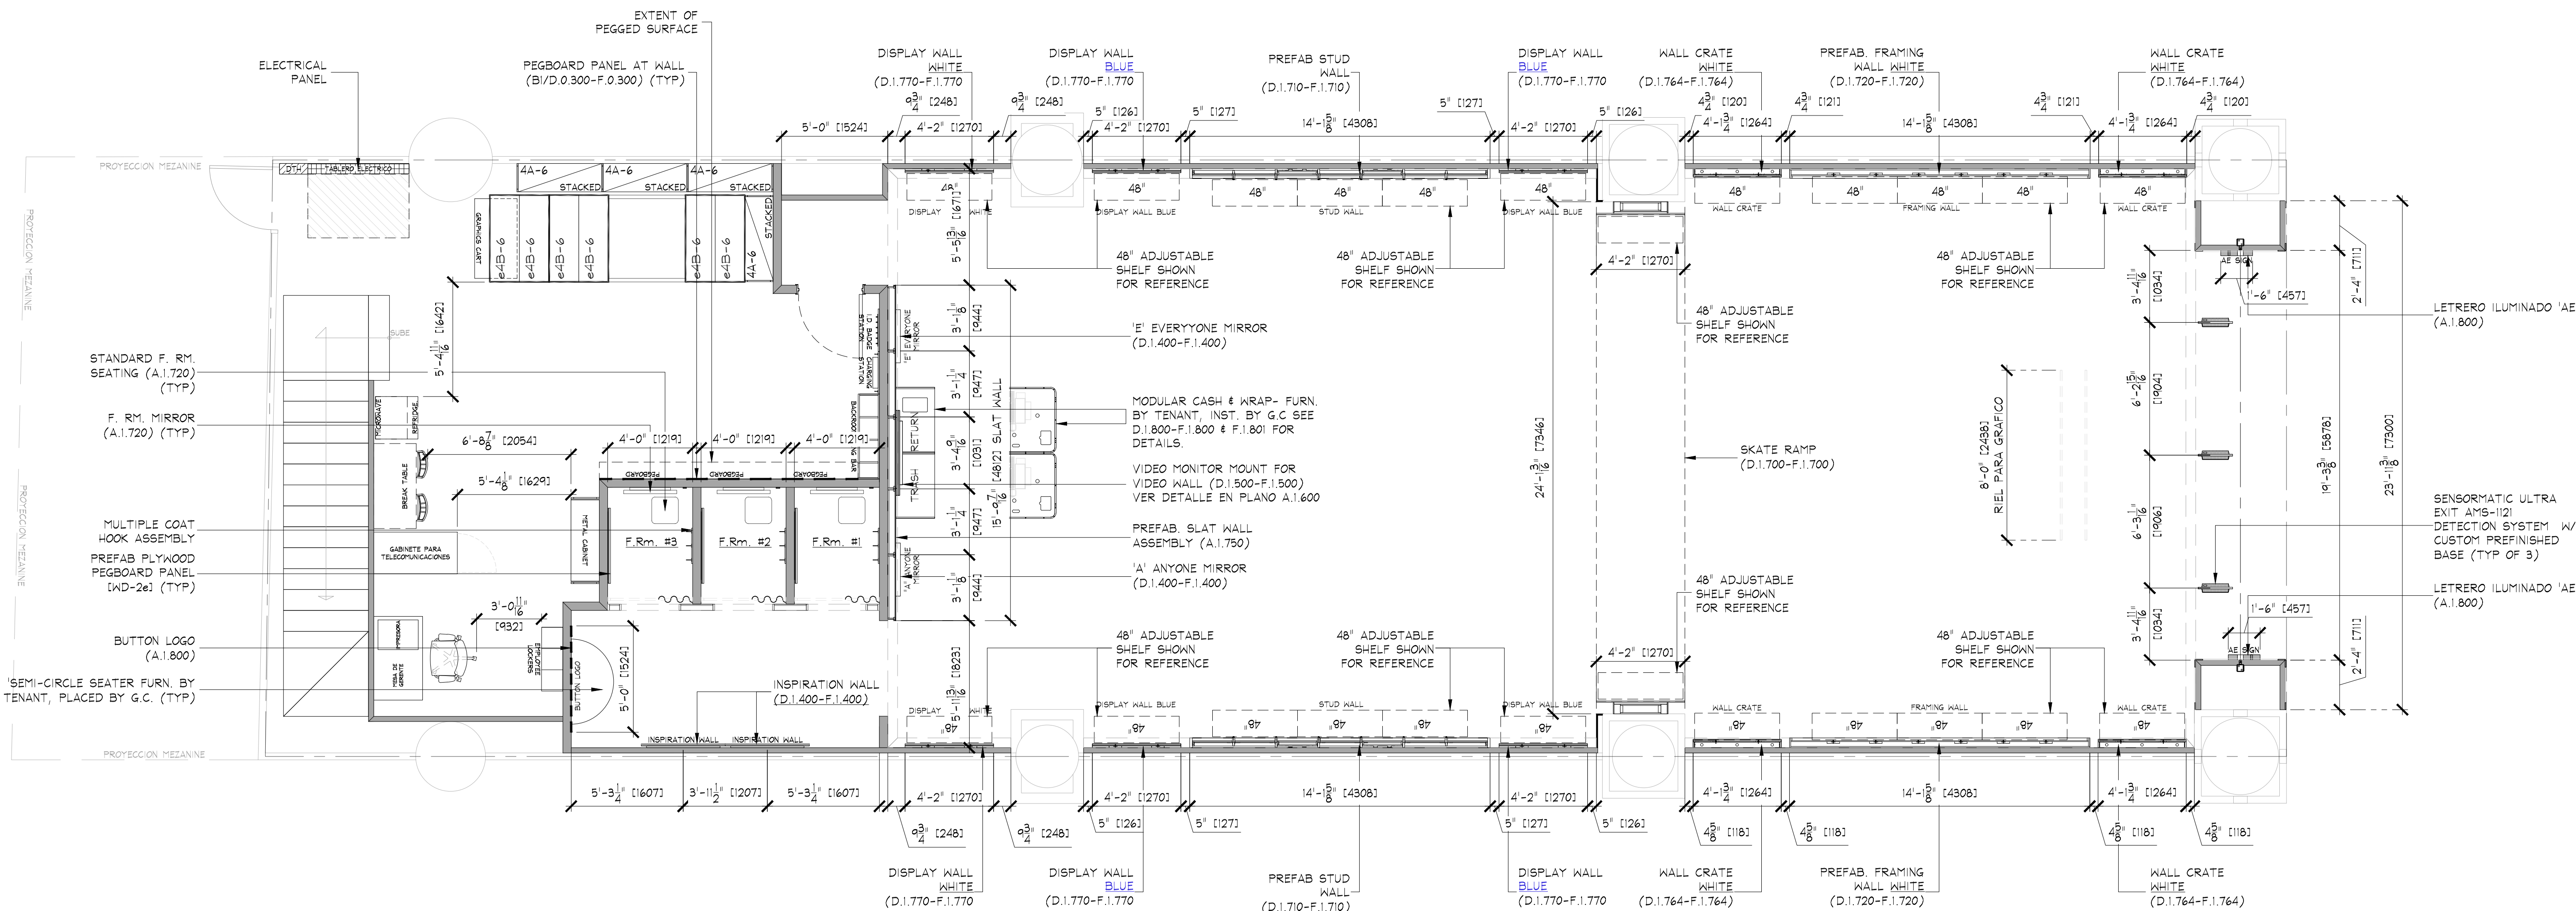

FIXTURE PLAN

SCALE: 1/4" = 1'-0" (1:50)

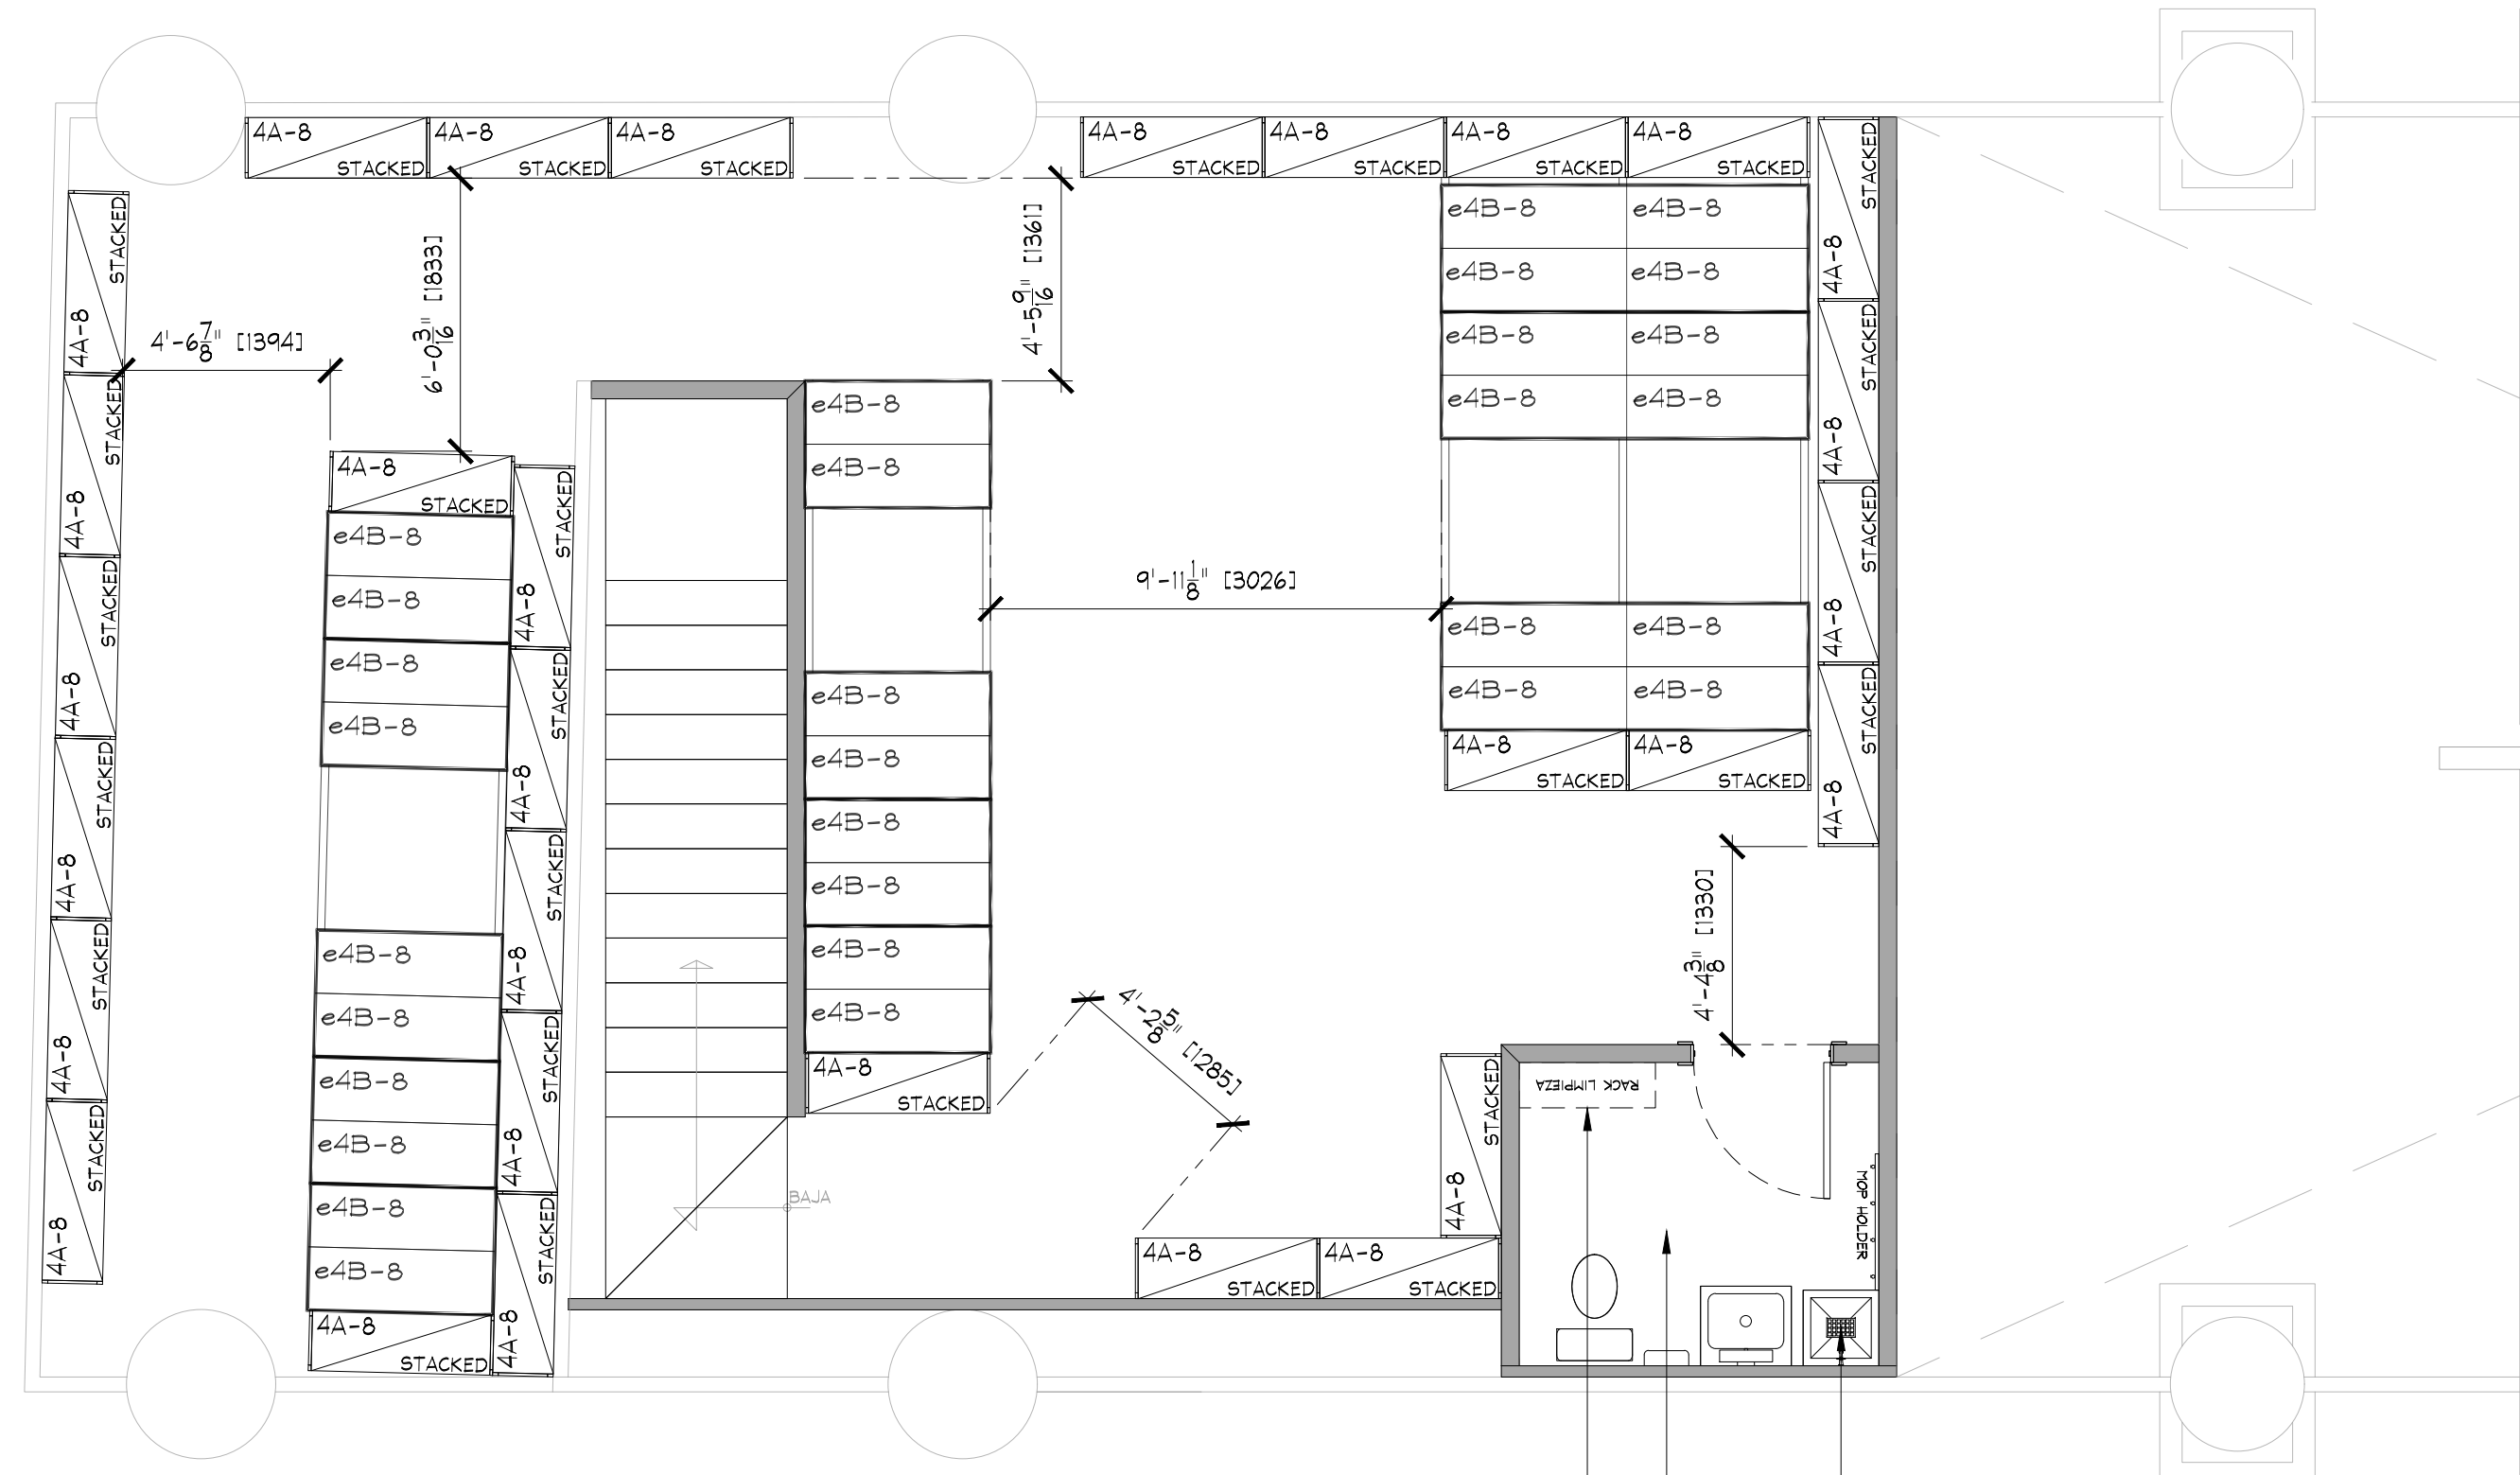

FIXTURE PLAN


MEZZANINE

SCALE: 1/4" = 1'-0" (1:50)

RACK DE LIMPIEZA DE  
90cmx30cm. REVISAR  
MODELO Y POSICION  
FINAL CON AE.


TOILET ROOM  
SEE DETAILS ON  
SHEET A.O.150

MOP SINK REVISAR MODELO Y  
POSICION FINAL CON AE.  
(SOLO LLAVE CON GARDINEL)

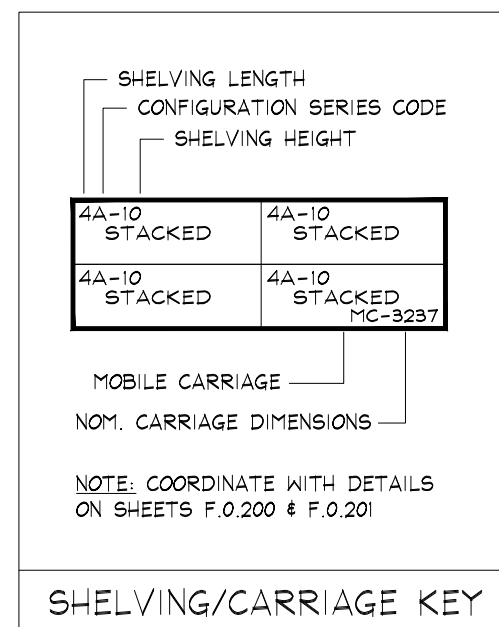

- NOTE:
- SALES AREA SHELVING SHOWN FOR SCHEMATIC PURPOSES ONLY. ACTUAL CONFIGURATION MAY VARY.
  - SEE SHEET F.0.200 & F.0.201 FOR DETAILS OF ALL STOCKROOM SHELVING & SHELVING COMPONENTS. FURNISHED BY TENANT, INSTALLED BY G.C.
  - SEE SHEET F.0.300 FOR DETAILS OF ALL MISC. STOCKROOM FIXTURES FURN. BY TENANT, INST. BY G.C.
  - SEE SHEETS F.1.400, F.1.401 & F.2.400 FOR DETAILS OF ALL MISC. SALES/FITTING ROOM FIXTURES FURN. BY TENANT, INST. BY G.C.
  - G.C. SHALL STRUCTURALLY BRACE ALL 'END CAP' SHELVING AS REQUIRED TO WITHSTAND POSSIBLE IMPACT FROM ROLLING SHELVING.
  - PRIOR TO INSTALLATION OF STOCKROOM SHELVING & STOCKROOM ACCESSORY ITEMS, G.C. SHALL VERIFY THAT ALL STOCKROOM COMPONENTS CAN BE INSTALLED AS SHOWN ON THIS DRAWING. IF FIELD CONDITIONS PROHIBIT INSTALLATION AS SHOWN, OR PRESENT OPPORTUNITIES FOR EXPANSION, G.C. SHALL NOT CONTINUE WITH ANY INSTALLATION AND NOTIFY TENANT FIELD REP IMMEDIATELY.

| AREA ANALYSIS       |                |                 |      |
|---------------------|----------------|-----------------|------|
| AREA                | m <sup>2</sup> | FT <sup>2</sup> | %    |
| AE SALES AREA       | 162.9          | 1754            | 66%  |
| AE FITTING ROOMS    | 15.6           | 168             | 6%   |
| AERIE SALES AREA    | 0              | 0               | 0%   |
| AERIE FITTING ROOMS | 0              | 0               | 0%   |
| STOCK ROOM          | 42.1           | 453             | 17%  |
| TOILET ROOM         | 0              | 0               | 0%   |
| EGRESS CORRIDOR     | 0              | 0               | 0%   |
| AE DISPLAY          | 0              | 0               | 0%   |
| AERIE DISPLAY       | 0              | 0               | 0%   |
| OTHER (STAIRS)      | 7.7            | 83              | 3%   |
| UNUSED              | 19.2           | 207             | 8%   |
| TOTAL               | 247.6          | 2665            | 100% |

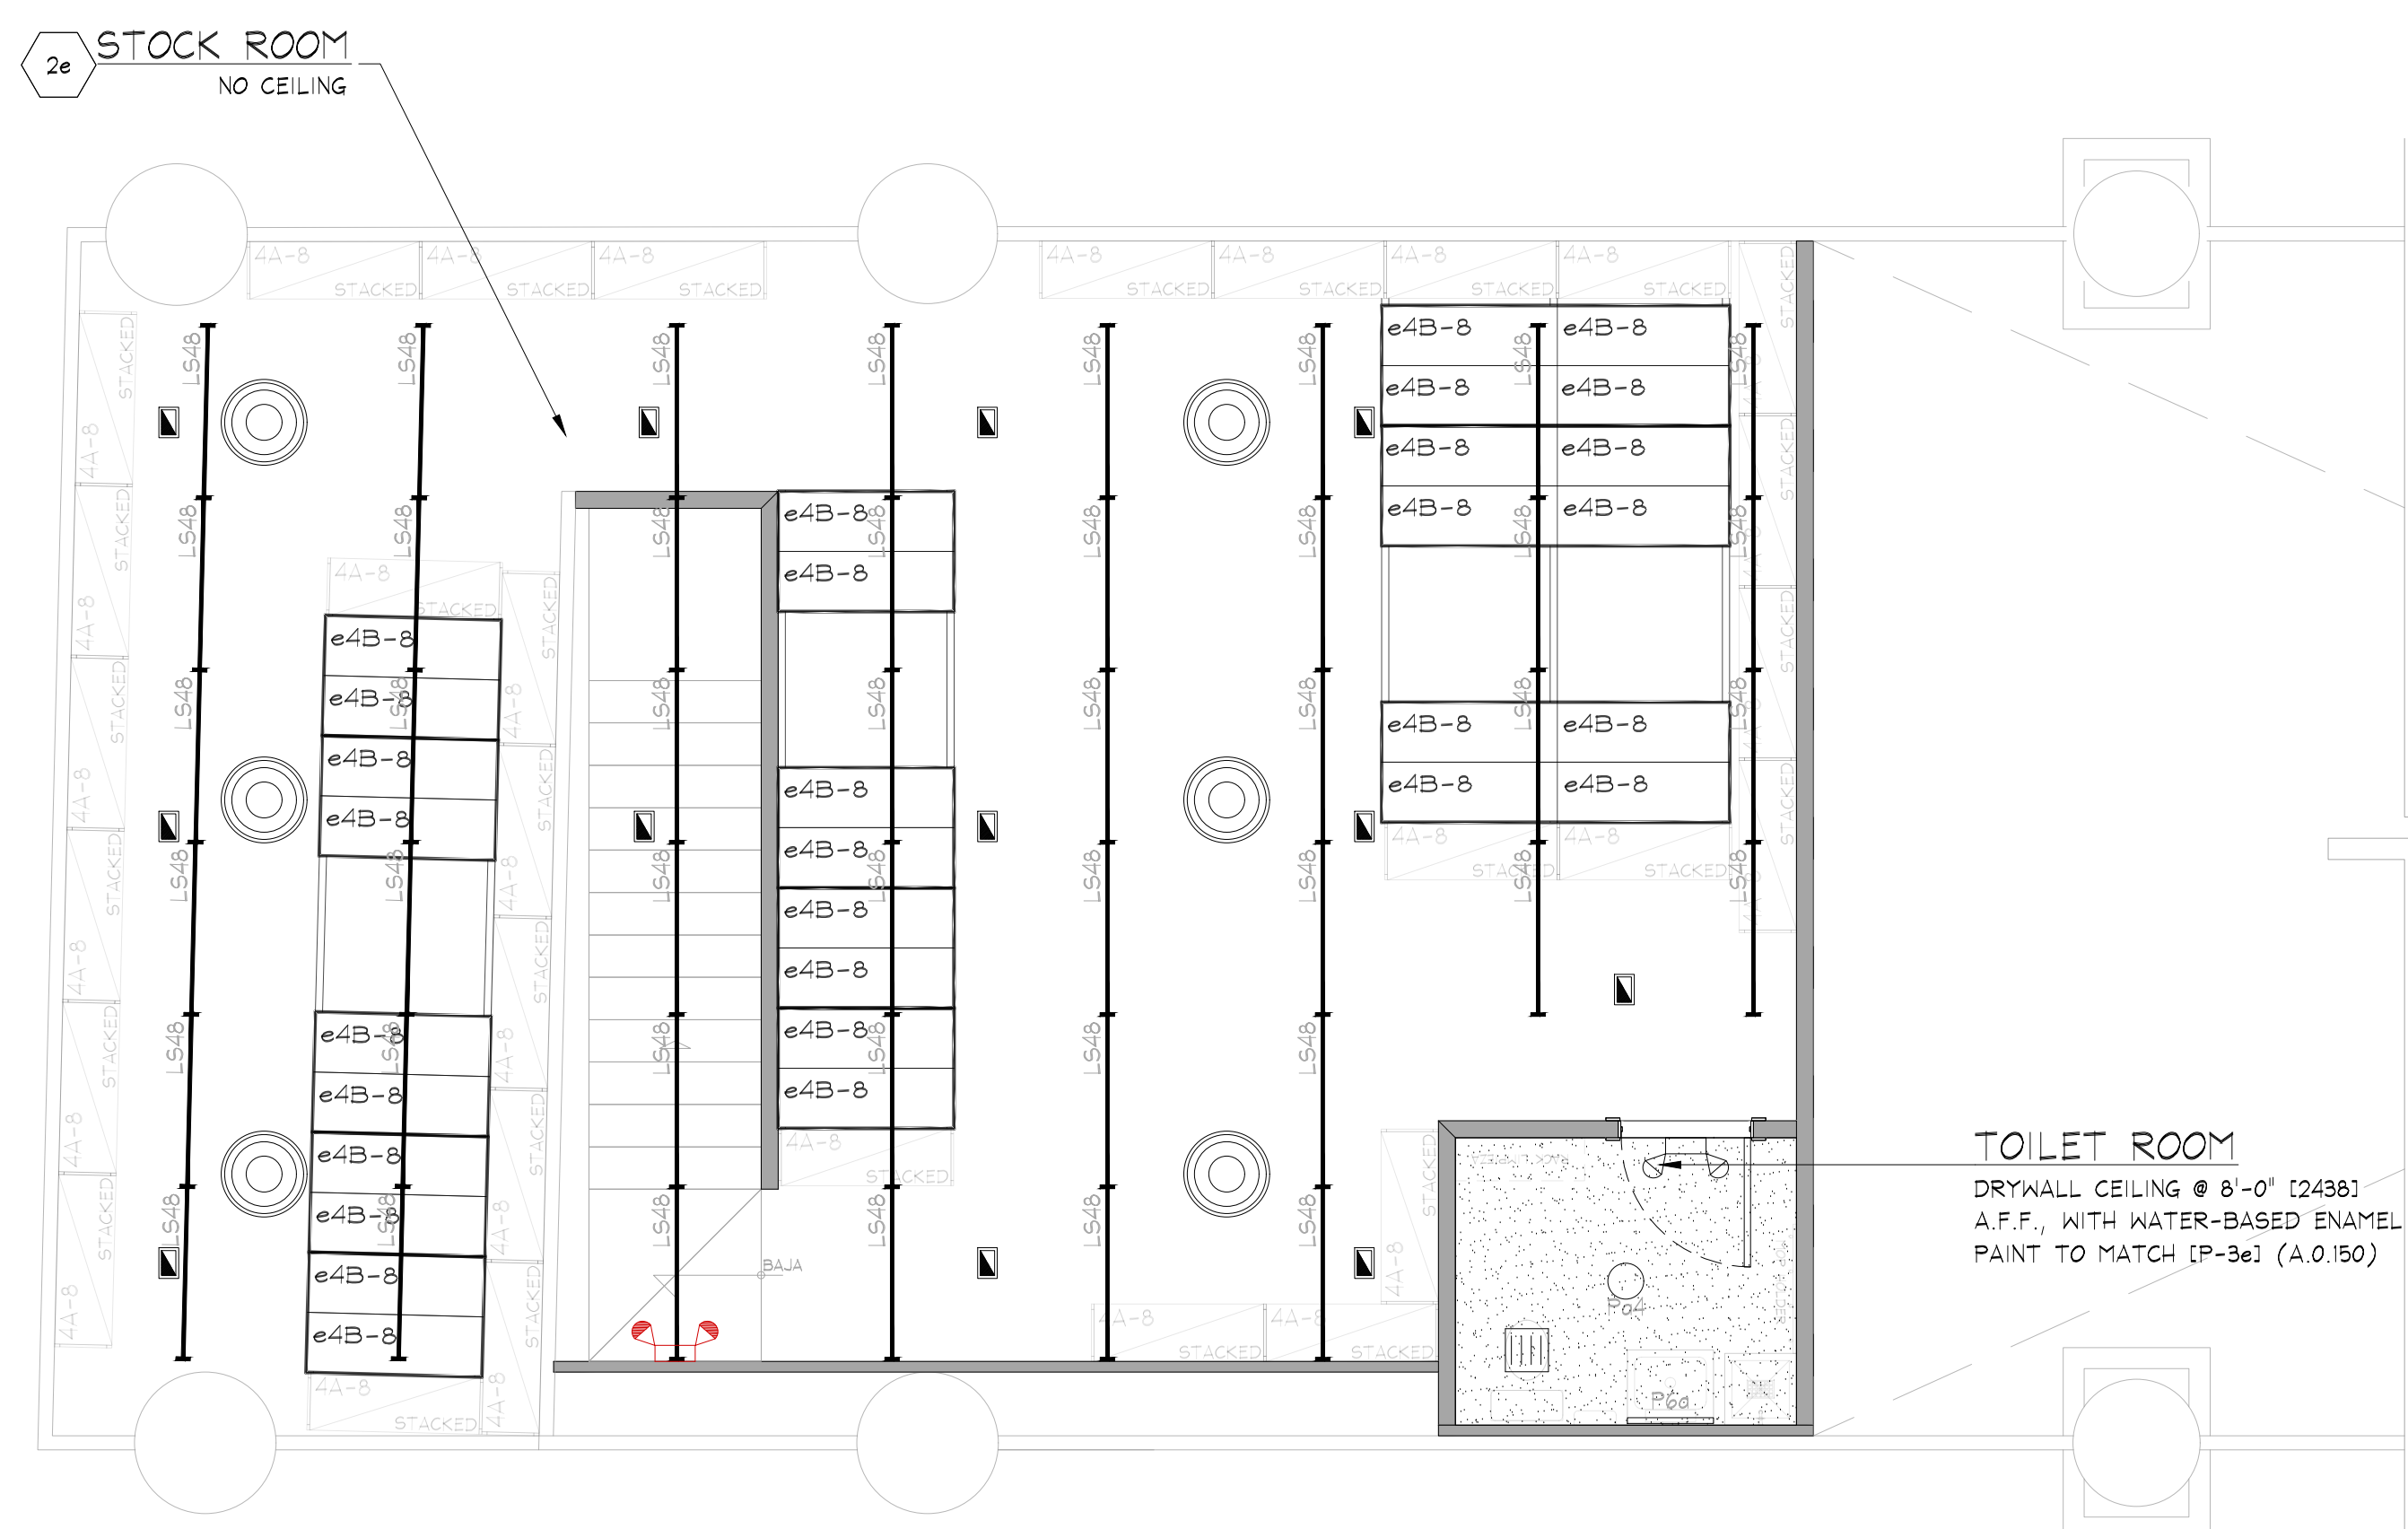

## SYMBOL LEGEND

|                                                                                       |                                                                                                 |
|---------------------------------------------------------------------------------------|-------------------------------------------------------------------------------------------------|
|  | SUPPLY AIR DIFFUSER, WHITE<br>COLOR: <b>DIFFUSOR CIRCULAR<br/>PARA ZONAS SIN PLAFÓN.</b>        |
|  | SUPPLY AIR DIFFUSER (LINEAR),<br>WHITE COLOR: <b>DIFFUSOR LINEAL<br/>PARA ZONAS CON PLAFÓN.</b> |
|  | SUPPLY AIR DIFFUSER, WHITE<br>COLOR: <b>DIFFUSOR CUADRO<br/>PARA ZONAS CON PLAFÓN.</b>          |
|  | AREA PARA CORTINA DE AIRE<br>EN ACCESO A TIENDA.                                                |
|  | RETURN / EXHAUST REGISTER<br>(OR GRILLE), WHITE COLOR                                           |
|  | PENDANT MTD. EMERGENCY LIGHT                                                                    |
|  | SURFACE EMERGENCY LIGHT                                                                         |
|  | EXIT SIGN<br>COLOCAR SOBRE MOLDURA/FALDON<br>(VER PLANO A1.300)                                 |
|  | ESTRBO<br>COLOCAR SOBRE MOLDURA/FALDON<br>(VER PLANO A1.300)                                    |
|  | SHOPPER TRACK<br>ALTURA LIBRE ACORDE A PROTECTO.<br>(VER PLANO A1.300)                          |

2e STOCKROOM CEILING - NO CEILING, UNLESS REQUIRED BY LANDLORD OR LOCAL BUILDING CODES - [CT-2e]. SUSPENSION SYSTEM SHALL BE AS MANUFACTURED BY USG INTERIORS, INC. DONN CEILING SUSPENSION DXL SERIES, WHITE EXPOSED 2'x4' GRID SYSTEM.

3e SIGN - FURNISHED BY SIGN CONSULTANT, INSTALLED BY G.C. SEE SHEET A.1.800 FOR MORE INFORMATION.

4e REGISTRO EN MURO Y/O PLAFON DE 1'-3 $\frac{3}{4}$ "(400) x 1'-3 $\frac{3}{4}$ "(400) EN ACABADO A IGUALAR INDICADO EN UBICACION REQUERIDA, POR G.C.

ACCESS PANELS SHALL BE AS MANUFACTURED BY WIND-LOCK, STEALTH PANEL #TR-AP024 (P-361) (TYP). G.C. SHALL FURNISH AND INSTALL ACCESS PANELS FOR ALL NEW AND EXISTING ABOVE CEILING COMPONENTS REQUIRING MAINTENANCE ACCESS (e.g. HVAC UNIT CONTROLS, SHUT OFF VALVES, DAMPER CONTROLS, J-BOXES, ETC. - LANDLORD AND/OR TENANT PROVIDED G.C. TO VERIFY IN THE FIELD). COORDINATE ALL LOCATIONS WITH TENANT FIELD REPRESENTATIVE.

---

NOTE:

- ALL SUPPORT TRACK AND RELATED COMPONENTS, REQUIRED TO SUPPORT TRACK LIGHTING FIXTURES ONLY, ARE TO BE FURNISHED BY TENANT & INSTALLED BY G.C. - G.C. SHALL ENSURE THAT ALL SUPPORT TRACK IS INSTALLED WITH FIRST CLASS WORKMANSHIP: LEVEL, STRAIGHT, & ALIGNED.
- ALL OTHER EQUIPMENT/COMPONENT SUPPORTS (UNISTRUT, CLAMPS, NUTS, BOLTS, WASHERS, ETC.) FURN. & INST. BY G.C.

NOTE:  
ALL COMPONENTS REQUIRED TO SUPPORT AND INSTALL THE SUSPENDED CEILING SYSTEM (WHETHER DRYWALL AND/OR ACOUSTIC TILE), ARE TO BE FURNISHED AND INSTALLED BY G.C. - G.C. SHALL CONSULT WITH MALLS/BUILDING DEPARTMENT TO DETERMINE REQUIRED METHODS FOR SUPPORTING CEILING FROM MALL STRUCTURE, PRIOR TO SUBMITTING BID.

**NOTE:**

- NO WIRING SHALL EXTEND FROM SUPPORT TRACK TO ANY OTHER SUPPORT TRACK, WALL, OR PERIMETER CONSTRUCTION. ALL WIRING RUNS SHALL BE STRAIGHT HORIZONTAL OR VERTICAL. STRAP AND SECURE AS REQUIRED TO MAINTAIN ORGANIZED LOOK.
- ALL WIRING AT PERIMETER WALLS SHALL BE STRAPPED TO THE HORIZONTAL OR VERTICAL AS REQUIRED.
- ALL VALANCE OR PERIMETER WIRING SHALL BE STRAPPED TIGHTLY TO THE TOP OF VALANCE CASE TO ELIMINATE VIEW FROM SALES FLOOR.
- ALL ELECTRICAL BOXES SHOULD BE HELD TIGHT TO WALLS.

**NOTE:**  
ALL EMERGENCY LIGHTING  
SHALL BE WIRED "HOT"  
UN-SWITCHED.

NOTE:  
SEE SHEET 'A.O.200' FOR  
FIXTURE LOCATING

**NOTE:**  
SECURE ALL LIGHTING  
TRACK TO CEILING WITH

NOTE:  
SEE SHEET A.O.200 FOR A  
CEILING HEIGHTS

NOTE:  
SEE SHEET E.O.400 AND/OR  
E.O.401 FOR ELECTRICAL  
INSTALLATION DETAILS.

**NOTE:**  
ALL HVAC INSTALLATION SHALL BE  
WHITE COLOR TO MATCH [P-4e];  
ALL DIFFUSERS SHALL BE WHITE  
COLOR

**NOTE:**


- G.C. TO PAINT EVERYTHING ABOVE 11'-0" [P-4e]
- DO NOT PAINT EQUIPMENT INFORMATION TAGS!!

**NOTE:**  
REFER TO SHEET E.0.500  
FOR ALL CEILING MOUNTED  
LOW VOLTAGE DEVICES.  
REFER TO SHEET E.0.501  
FOR INSTALLATION OF LOW  
VOLTAGE DEVICES.

NOTE:  
SEE SHEET E.O.101 FOR  
LIGHTING FIXTURE AND  
TRACK SCHEDULES

NOTE:  
PRIOR TO START ANY  
INSTALLATION WORK, G.C.  
SHALL VERIFY FINAL LOCATION  
SYSTEM PLANS AS REQUIRED  
FOR THIS PROJECT (CCTV,  
SENSORMATIC, ETC.)

NOTA:  
SE DEBERA REVISAR LA ALTURA  
TOTAL EXISTENTE EN LOCAL

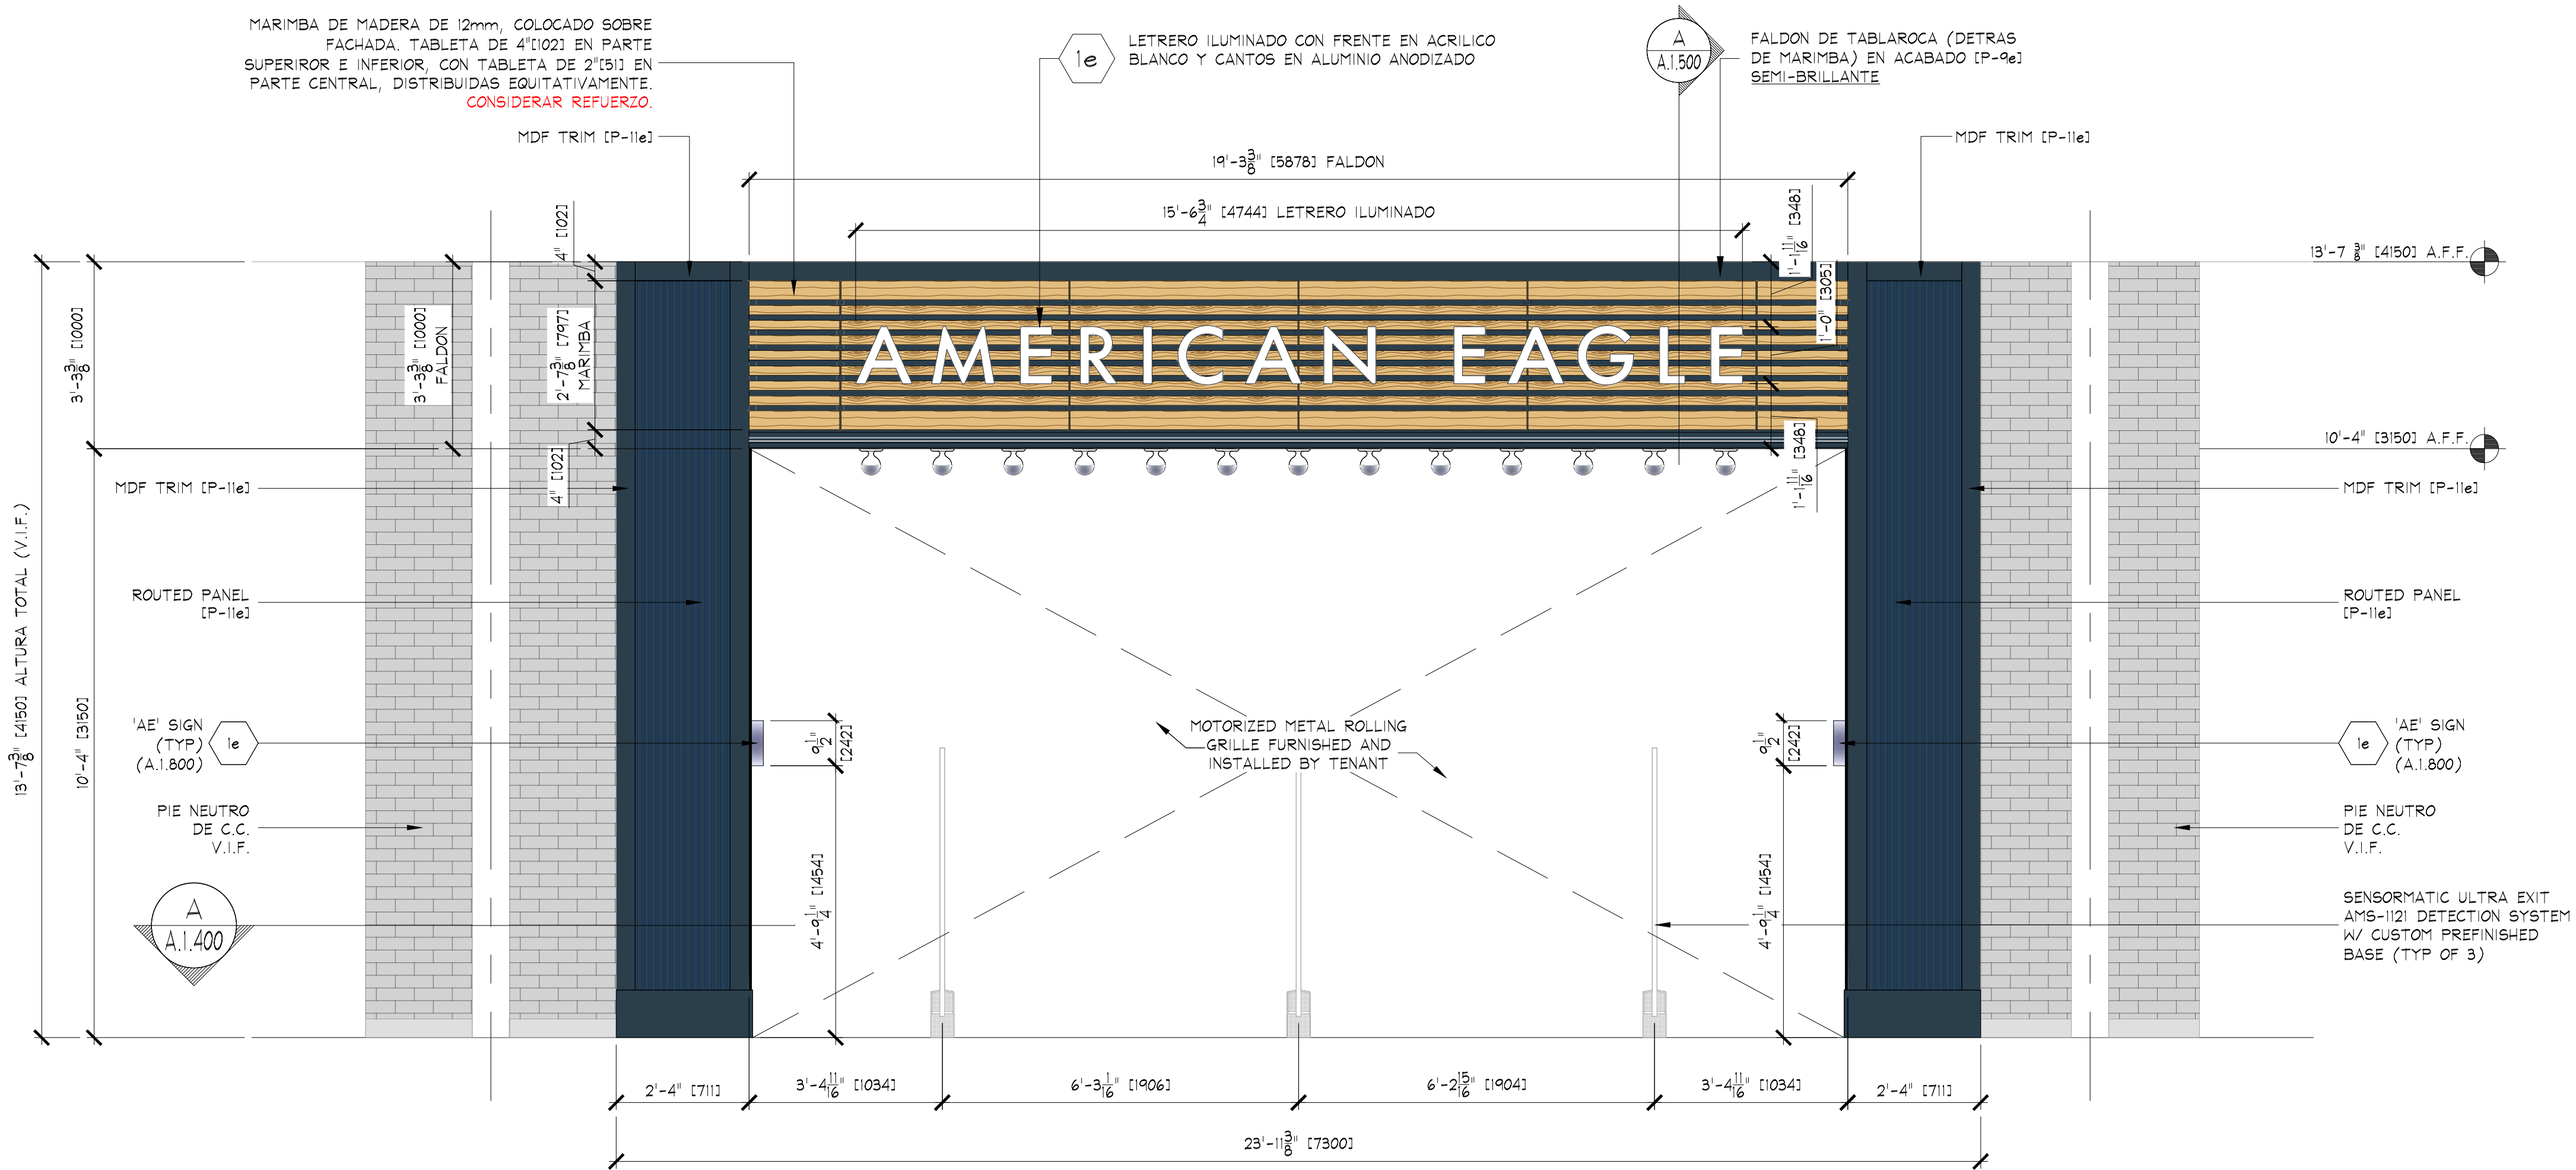


IMPORTANT NOTE:  
VERIFY IN FIELD ALL DIMENSIONS BEFORE ANY WORK.

**A STOREFRONT EXTERIOR ELEVATION**  
SCALE: 1/2" = 1'-0" (1:25)

KEY NOTES:  
SIGN - FURNISHED BY SIGN CONSULTANT,  
INSTALLED BY G.C. - SEE SHEET 'A.1.800'  
FOR MORE INFORMATION.

NOTE:  
DETAILS, NOTES, AND/OR SPECIFICATIONS ON  
THIS SHEET NOT LISTED ALPHABETICALLY OR  
NUMERICALLY HAVE BEEN PURPOSELY OMITTED  
AND DO NOT PERTAIN TO THIS PROJECT.

NOTAS IMPORTANTES:  
• REVISAR CON CENTRO COMERCIAL REQUERIMIENTOS  
DE FACHADA PREVIO A CUALQUIER TRABAJO  
RELACIONADO CON ESTA.

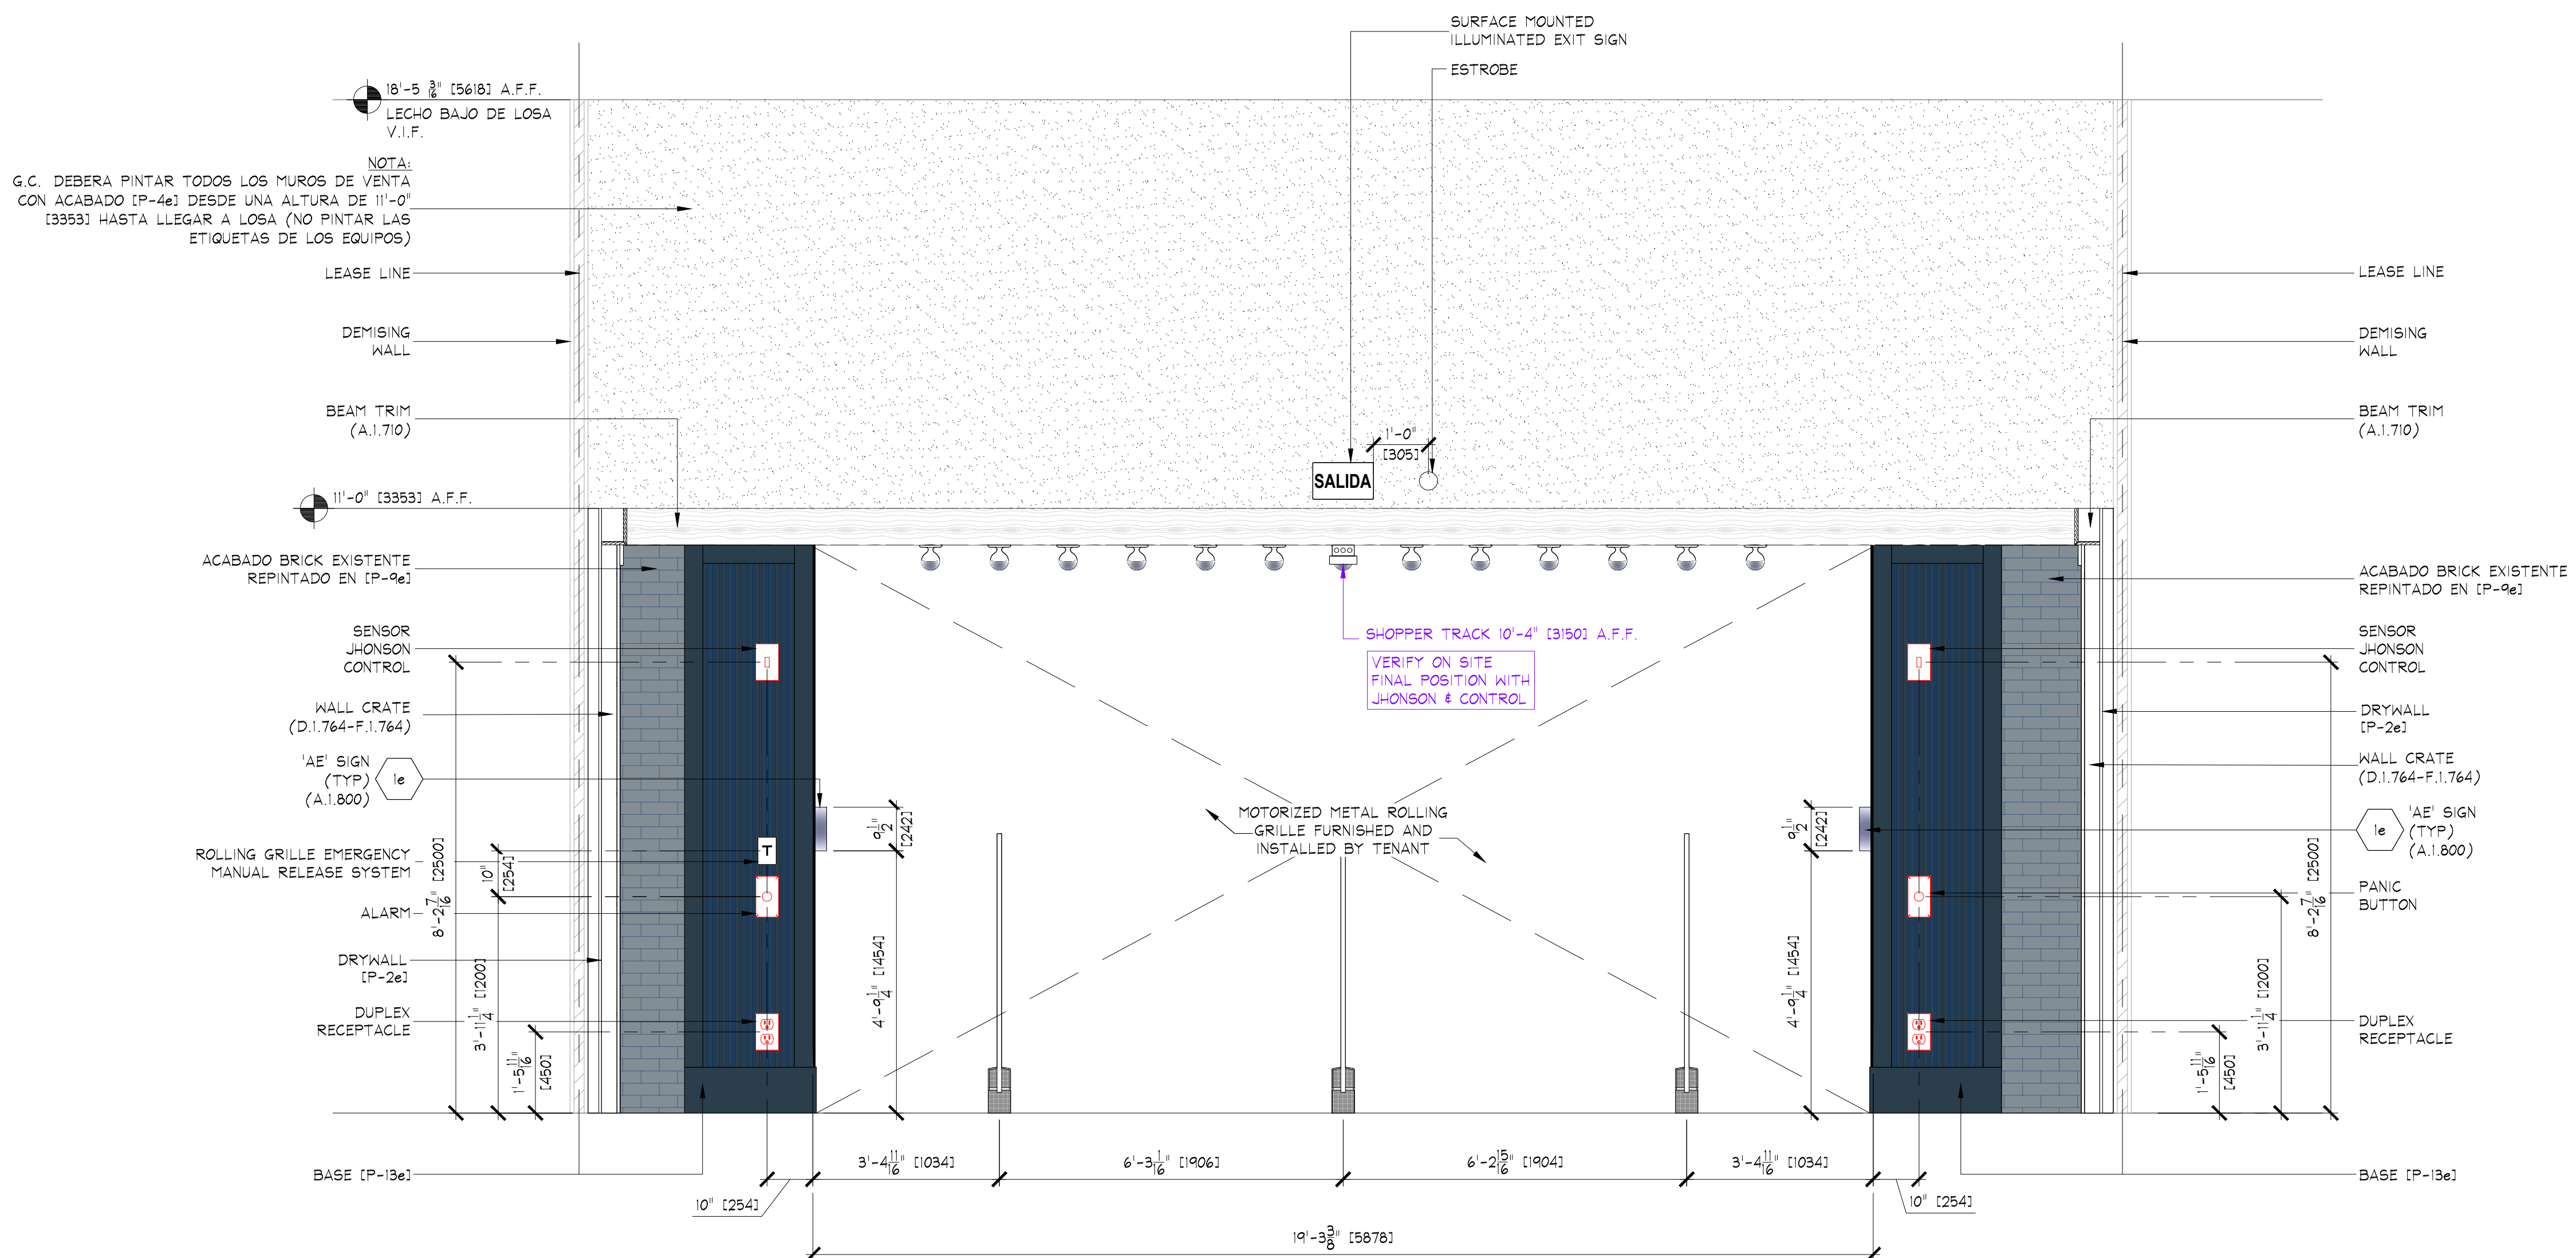

IMPORTANT NOTE:  
VERIFY IN FIELD ALL DIMENSIONS BEFORE ANY WORK.

**B STOREFRONT INTERIOR ELEVATION**  
SCALE: 1/2" = 1'-0" (1:25)

IMPORTANTE  
REVISAR EN SITIO ALTURAS FINALES PREVIO A CUALQUIER TRABAJO EN FACHADA  
NO REALIZAR TRABAJOS DE FACHADASIN VISTO BUENO POR PARTE DE C.C.

