



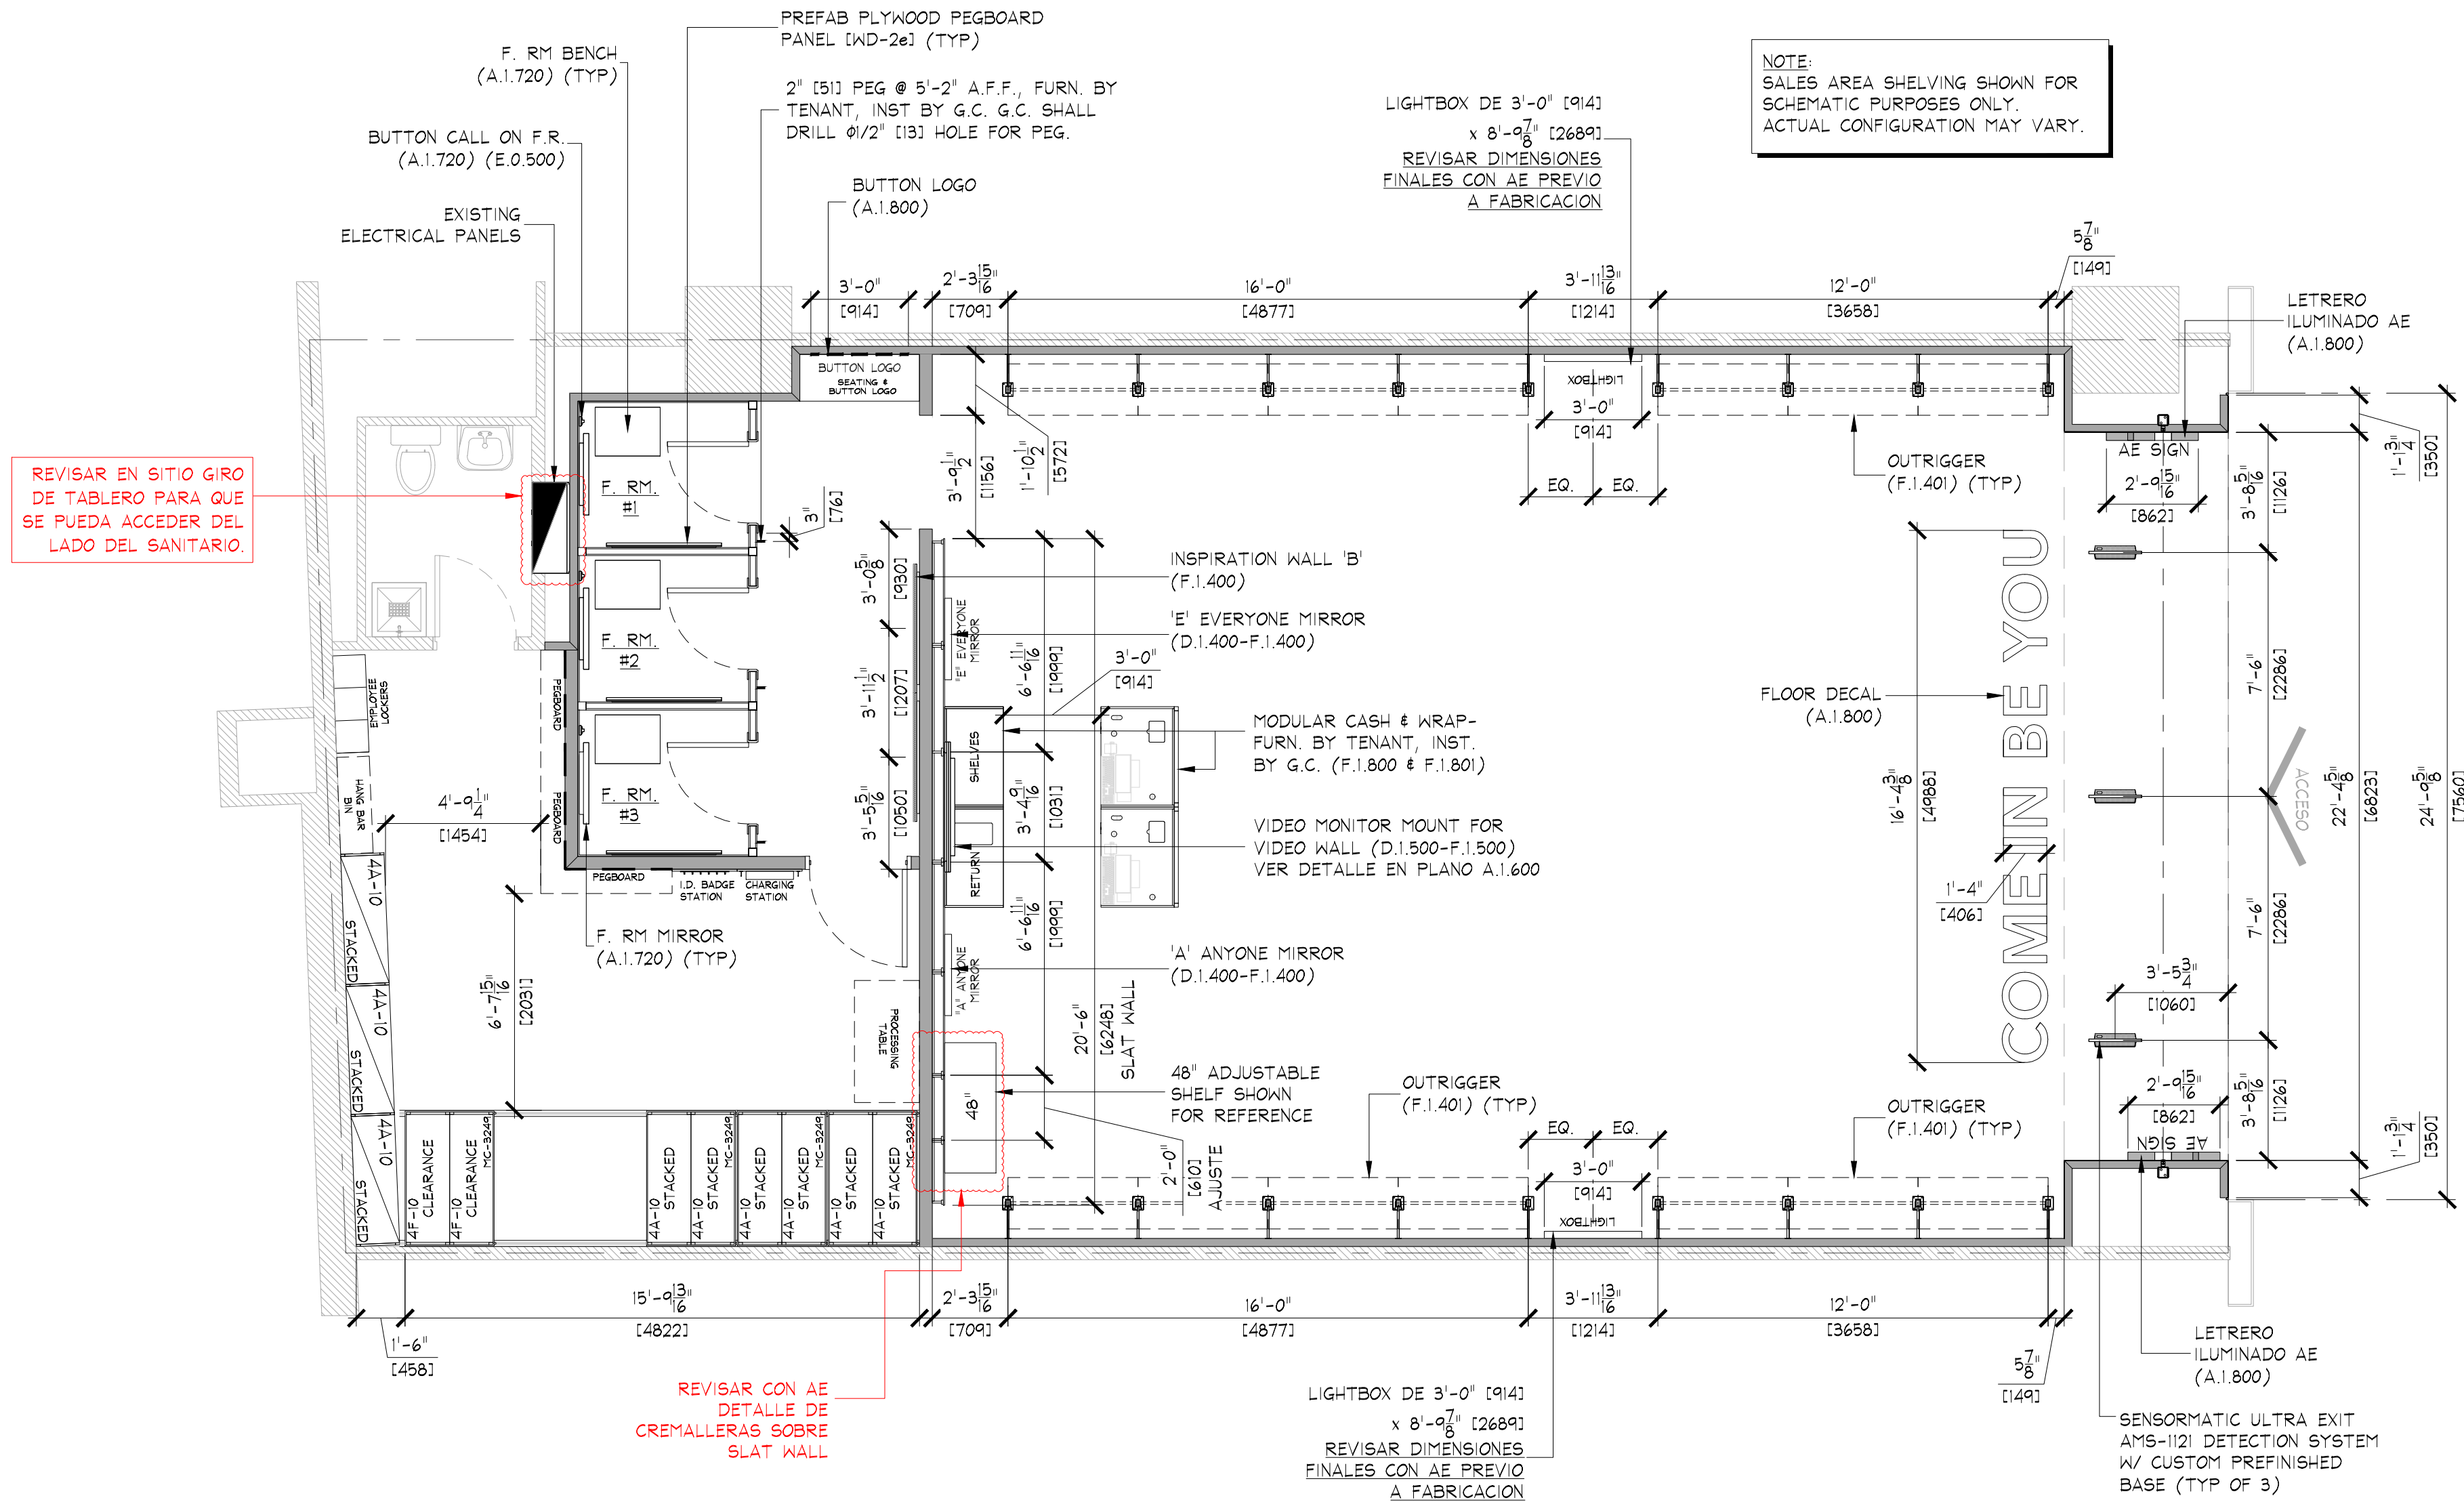

FIXTURE PLAN
SCALE: 1/4" = 1'-0" (1:50)

AREA ANALYSIS			
AREA	m ²	FT ²	%
AE SALES AREA	88.4	1,058	64%
AE FITTING ROOMS	14.1	152	9%
AERIE SALES AREA	0	0	0%
AERIE FITTING ROOMS	0	0	0%
STOCK ROOM	23.3	251	15%
TOILET ROOM	3.1	33	2%
EGRESS CORRIDOR	0	0	0%
AE DISPLAY	0	0	0%
AERIE DISPLAY	0	0	0%
OTHER	0	0	0%
UNUSED	13.7	147	9%
TOTAL	152.5	1642	100%

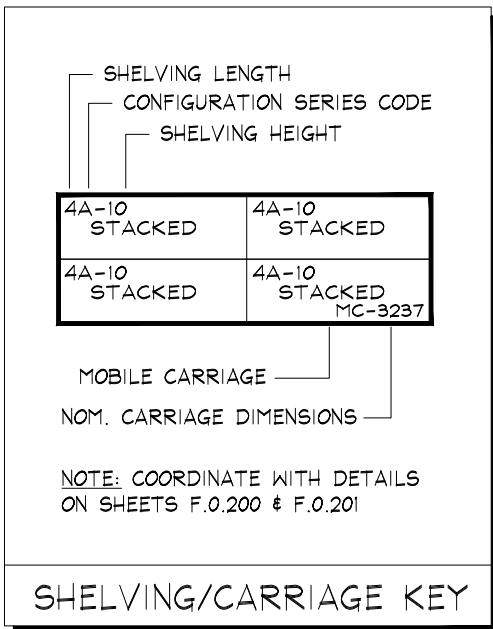

- NOTE:
- SALES AREA SHELVING SHOWN FOR SCHEMATIC PURPOSES ONLY. ACTUAL CONFIGURATION MAY VARY.
 - SEE SHEET F.0.200 & F.0.201 FOR DETAILS OF ALL STOCKROOM SHELVING & SHELVING COMPONENTS. FURNISHED BY TENANT, INSTALLED BY G.C.
 - SEE SHEET F.0.300 FOR DETAILS OF ALL MISC. STOCKROOM FIXTURES FURN. BY TENANT, INST. BY G.C.
 - SEE SHEETS F.1.400, F.1.401 & F.2.400 FOR DETAILS OF ALL MISC. SALES/FITTING ROOM FIXTURES FURN. BY TENANT, INST. BY G.C.
 - G.C. SHALL STRUCTURALLY BRACE ALL 'END CAP' SHELVING AS REQUIRED TO WITHSTAND POSSIBLE IMPACT FROM ROLLING SHELVING.
 - PRIOR TO INSTALLATION OF STOCKROOM SHELVING & STOCKROOM ACCESSORY ITEMS, G.C. SHALL VERIFY THAT ALL STOCKROOM COMPONENTS CAN BE INSTALLED AS SHOWN ON THIS DRAWING. IF FIELD CONDITIONS PROHIBIT INSTALLATION AS SHOWN, OR PRESENT OPPORTUNITIES FOR EXPANSION, G.C. SHALL NOT CONTINUE WITH ANY INSTALLATION AND NOTIFY TENANT FIELD REP IMMEDIATELY.

 SUPPLY AIR DIFFUSER, WHITE COLOR. **DIFFUSOR CIRCULAR PARA ZONAS SIN PLAFON.**
 SUPPLY AIR DIFFUSER (LINEAR), WHITE COLOR. **DIFFUSOR LINEAL PARA ZONAS CON PLAFON.**
 SUPPLY AIR DIFFUSER, WHITE COLOR. **DIFFUSOR CUADRADO PARA ZONAS CON PLAFON.**
 AREA PARA CORTINA DE AIRE EN ACCESO A TIENDA.
 RETURN / EXHAUST REGISTER (OR GRILLE), WHITE COLOR
 PENDANT MTD. EMERGENCY LIGHT
 SURFACE EMERGENCY LIGHT
 EXIT SIGN
 COLOCAR SOBRE MOLDURA/FALDON (VER PLANO A.1300)
 ESTROBO
 COLOCAR SOBRE MOLDURA/FALDON (VER PLANO A.1300)
 SHOPPER TRACK
 ALTAURA LIBRE ACORDE A PROTECTOR (VER PLANO A.1300)

2e	STOCKROOM CEILING - NO CEILING, UNLESS REQUIRED BY LANDLORD OR LOCAL BUILDING CODES - [CIT-26]. SUSPENSION SYSTEM SHALL BE SUSPENDED BY USING INTERIORS, INC. DONN CEILING SUSPENSION DIAL SERIES, WHITE EXPOSED 2'x4' GRID SYSTEM.
3e	SIGN - FURNISHED BY SIGN CONSULTANT, TO BE INSTALLED BY G.C. SEE SHEET A1.800 FOR MORE INFORMATION.
4e	REGISTRO EN MURO Y/O PLAFÓN DE 1'-3 3/4" (400) x 1'-3 3/4" (400) EN ACABADO A GULAR INDICADO EN PLANTILLA REQUERIDA, POR G.C.
5e	KIND-LOCK PANELS SHALL BE MANUFACTURED BY ACCESS-LOCK, STEALTH™ PANEL AT-AP0204 (TYP.). G.C. SHALL FURNISH ALL THE INSTALLATION REQUIREMENTS FOR ALL NEW AND EXISTING ABOVE CEILING COMPONENTS REQUIRING MAINTENANCE ACCESS (e.g. HVAC UNIT CONTROLS, SHUT OFF VALVES, DAMPER CONTROLS, ETC.). LANDLORD SHALL PROVIDE TENANT PROVIDED G.C. WITH THE LOCATION COORDINATE ALL LOCATIONS WITH TENANT FIELD REPRESENTATIVE.
5e	THE STATUS OF EXISTING LIGHTING IN THESE AREAS IS UNKNOWN. G.C. SHALL VERIFY FIELD AND COORDINATE FINDINGS WITH TENANT FIELD REP.

- ALL SUPPORT TRACK AND RELATED COMPONENTS, REQUIRED TO SUPPORT TRACK LIGHTING FIXTURES ONLY, ARE TO BE FURNISHED BY TENANT & INSTALLED BY G.C. - G.C. SHALL ENSURE THAT ALL SUPPORT TRACK IS INSTALLED WITH FIRST CLASS WORKMANSHIP: LEVEL, STRAIGHT, & ALIGNED.
- ALL OTHER EQUIPMENT/COMPONENT SUPPORTS (UNISTRUT, CLAMPS, NUTS, BOLTS, WASHERS, ETC.) FURN. & INST. BY G.C.

THE ORANGE COLOR INDICATES EXISTING ELEMENTS.

ALL COMPONENTS REQUIRED TO SUPPORT AND INSTALL THE SUSPENDED CEILING SYSTEM (WHETHER DRYWALL AND/OR ACOUSTIC TILE), ARE TO BE FURNISHED AND INSTALLED BY G.C. - G.C. SHALL CONSULT WITH MALL/BUILDING DEPARTMENT TO DETERMINE REQUIRED METHODS FOR SUPPORTING CEILING FROM MALL STRUCTURE, PRIOR TO SUBMITTING BID.


- NO WIRING SHALL EXTEND FROM SUPPORT TRACK TO ANY OTHER SUPPORT TRACK, WALL, OR PERIMETER CONSTRUCTION.
- ALL WIRING RUNS SHALL BE STRAIGHT HORIZONTAL OR VERTICAL. STRAP AND SECURE AS REQUIRED TO MAINTAIN ORGANIZED LOOK.
- ALL WIRING AT PERIMETER WALLS SHALL BE STRAPPED NEATLY HORIZONTAL OR VERTICAL AS REQUIRED.
- ALL VALANCE OR PERIMETER WIRING SHALL BE STRAPPED TIGHTLY TO THE TOP OF VALANCE CASE TO ELIMINATE VIEW FROM SALES FLOOR.
- ALL ELECTRICAL BOXES SHOULD BE HELD TIGHT TO WALLS.

NOTE:
SEE SHEET E.0.400 AND/O
E.0.401 FOR ELECTRICAL
INSTALLATION DETAILS.

NOTE:
REFER TO SHEET E.O.500
FOR ALL CEILING MOUNTED
LOW VOLTAGE DEVICES.
REFER TO SHEET E.O.501
FOR INSTALLATION OF LOW
VOLTAGE DEVICES.

NOTE:
PRIOR TO START ANY
INSTALLATION WORK, G.C.
SHALL VERIFY FINAL LOCAL
SYSTEM PLANS AS REQUIRED
FOR THIS PROJECT (CCTV,
SENSORMATIC, ETC.)

NOTA:
SE DEBERA REVISAR LA ALTURA
TOTAL EXISTENTE EN LOCAL

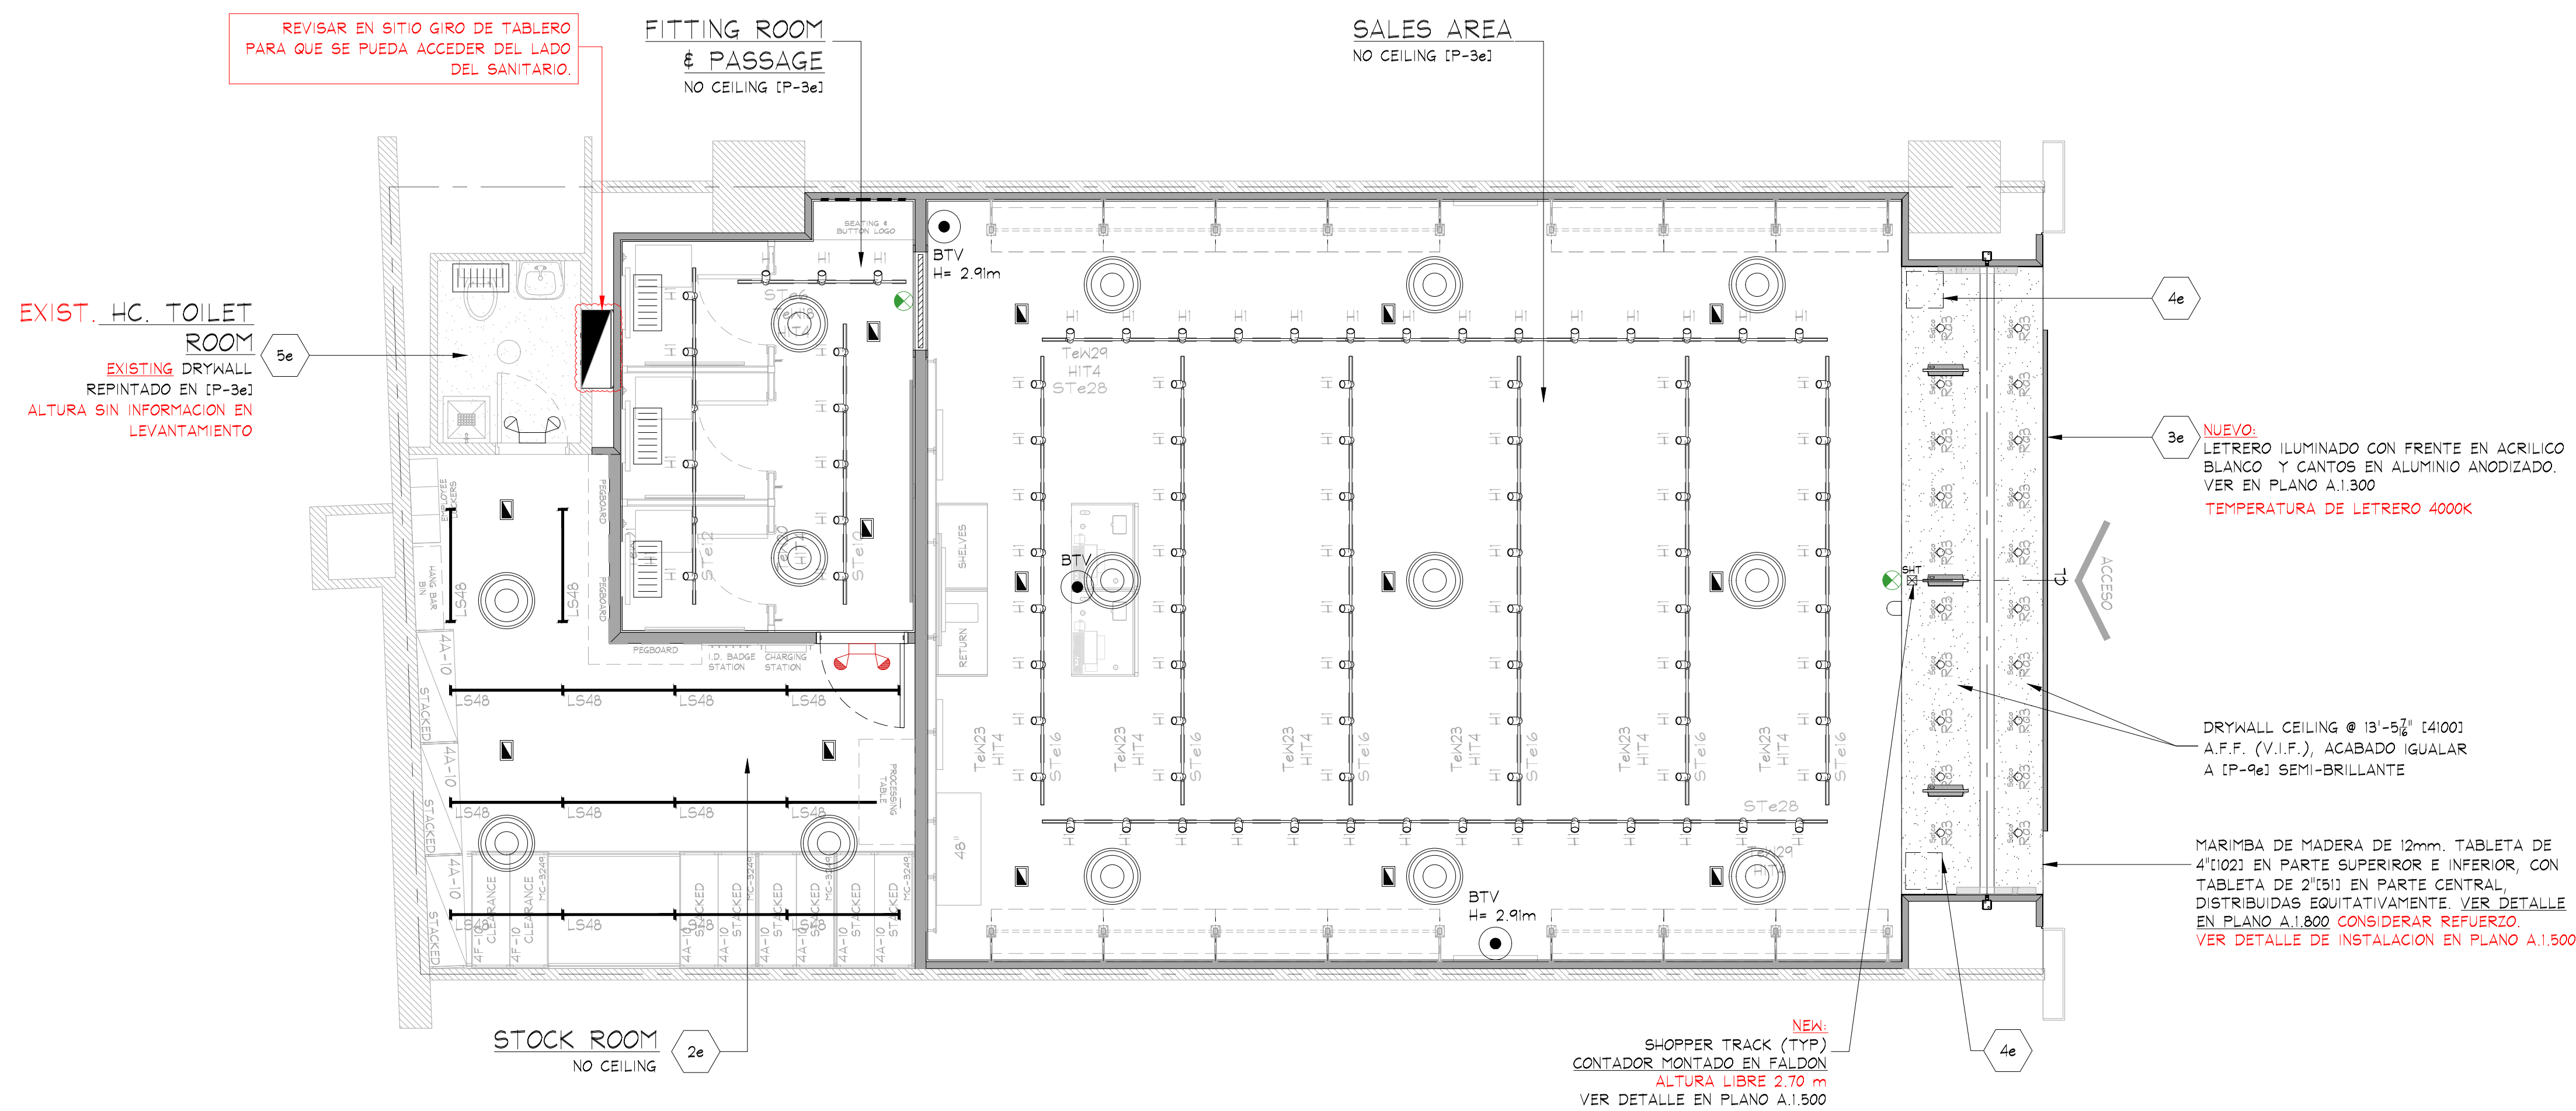

SCALE: 1/4" = 1'-0" [1:50]

IMPORTANTE:
VERIFICAR DIMENSIONES FINALES DE LOCAL.
DIMENSIONES DE LOCAL CON PLANOS DE
INFORMACION PROPORCIONADA DE AE.

THINK ARCHITECTURE S.A. DE C.V.
Descartes 93, 1er piso Col. Anzures
Miguel Hidalgo C.P. 11590 Mexico

THINK ARCHITECTURE
77 Hot Metal Street
Pittsburgh, PA 15203
(412) 432-3300


[illegible]

AMERICAN EAGLE OUTFITTERS
C.C. Santiago Center
República Dominicana
Space # L-345

38030

Drawing No.

1. *Journal of the American Medical Association*, 2000; 283: 2689-2696.


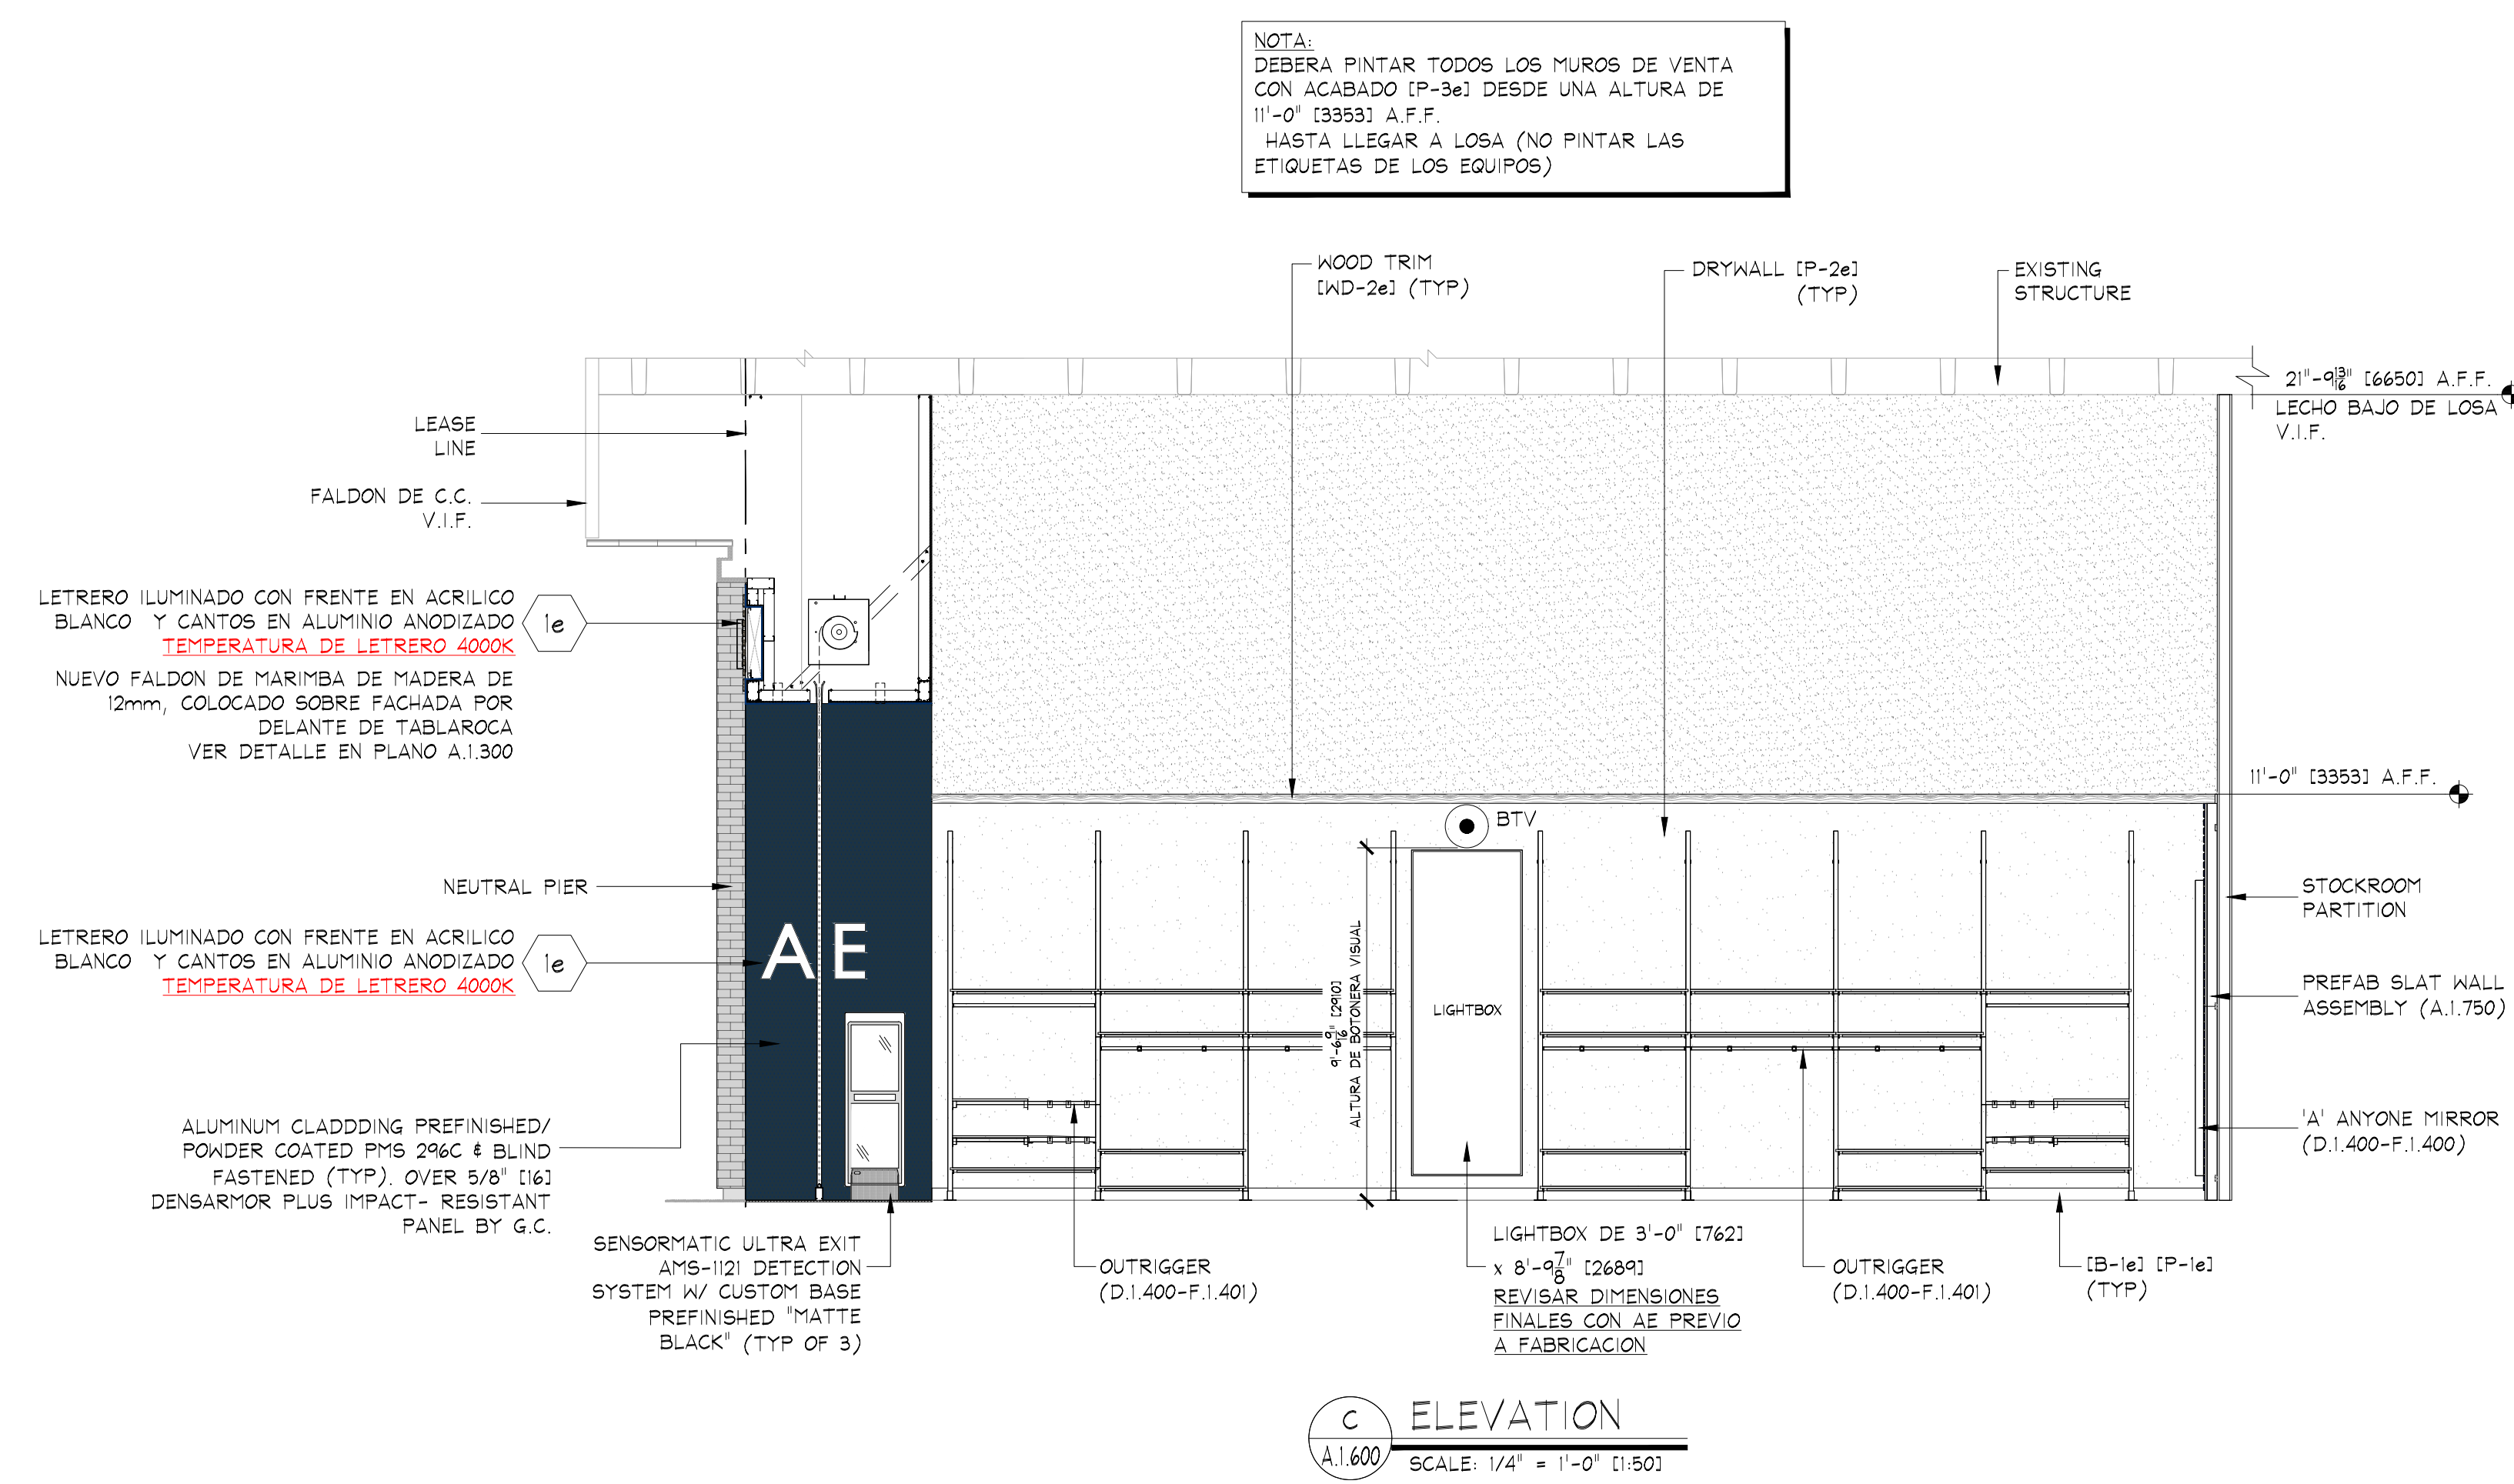


1e SIGN - FURNISHED BY SIGN CONSULTANT, INST
BY G.C., SEE SHEET A.1.800 FOR MORE INFO






NOTE:
PAINTING CONTRACTOR SHALL CAULK ALL
INSIDE WOOD CORNERS AND JOINTS BETWEEN
TRIM & WALL PRIOR TO PAINTING

NOTE:
G.C. SHALL ALIGN DECORATIVE RAFTERS
WITH VERTICAL UPRIGHTS IN PALLET WALL.

NOTE:
DOOR DETAILS SHOWN ARE FOR SCHEMATIC
PURPOSES ONLY. CHECK FLOOR PLAN FOR
ALL SIZES AND SWINGS

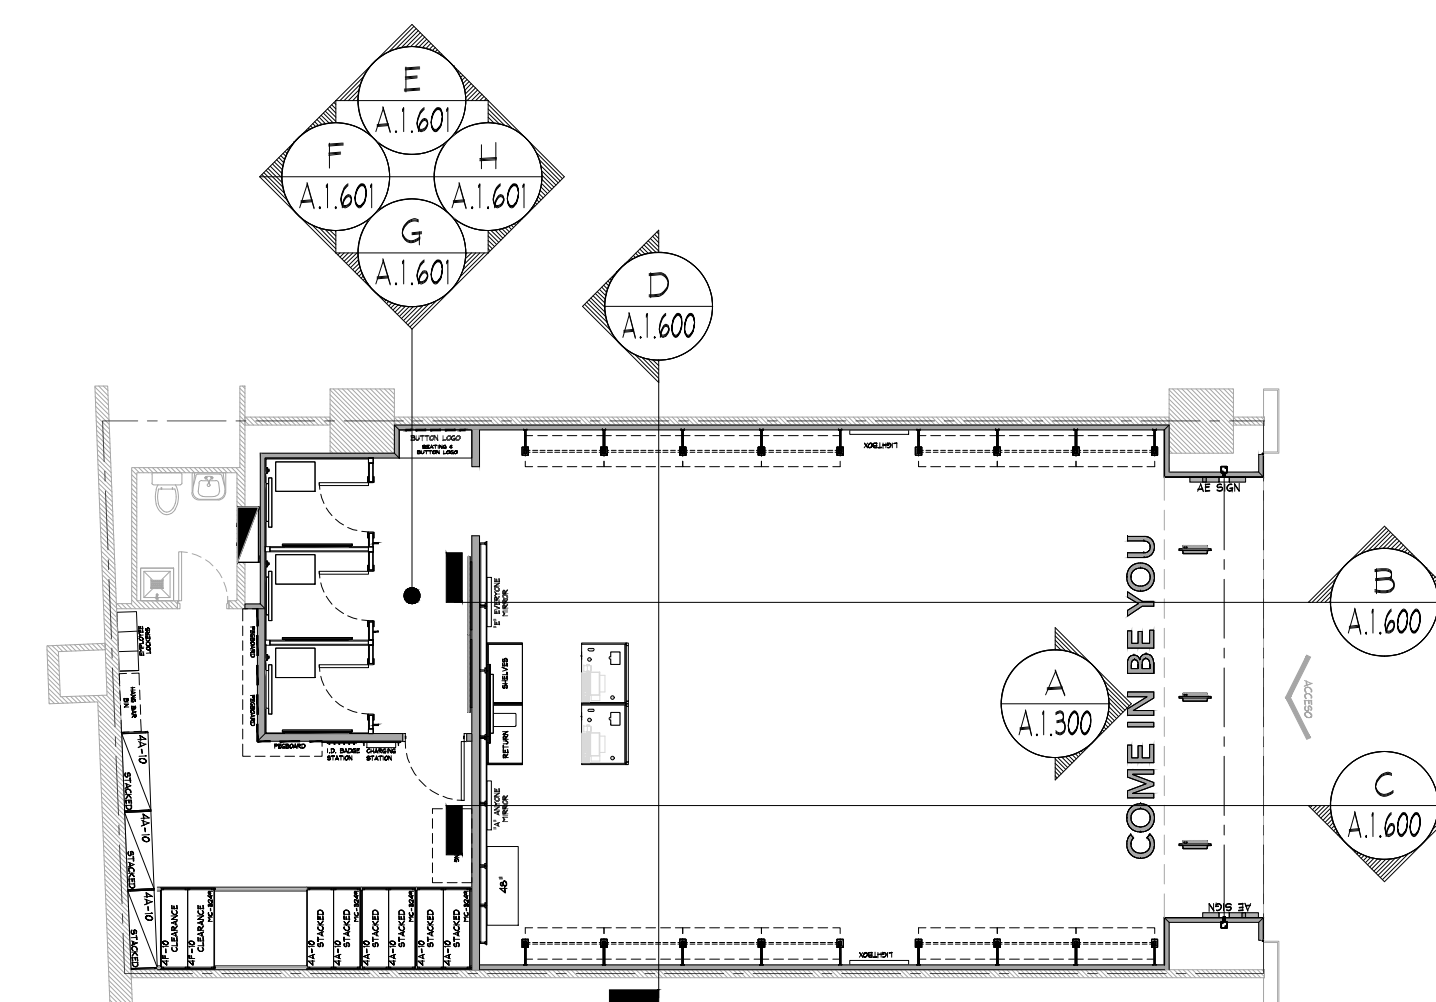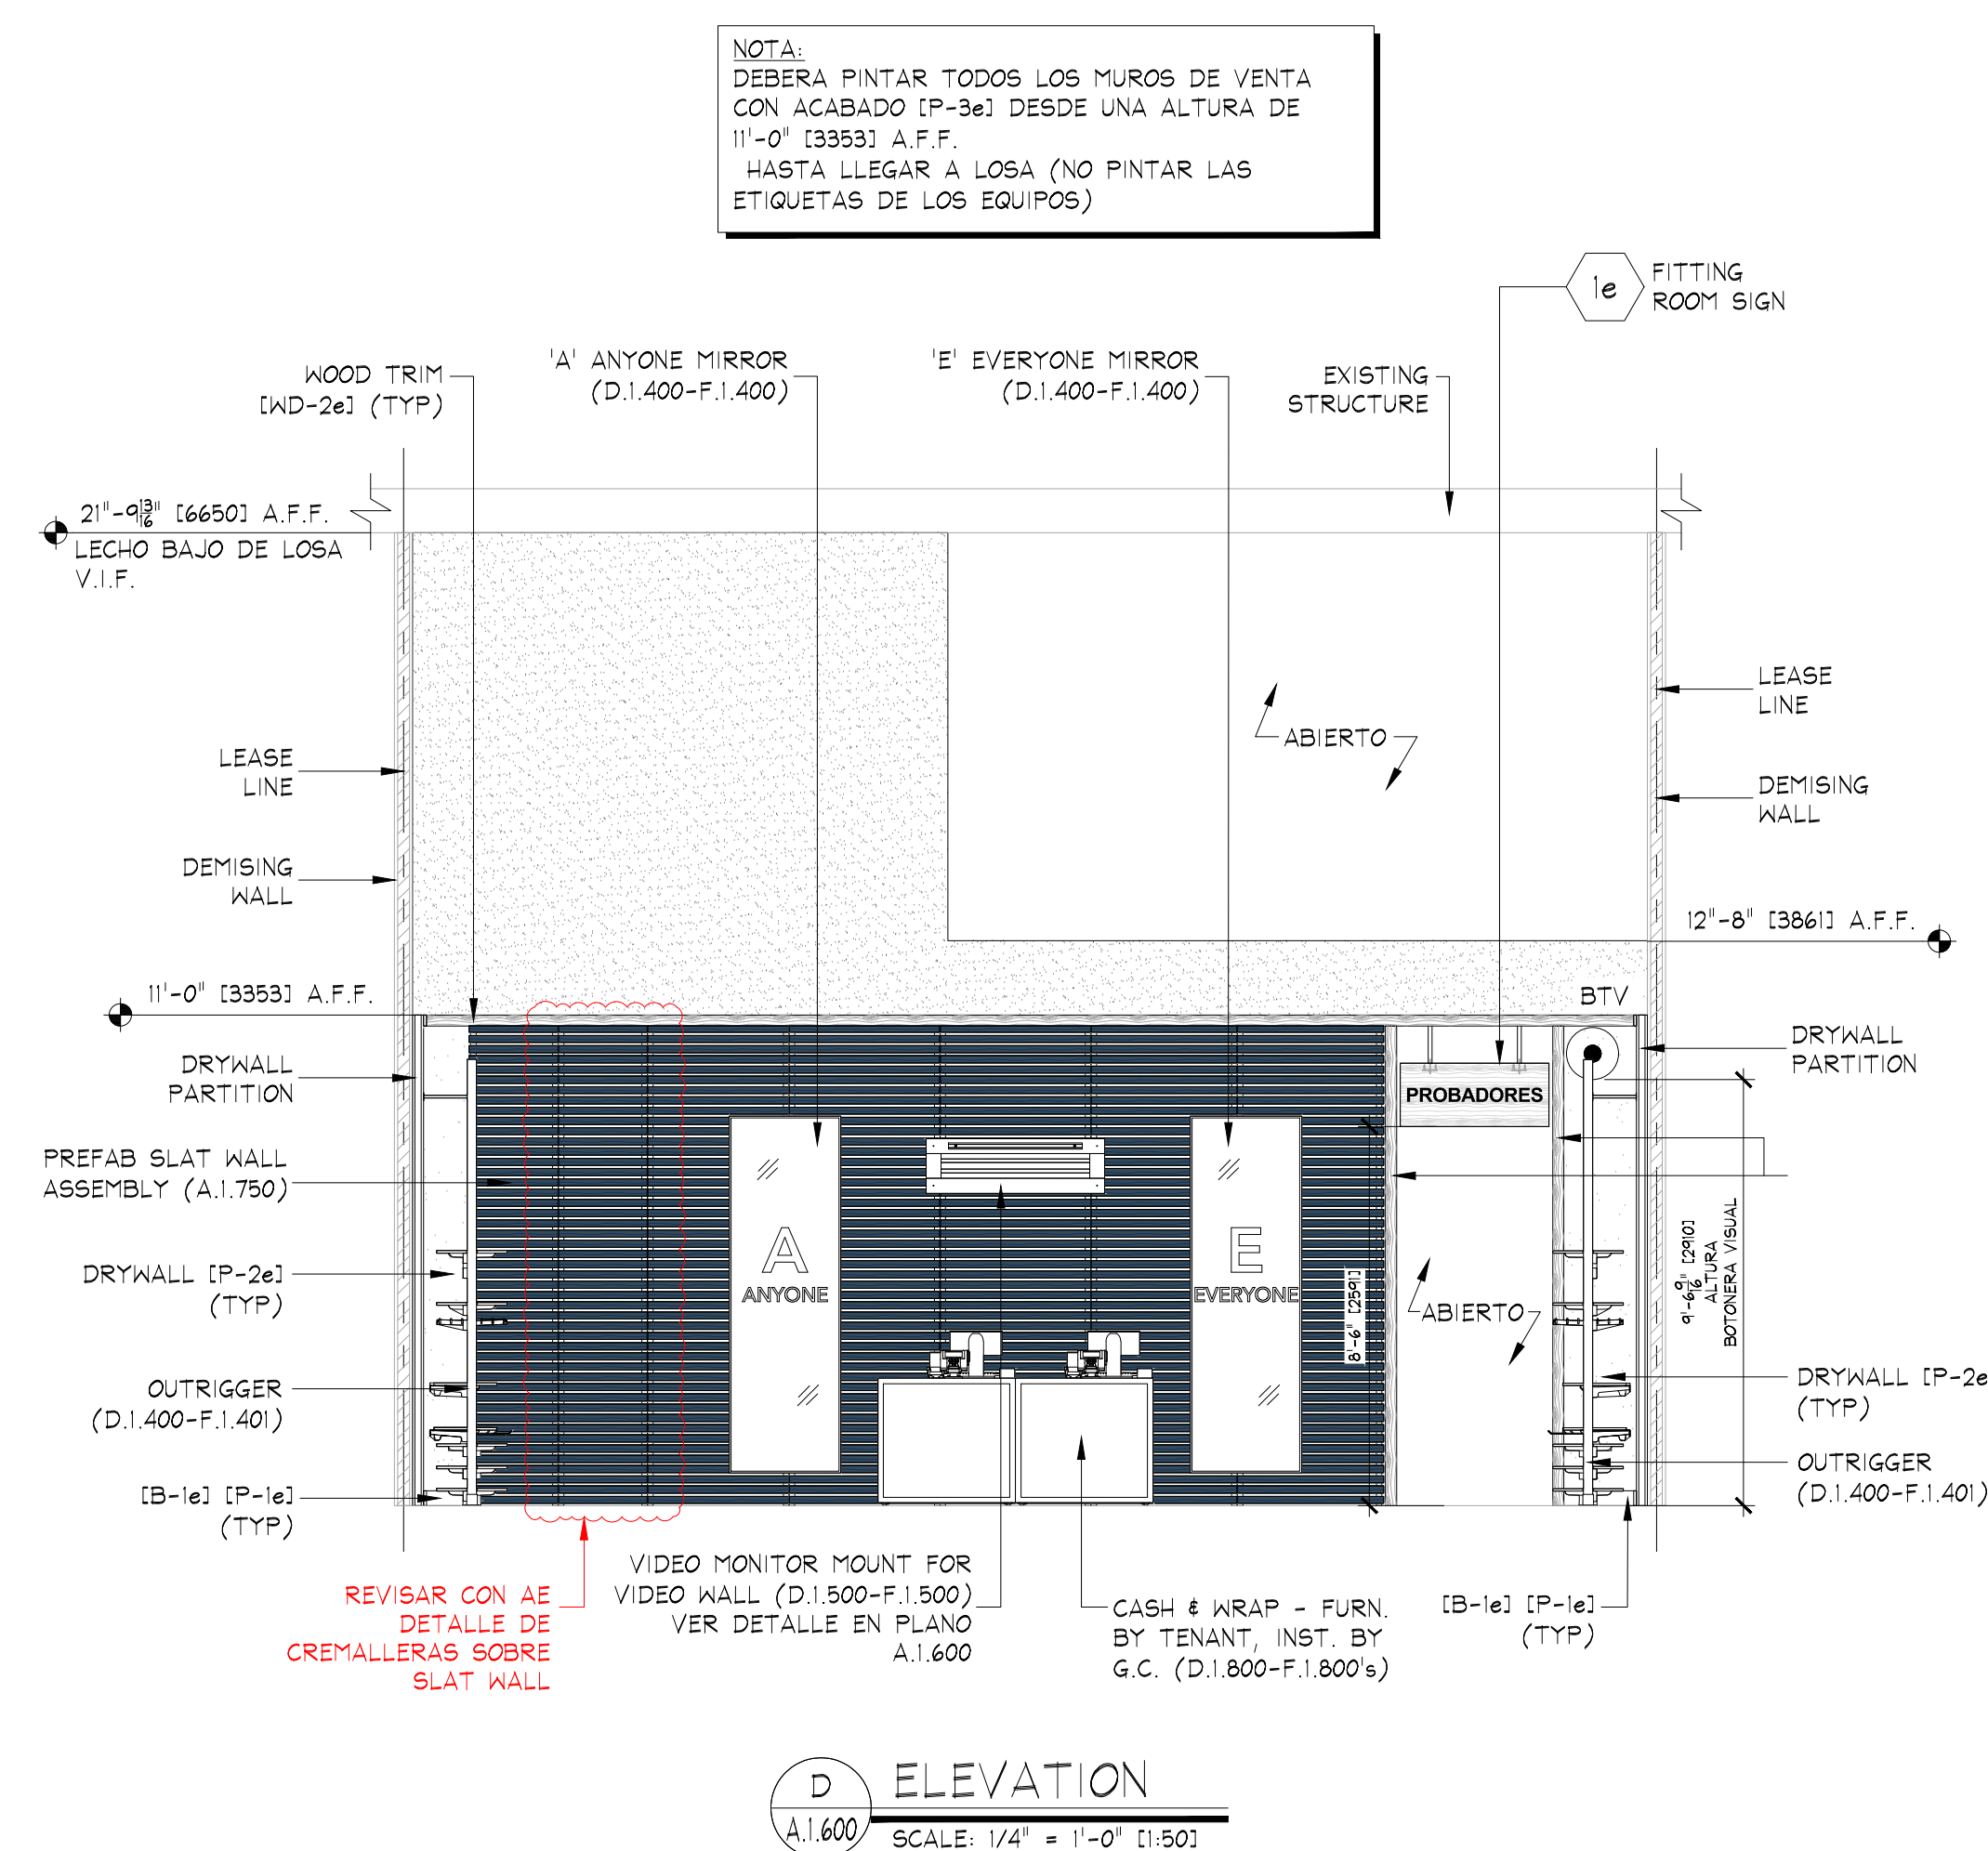

NO SCALE

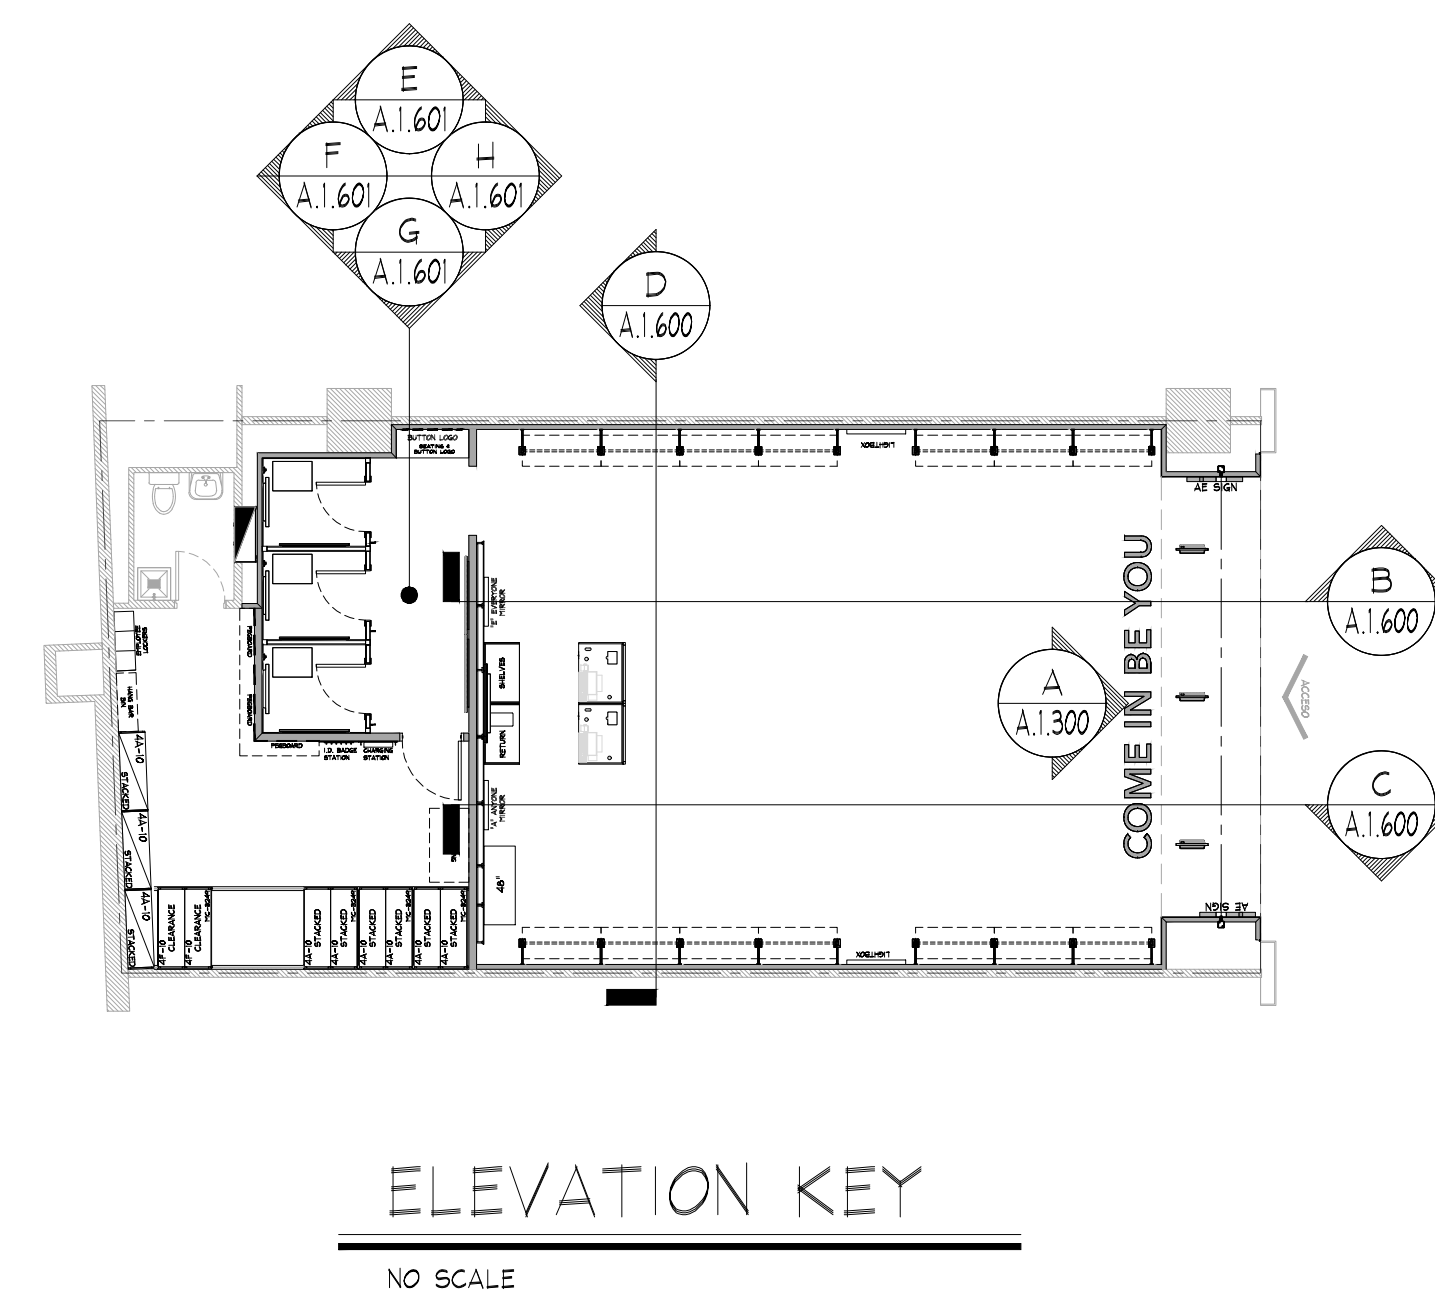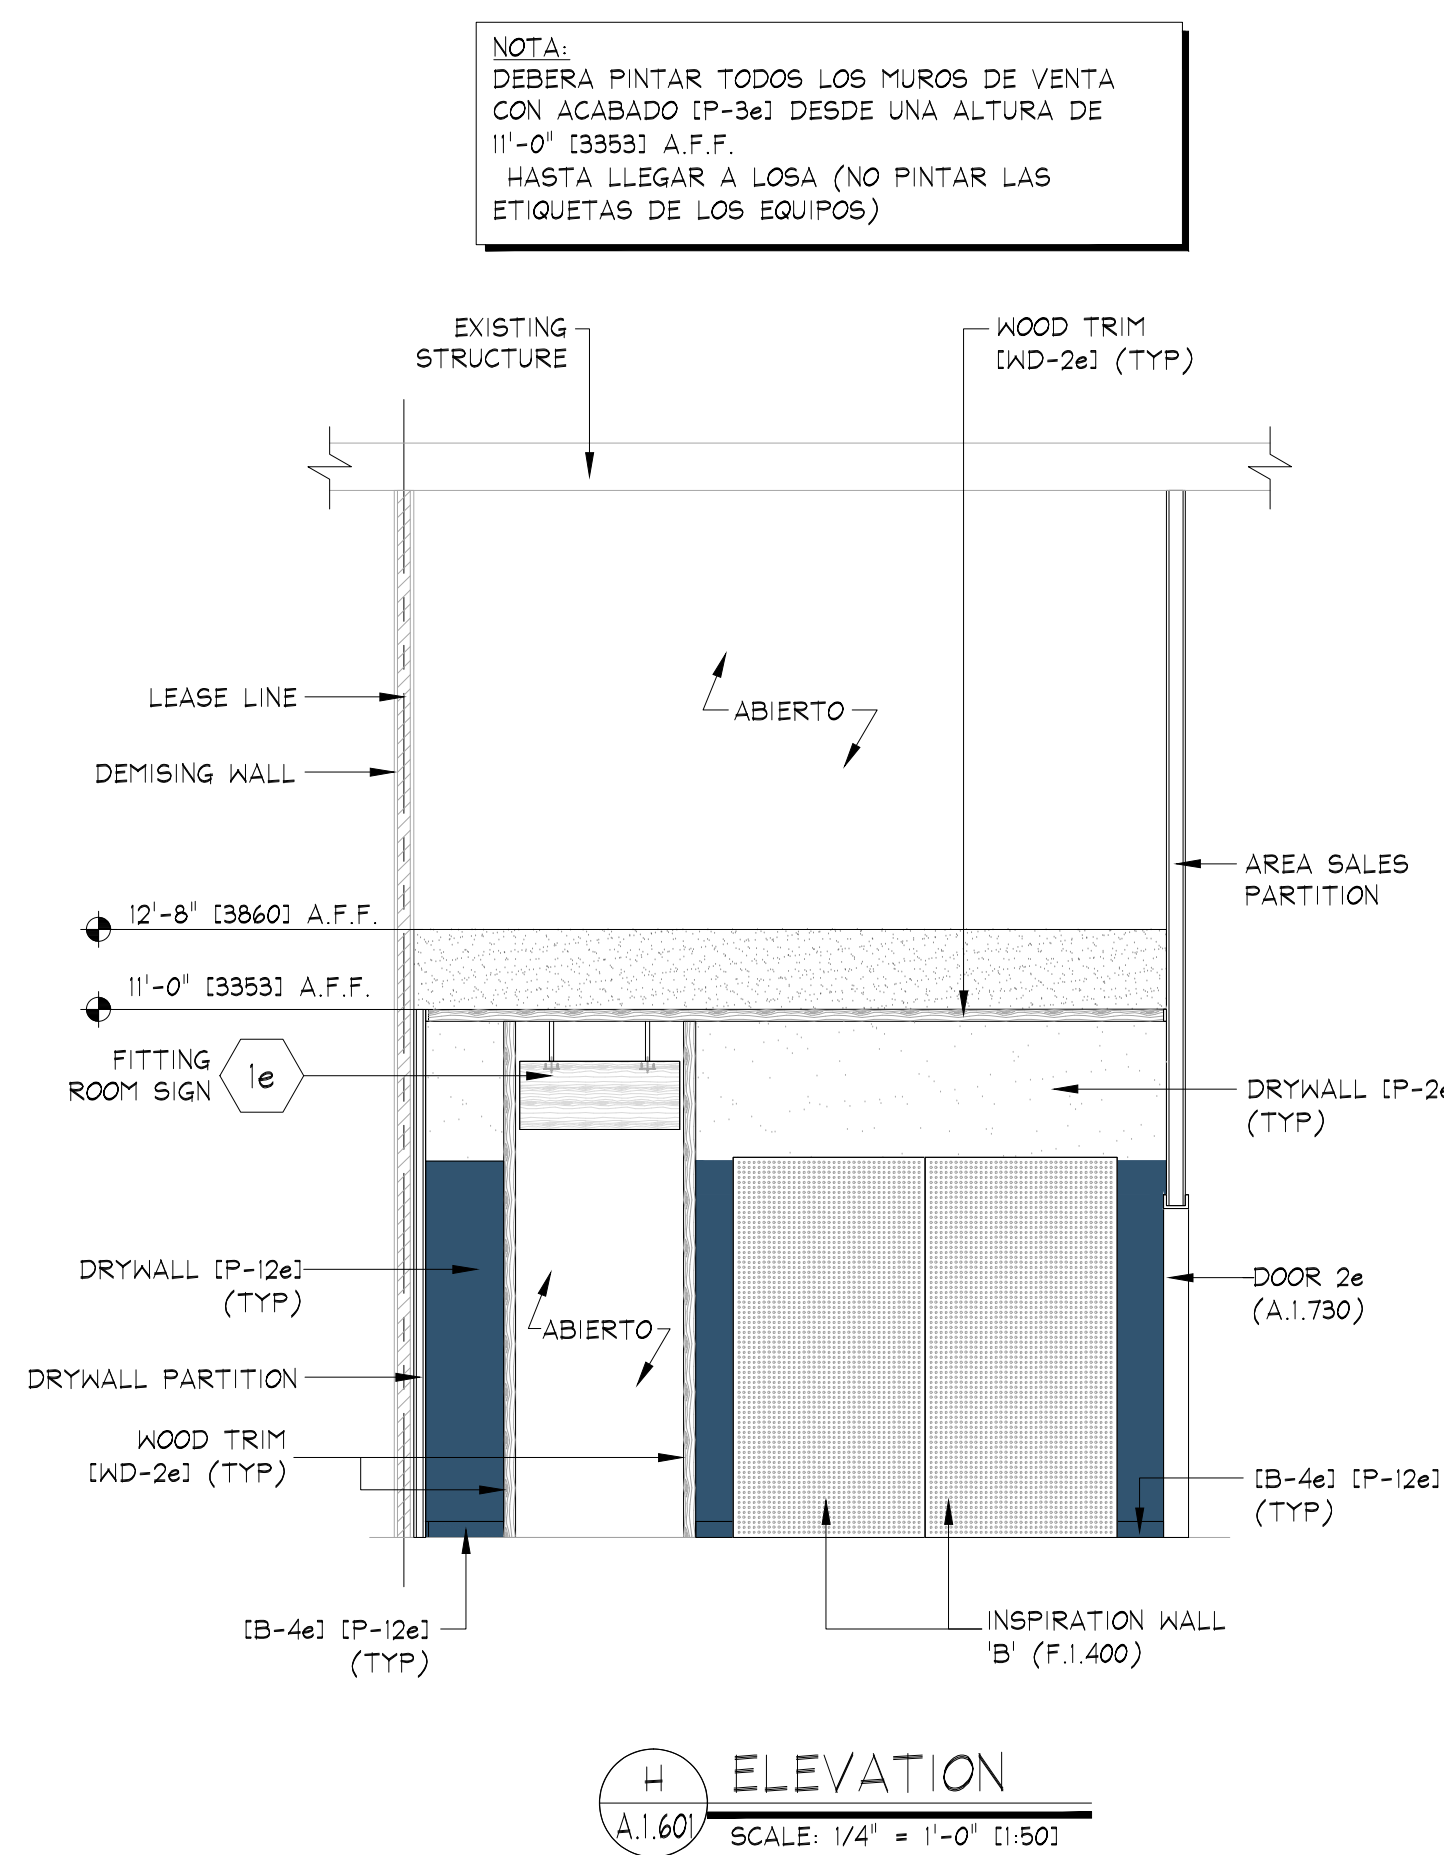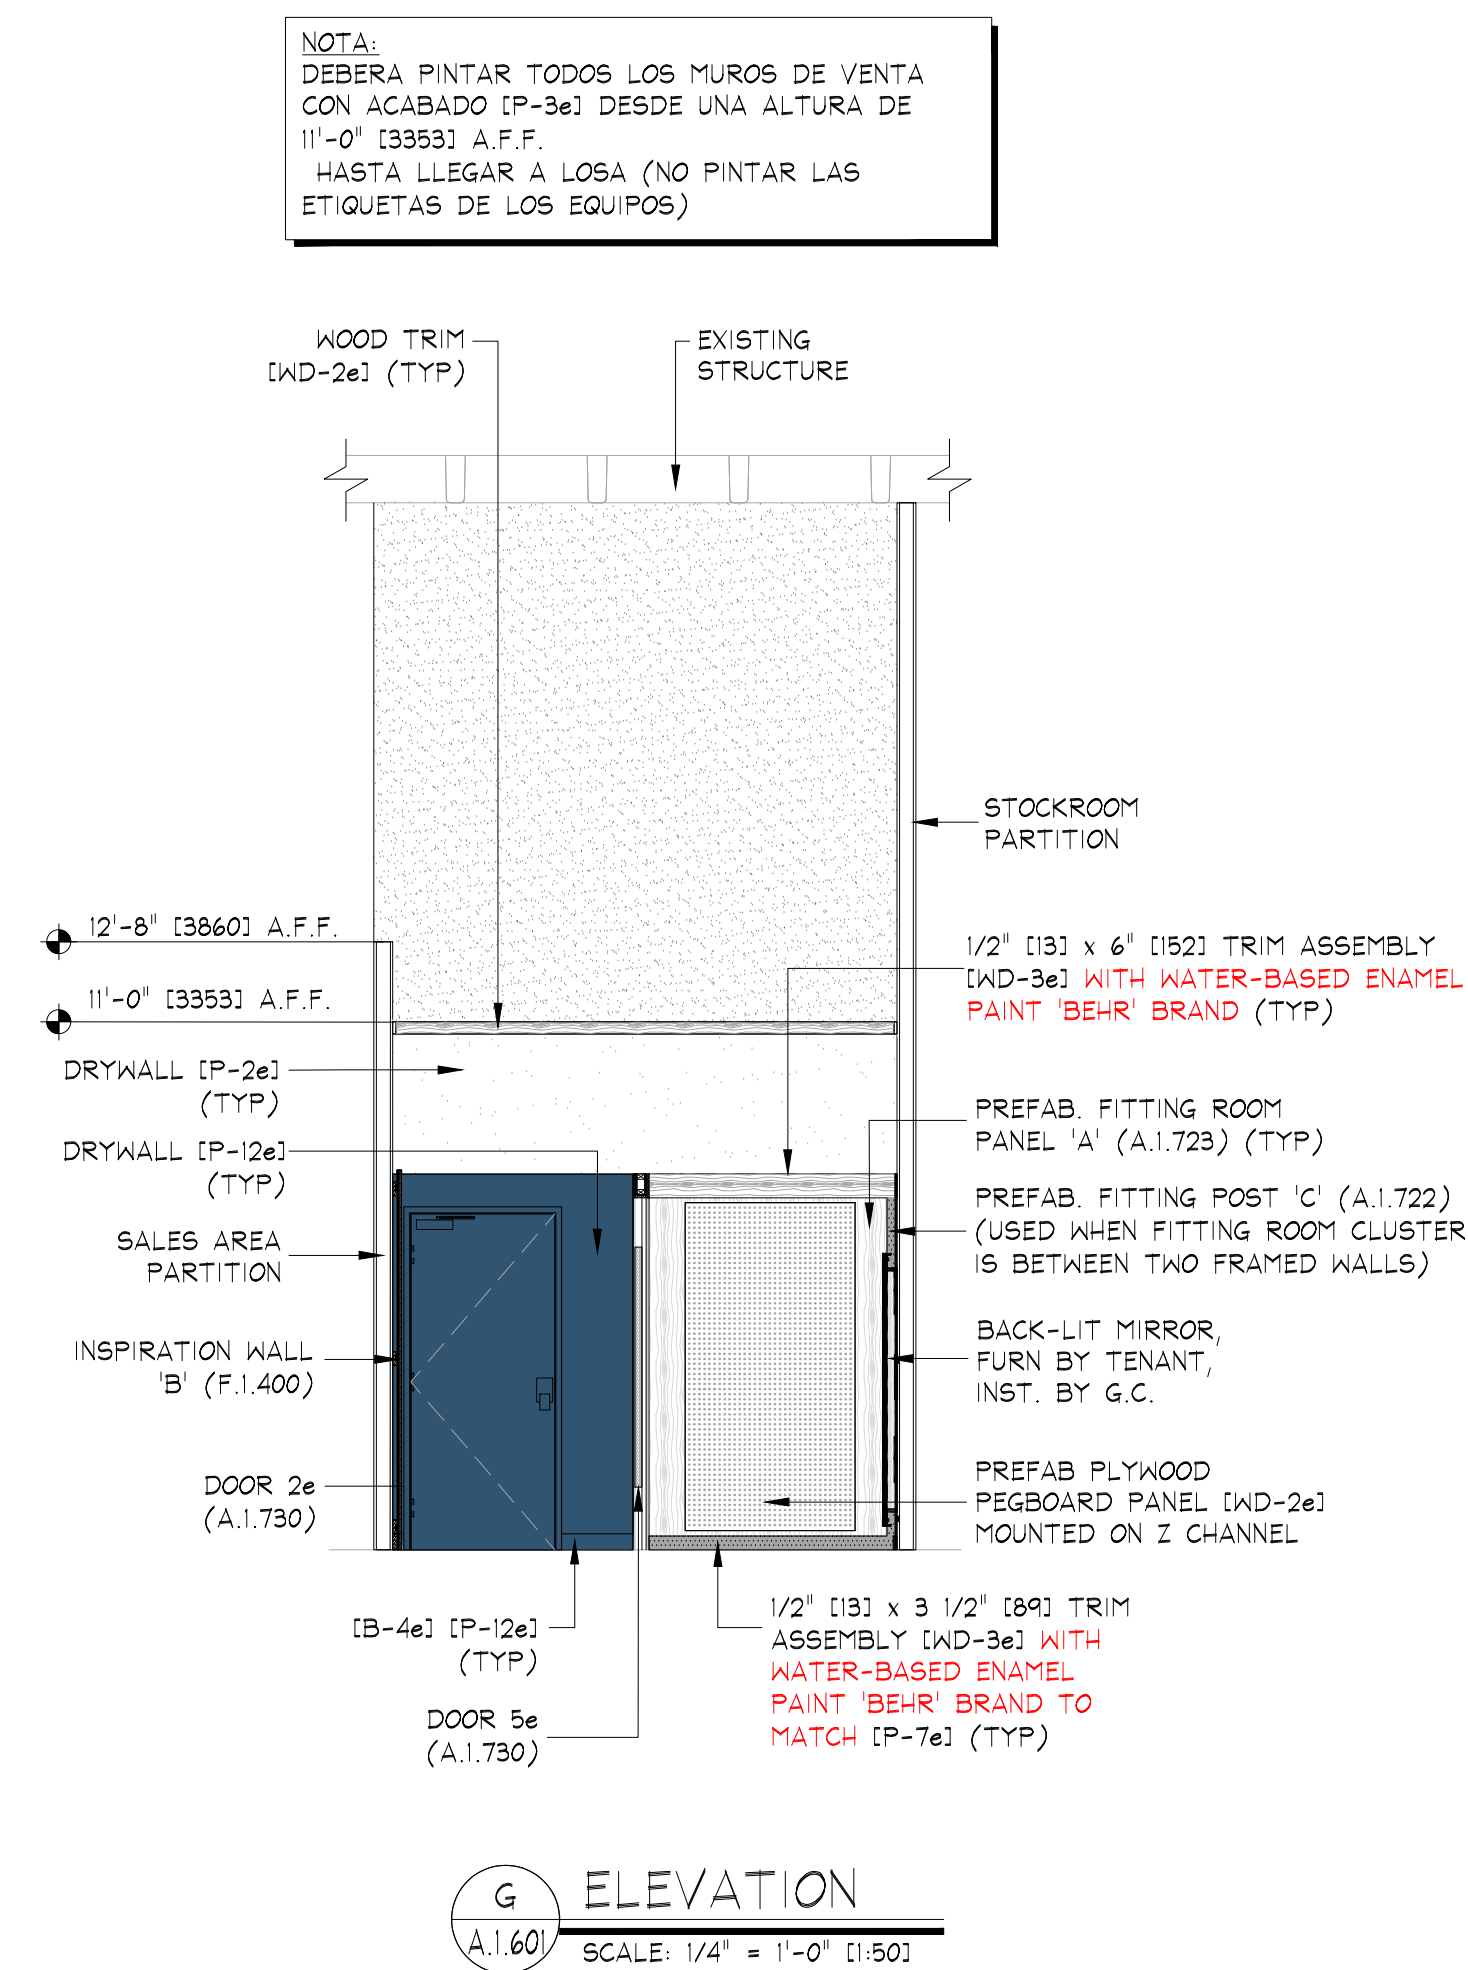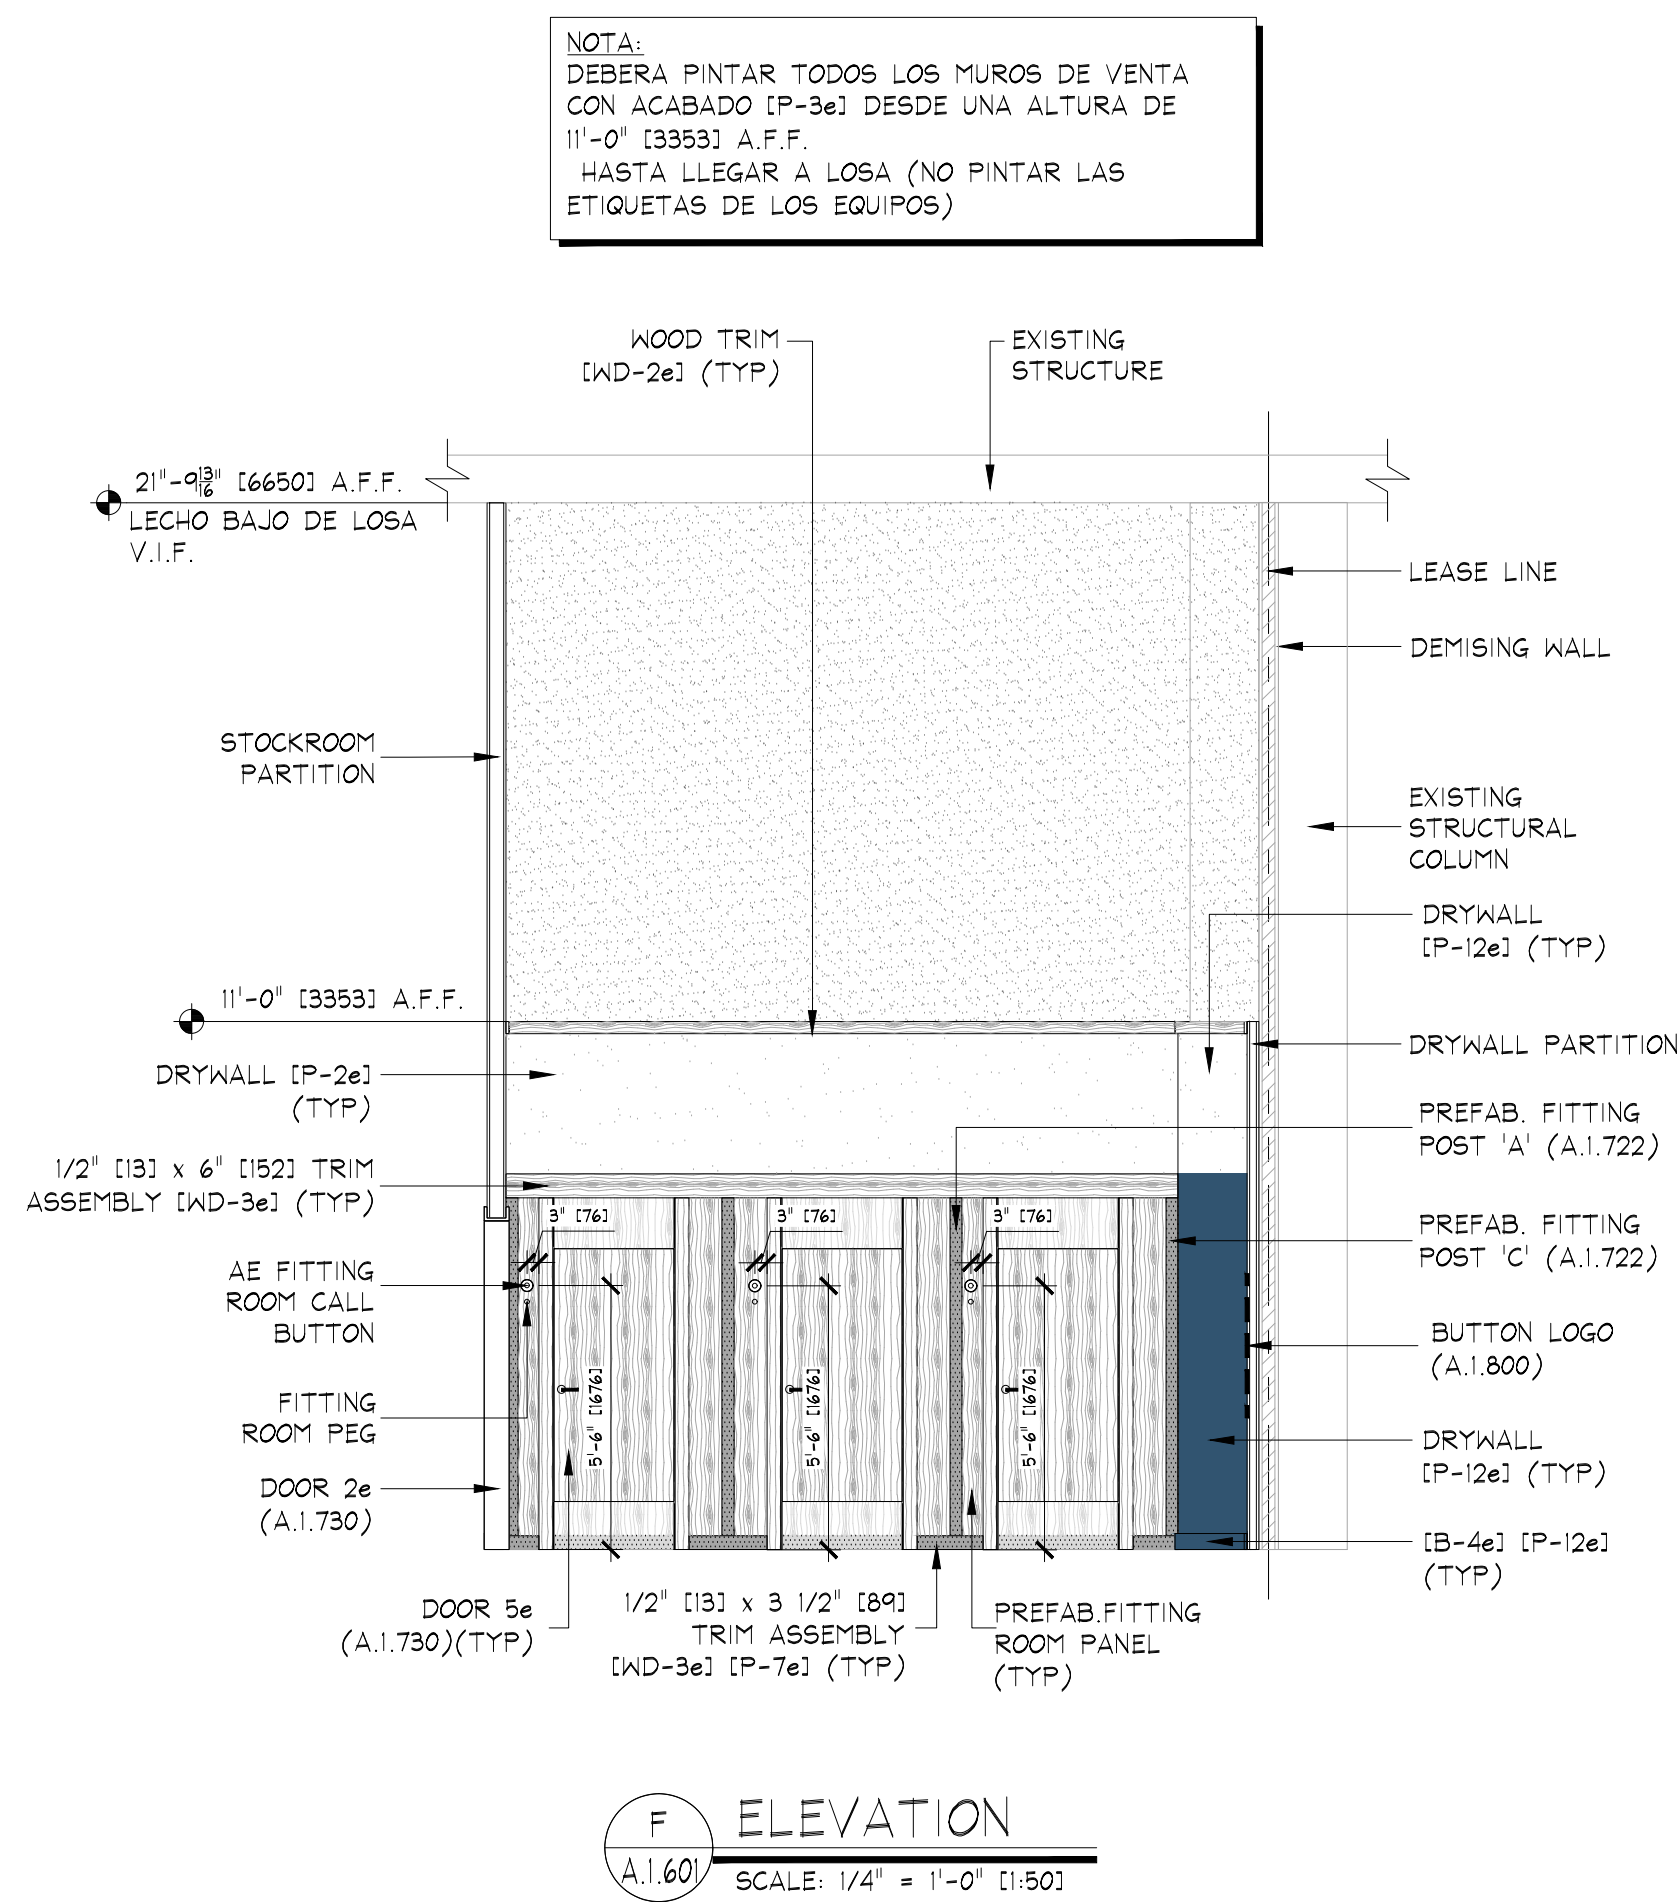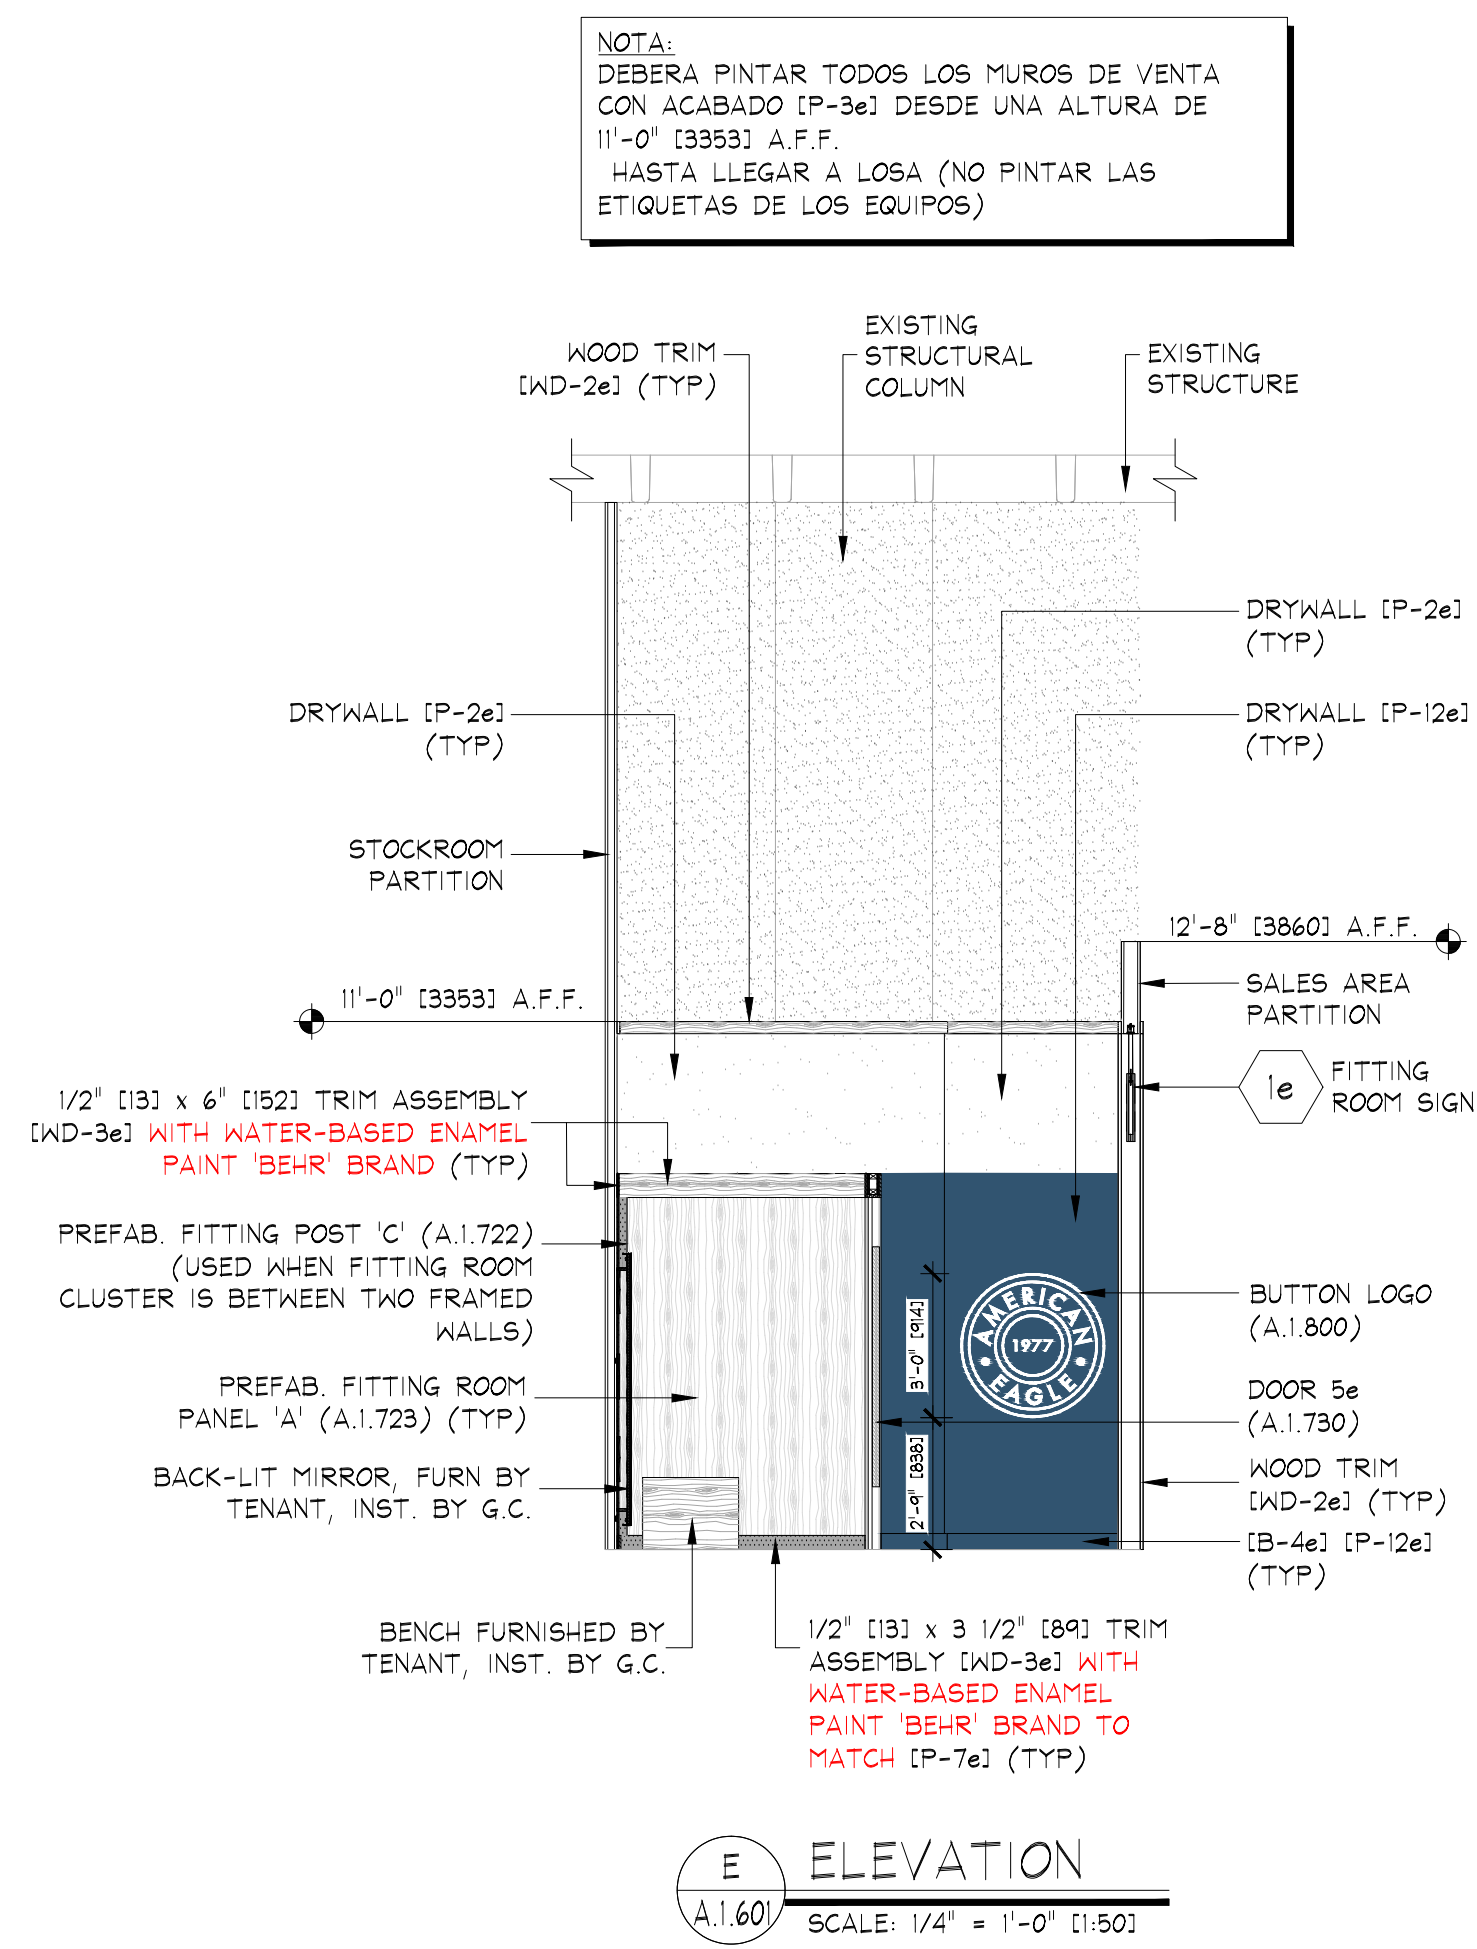

- KEY NOTES:
- 1e SIGN - FURNISHED BY SIGN CONSULTANT, INST. BY G.C., SEE SHEET A.1.600 FOR MORE INFO
- NOTE:
PAINTING CONTRACTOR SHALL CAULK ALL INSIDE WOOD CORNERS AND JOINTS BETWEEN TRIM & WALL PRIOR TO PAINTING
- NOTE:
G.C. SHALL ALIGN DECORATIVE RAFTERS WITH VERTICAL UPRIGHTS IN PALLET WALL.
- NOTE:
DOOR DETAILS SHOWN ARE FOR SCHEMATIC PURPOSES ONLY. CHECK FLOOR PLAN FOR ALL SIZES AND SINGS.