



 THINK	THINK ARCHITECTURE S.A. DE C.V. Descartes 43, 1er piso Col. Anahuac Miguel Hidalgo C.P.11590 Mexico	AMERICAN EAGLE
	AMERICAN EAGLE OUTFITTERS, INC. 1717 Mt. Meru Street Pittsburgh, PA 15203 412-432-3300	

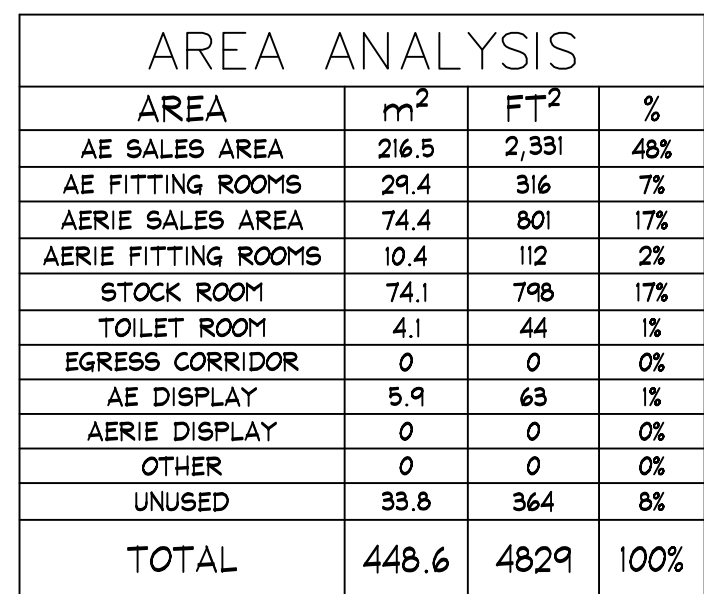

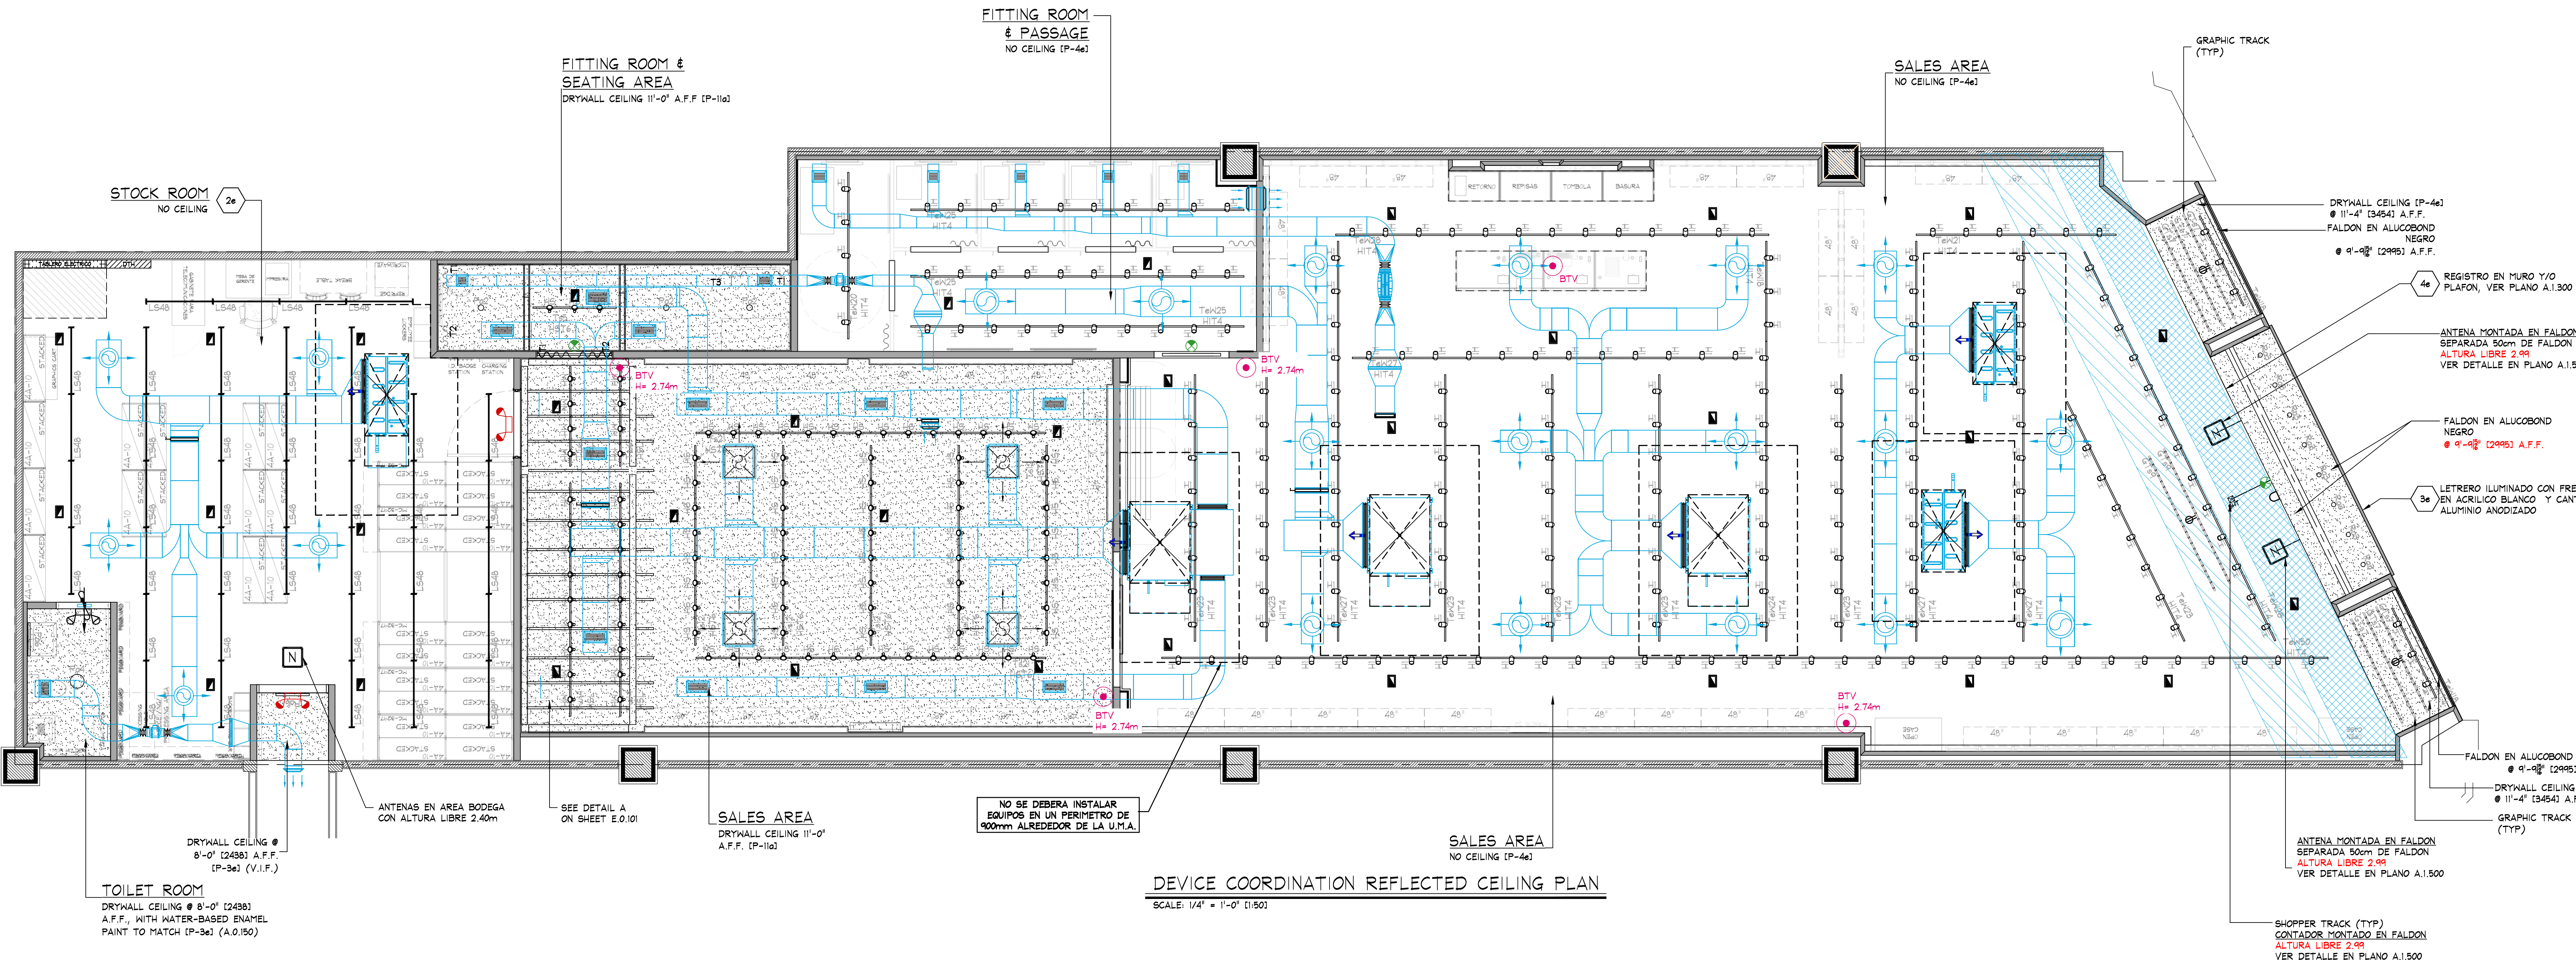

DEVICE COORDINATION REFLECTED CEILING PLAN
SCALE: 1/4" = 1'-0" (1:50)

SYMBOL LEGEND

- ⬢ PENDANT MTD. EMERGENCY LIGHT
- ⌚ SURFACE EMERGENCY LIGHT
- ⊗ EXIT SIGN
COLOCAR SOBRE MOLURA/FALDON
(VER PLANO A.1.300/A.2.300)
- ⊠ ESTROBO
COLOCAR SOBRE MOLURA/FALDON
(VER PLANO A.1.300/A.2.300)
- ⊞ SHOPPER TRACK
ALTURA LIBRE ACORDE A PROYECTO.
(VER PLANO A.1.300/A.2.300)
- ⬢ SECURITY BY OTHERS
ANTENA, ALTURA LIBRE ACORDE A
PROYECTO EN AREA DE VENTA. (VER
PLANO A.1.300/A.2.300)
ANTENA, ALTURA LIBRE EN BODEGA 2.40m

KEY NOTES:

2e STOCKROOM CEILING - NO CEILING, UNLESS REQUIRED BY LANDLORD OR LOCAL BUILDING CODES - (C.T.-2e). SUSPENSION SYSTEM SHALL BE AS MANUFACTURED BY USG INTERIORS, INC. DOWN CEILING SUSPENSION DXL SERIES, WHITE EXPOSED 2'x4' GRID SYSTEM.

3e SIGN - FURNISHED BY SIGN CONSULTANT, INSTALLED BY G.C. SEE SHEET A.1.800 FOR MORE INFORMATION.

4e REGISTRO EN MURO Y/O PLAFON DE 1'-3 1/4" (400) x 1'-3 1/4" (400) EN ACABADO A IGUALAR INDICADO EN UBICACION REQUERIDA, POR G.C.

ACCESS PANELS SHALL BE AS MANUFACTURED BY WIND-LOCK, STEALTH PANEL #TR-AP024 (TYP). G.C. SHALL FURNISH AND INSTALL ACCESS PANELS FOR ALL NEW AND EXISTING ABOVE CEILING COMPONENTS REQUIRING MAINTENANCE ACCESS (e.g. HVAC UNIT CONTROLS, SHUT OFF VALVES, DAMPER CONTROLS, J-BOXES, ETC. - LANDLORD AND/OR TENANT PROVIDED, G.C. TO VERIFY IN THE FIELD). COORDINATE ALL LOCATIONS WITH TENANT FIELD REPRESENTATIVE.

NOTE:
ALL EMERGENCY LIGHTING SHALL BE WIRED "HOT" UN-SWITCHED.

NOTE:
SEE SHEET 'A.0.200' FOR FIXTURE LOCATING DIMENSIONS.

NOTE:
SECURE ALL LIGHTING TRACK TO CEILING WITH TOGGLE BOLTS WHERE OCCURS

NOTE:
SEE SHEET A.0.200 FOR ALL CEILING HEIGHTS.

NOTE:
SEE SHEET E.0.400 AND/OR E.0.401 FOR ELECTRICAL INSTALLATION DETAILS.

NOTE:
ALL HVAC INSTALLATION SHALL BE GRAY COLOR TO MATCH (P-5e) ON AE
ALL HVAC INSTALLATION SHALL BE GRAY COLOR TO MATCH (P-15e) ON AERIE
ALL DIFFUSERS SHALL BE WHITE COLOR

NOTE:
G.C. TO PAINT EVERYTHING ABOVE 11'-4" (P-4e) ON AE
DO NOT PAINT EQUIPMENT INFORMATION TAGS!!

NOTE:
SEE SHEET E.0.101 FOR LIGHTING FIXTURE AND TRACK SCHEDULES

NOTE:
PRIOR TO START ANY INSTALLATION WORK, G.C. SHALL VERIFY FINAL LOCATION SYSTEM PLANS AS REQUIRED FOR THIS PROJECT (CCTV, SENSORMATIC, ETC.)


NOTE:
SE DEBERA REVISAR LA ALTURA TOTAL EXISTENTE EN LOCAL

NOTE:
ALL SUPPORT TRACK AND RELATED COMPONENTS, REQUIRED TO SUPPORT TRACK LIGHTING FIXTURES ONLY, ARE TO BE FURNISHED BY TENANT & INSTALLED BY G.C. - G.C. SHALL ENSURE THAT ALL SUPPORT TRACK IS INSTALLED WITH FIRST CLASS WORKMANSHIP: LEVEL, STRAIGHT, & ALIGNED.
ALL OTHER EQUIPMENT/COMPONENT SUPPORTS (UNISTRUT, CLAMPS, NUTS, BOLTS, WASHERS, ETC.) FURN. & INST. BY G.C.

NOTE:
NO WIRING SHALL EXTEND FROM SUPPORT TRACK TO ANY OTHER SUPPORT TRACK, WALL, OR PERIMETER CONSTRUCTION.
ALL WIRING RUNS SHALL BE STRAIGHT HORIZONTAL OR VERTICAL. STRAP AND SECURE AS REQUIRED TO MAINTAIN ORGANIZED LOOK.
ALL WIRING AT PERIMETER WALLS SHALL BE STRAPPED NEATLY HORIZONTAL OR VERTICAL AS REQUIRED.
ALL VALANCE OR PERIMETER WIRING SHALL BE STRAPPED TIGHTLY TO THE TOP OF VALANCE CASE TO ELIMINATE VIEW FROM SALES FLOOR.
ALL ELECTRICAL BOXES SHOULD BE HELD TIGHT TO WALLS.

NOTE:
ALL COMPONENTS REQUIRED TO SUPPORT AND INSTALL THE SUSPENDED CEILING SYSTEM (WHETHER DRYWALL AND/OR ACOUSTIC TILE), ARE TO BE FURNISHED AND INSTALLED BY G.C. - G.C. SHALL CONSULT WITH MALL/BUILDING DEPARTMENT TO DETERMINE REQUIRED METHODS FOR SUPPORTING CEILING FROM MALL STRUCTURE, PRIOR TO SUBMITTING BID.

IMPORTANT:
ORANGE COLOR INDICATES STRUCTURAL ELEMENTS

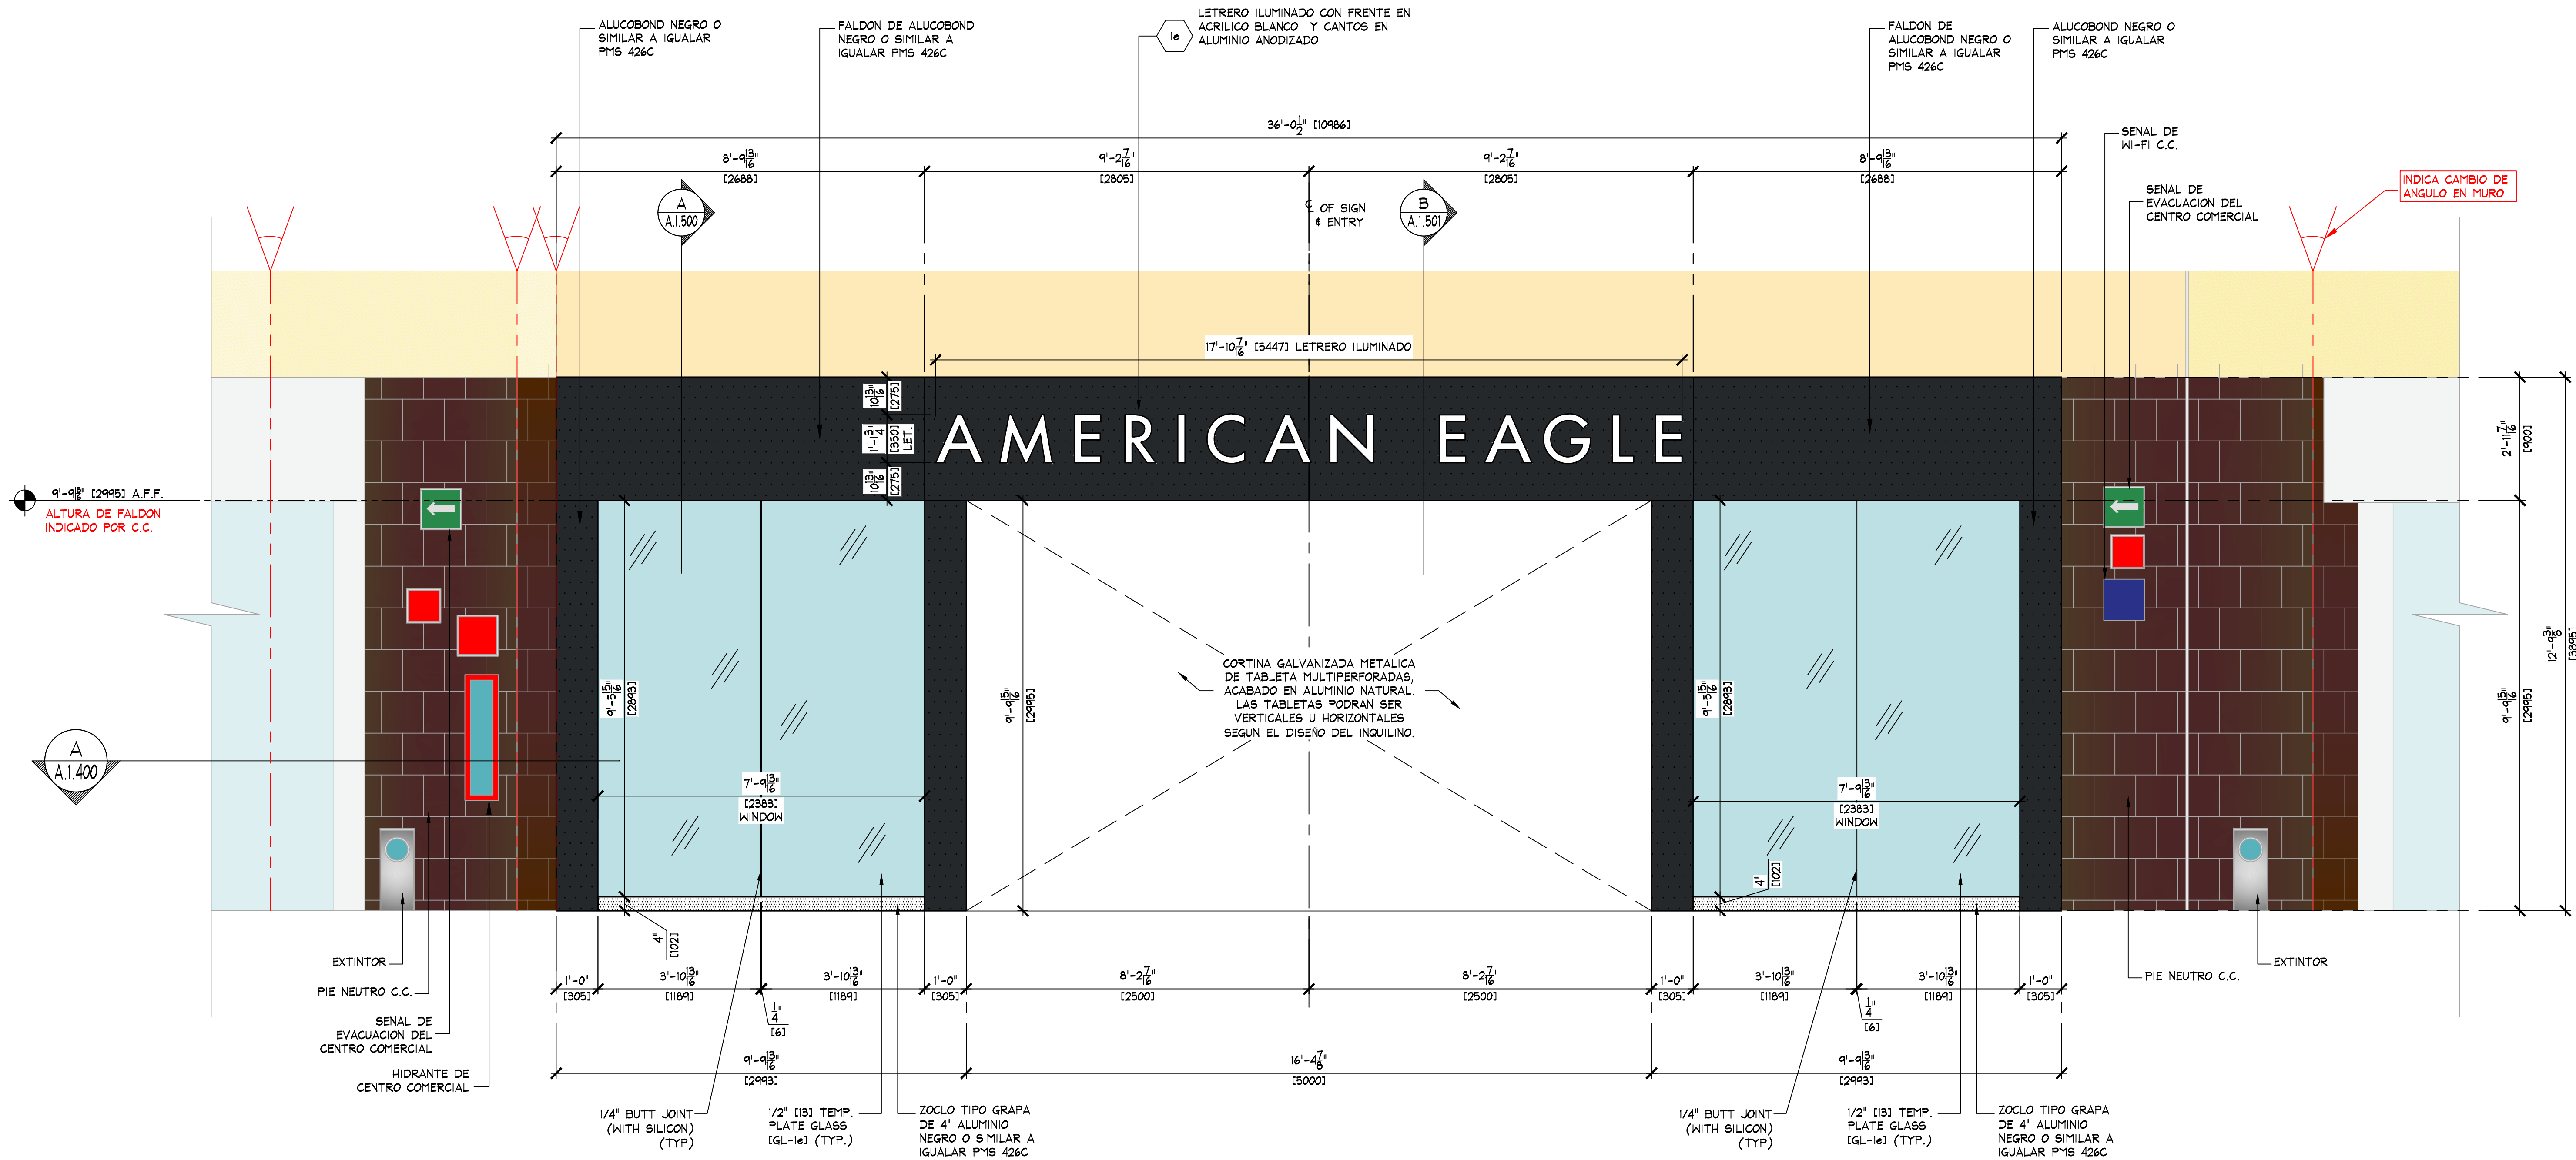

A STOREFRONT EXTERIOR ELEVATION
A.1.300 SCALE: 1/2" = 1'-0" (1:25)

NOTE:
PAINTING CONTRACTOR SHALL
CAULK ALL INSIDE WOOD CORNERS
AND JOINTS BETWEEN TRIM AND
WALL PRIOR TO PAINTING.

KEY NOTES:
SIGN - FURNISHED BY SIGN CONSULTANT,
INSTALLED BY G.C. - SEE SHEET 'A.1.800'
FOR MORE INFORMATION.

AMERICAN EAGLE

THINK ARCHITECTURE S.A. DE C.V.
Descartes 93, 1er piso Col. Anzures
Miguel Hidalgo C.P. 11590 Mexico

AMERICAN EAGLE OUTFITTERS, INC.
77 Main Street
Pittsburgh, PA 15203
(412) 432-3300

AMERICAN EAGLE OUTFITTERS/APERIE

AMERICAN EAGLE OUTFITTERS/APERIE

AMERICAN EAGLE OUTFITTERS/APERIE

AMERICAN EAGLE OUTFITTERS/APERIE

AMERICAN EAGLE OUTFITTERS/APERIE

AMERICAN EAGLE OUTFITTERS/APERIE

AMERICAN EAGLE OUTFITTERS/APERIE


AMERICAN EAGLE OUTFITTERS/APERIE

AMERICAN EAGLE OUTFITTERS/APERIE

1e 3e SIGN - FURNISHED BY SIGN CONSULTANT, INST.
BY G.C., SEE SHEET A.1.800 FOR MORE INFO

1a SIGN - FURNISHED BY SIGN CONSULTANT, INST.
BY G.C., SEE SHEET A.2.800 FOR MORE INFO

NOTE:
DOOR DETAILS SHOWN ARE FOR SCHEMATIC
PURPOSES ONLY. CHECK FLOOR PLAN FOR
ALL SIZES AND SWINGS.

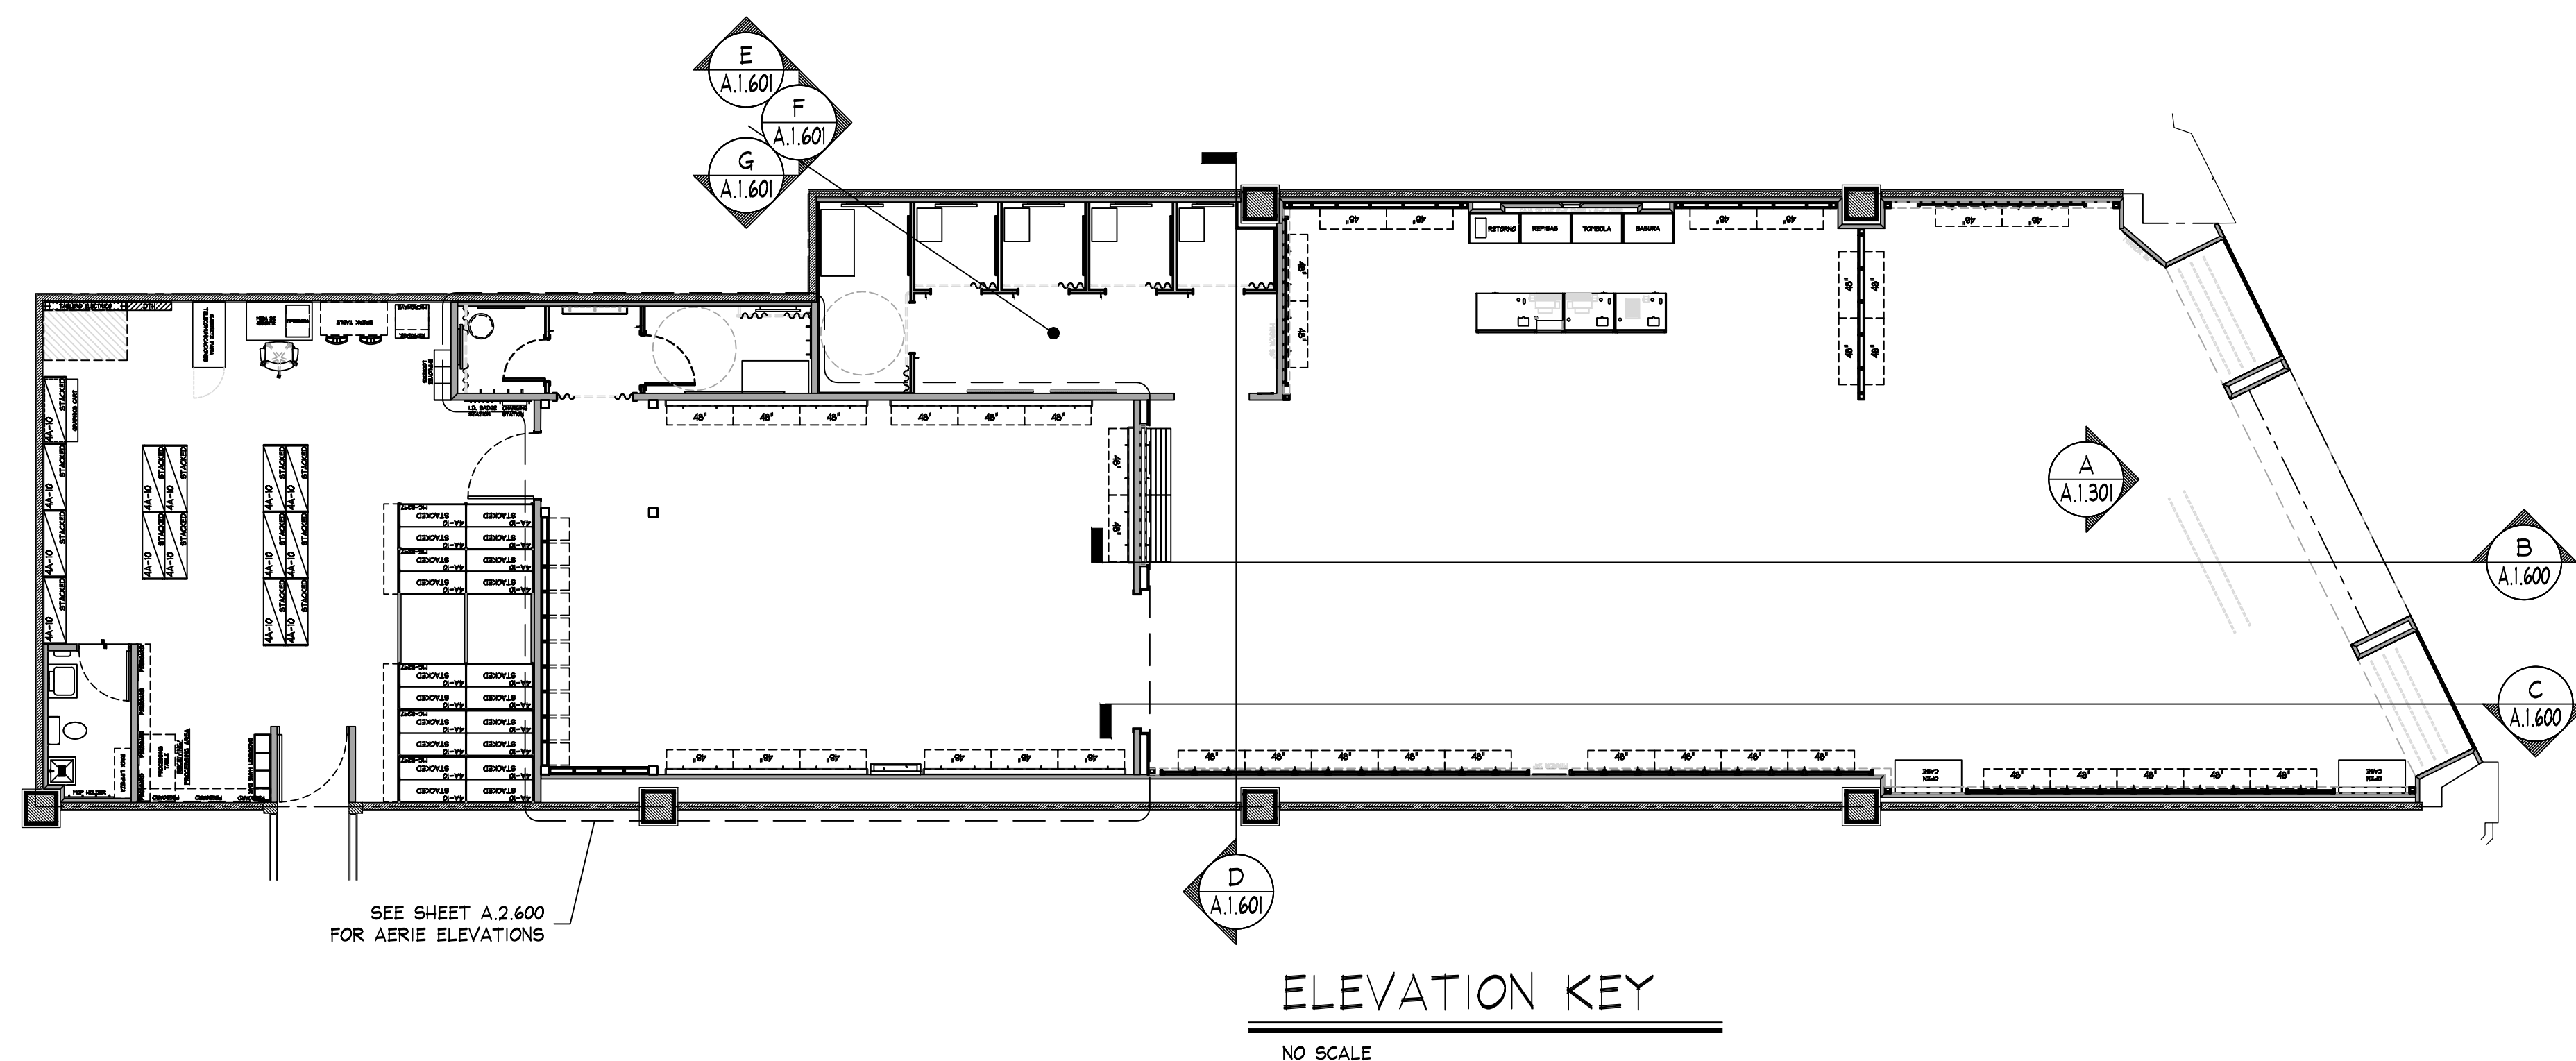

A.1.600

