


AREA ANALYSIS			
AREA	m ²	FT ²	%
AE SALES AREA	246.7	2,656	66%
AE FITTING ROOMS	29.5	318	8%
AERIE SALES AREA	0	0	0%
AERIE FITTING ROOMS	0	0	0%
STOCK ROOM	53	571	14%
TOILET ROOM	4.5	48	1%
EGRESS CORRIDOR	0	0	0%
AE DISPLAY	16.3	175	4%
AERIE DISPLAY	0	0	0%
OTHER	0	0	0%
UNUSED	22.3	240	6%
TOTAL	372.3	4008	100%

IMPORTANTE:
RACKS DE BODEGA SON MOSTRADOS CON FINES ESQUEMATICOS. LA CONFIGURACION ACTUAL PODRIA VARIAR. REVISAR CANTIDAD, ALTURA Y POSICION FINAL CON PROVEEDOR REMINGTON.

NOTE:
PRIOR TO INSTALLATION OF STOCKROOM SHELVING & STOCKROOM ACCESSORY ITEMS, G.C. SHALL VERIFY THAT ALL STOCKROOM COMPONENTS CAN BE INSTALLED AS SHOWN ON THIS DRAWING. IF FIELD CONDITIONS PROHIBIT INSTALLATION AS SHOWN, OR PRESENT OPPORTUNITIES FOR EXPANSION, G.C. SHALL NOT CONTINUE WITH ANY INSTALLATION AND NOTIFY TENANT FIELD REP IMMEDIATELY.

NOTE:
SEE SHEET D.0.300-F.0.300 & F.0.301 FOR DETAILS OF ALL MISC. STOCKROOM FIXTURES FURN. BY TENANT, INST. BY G.C.

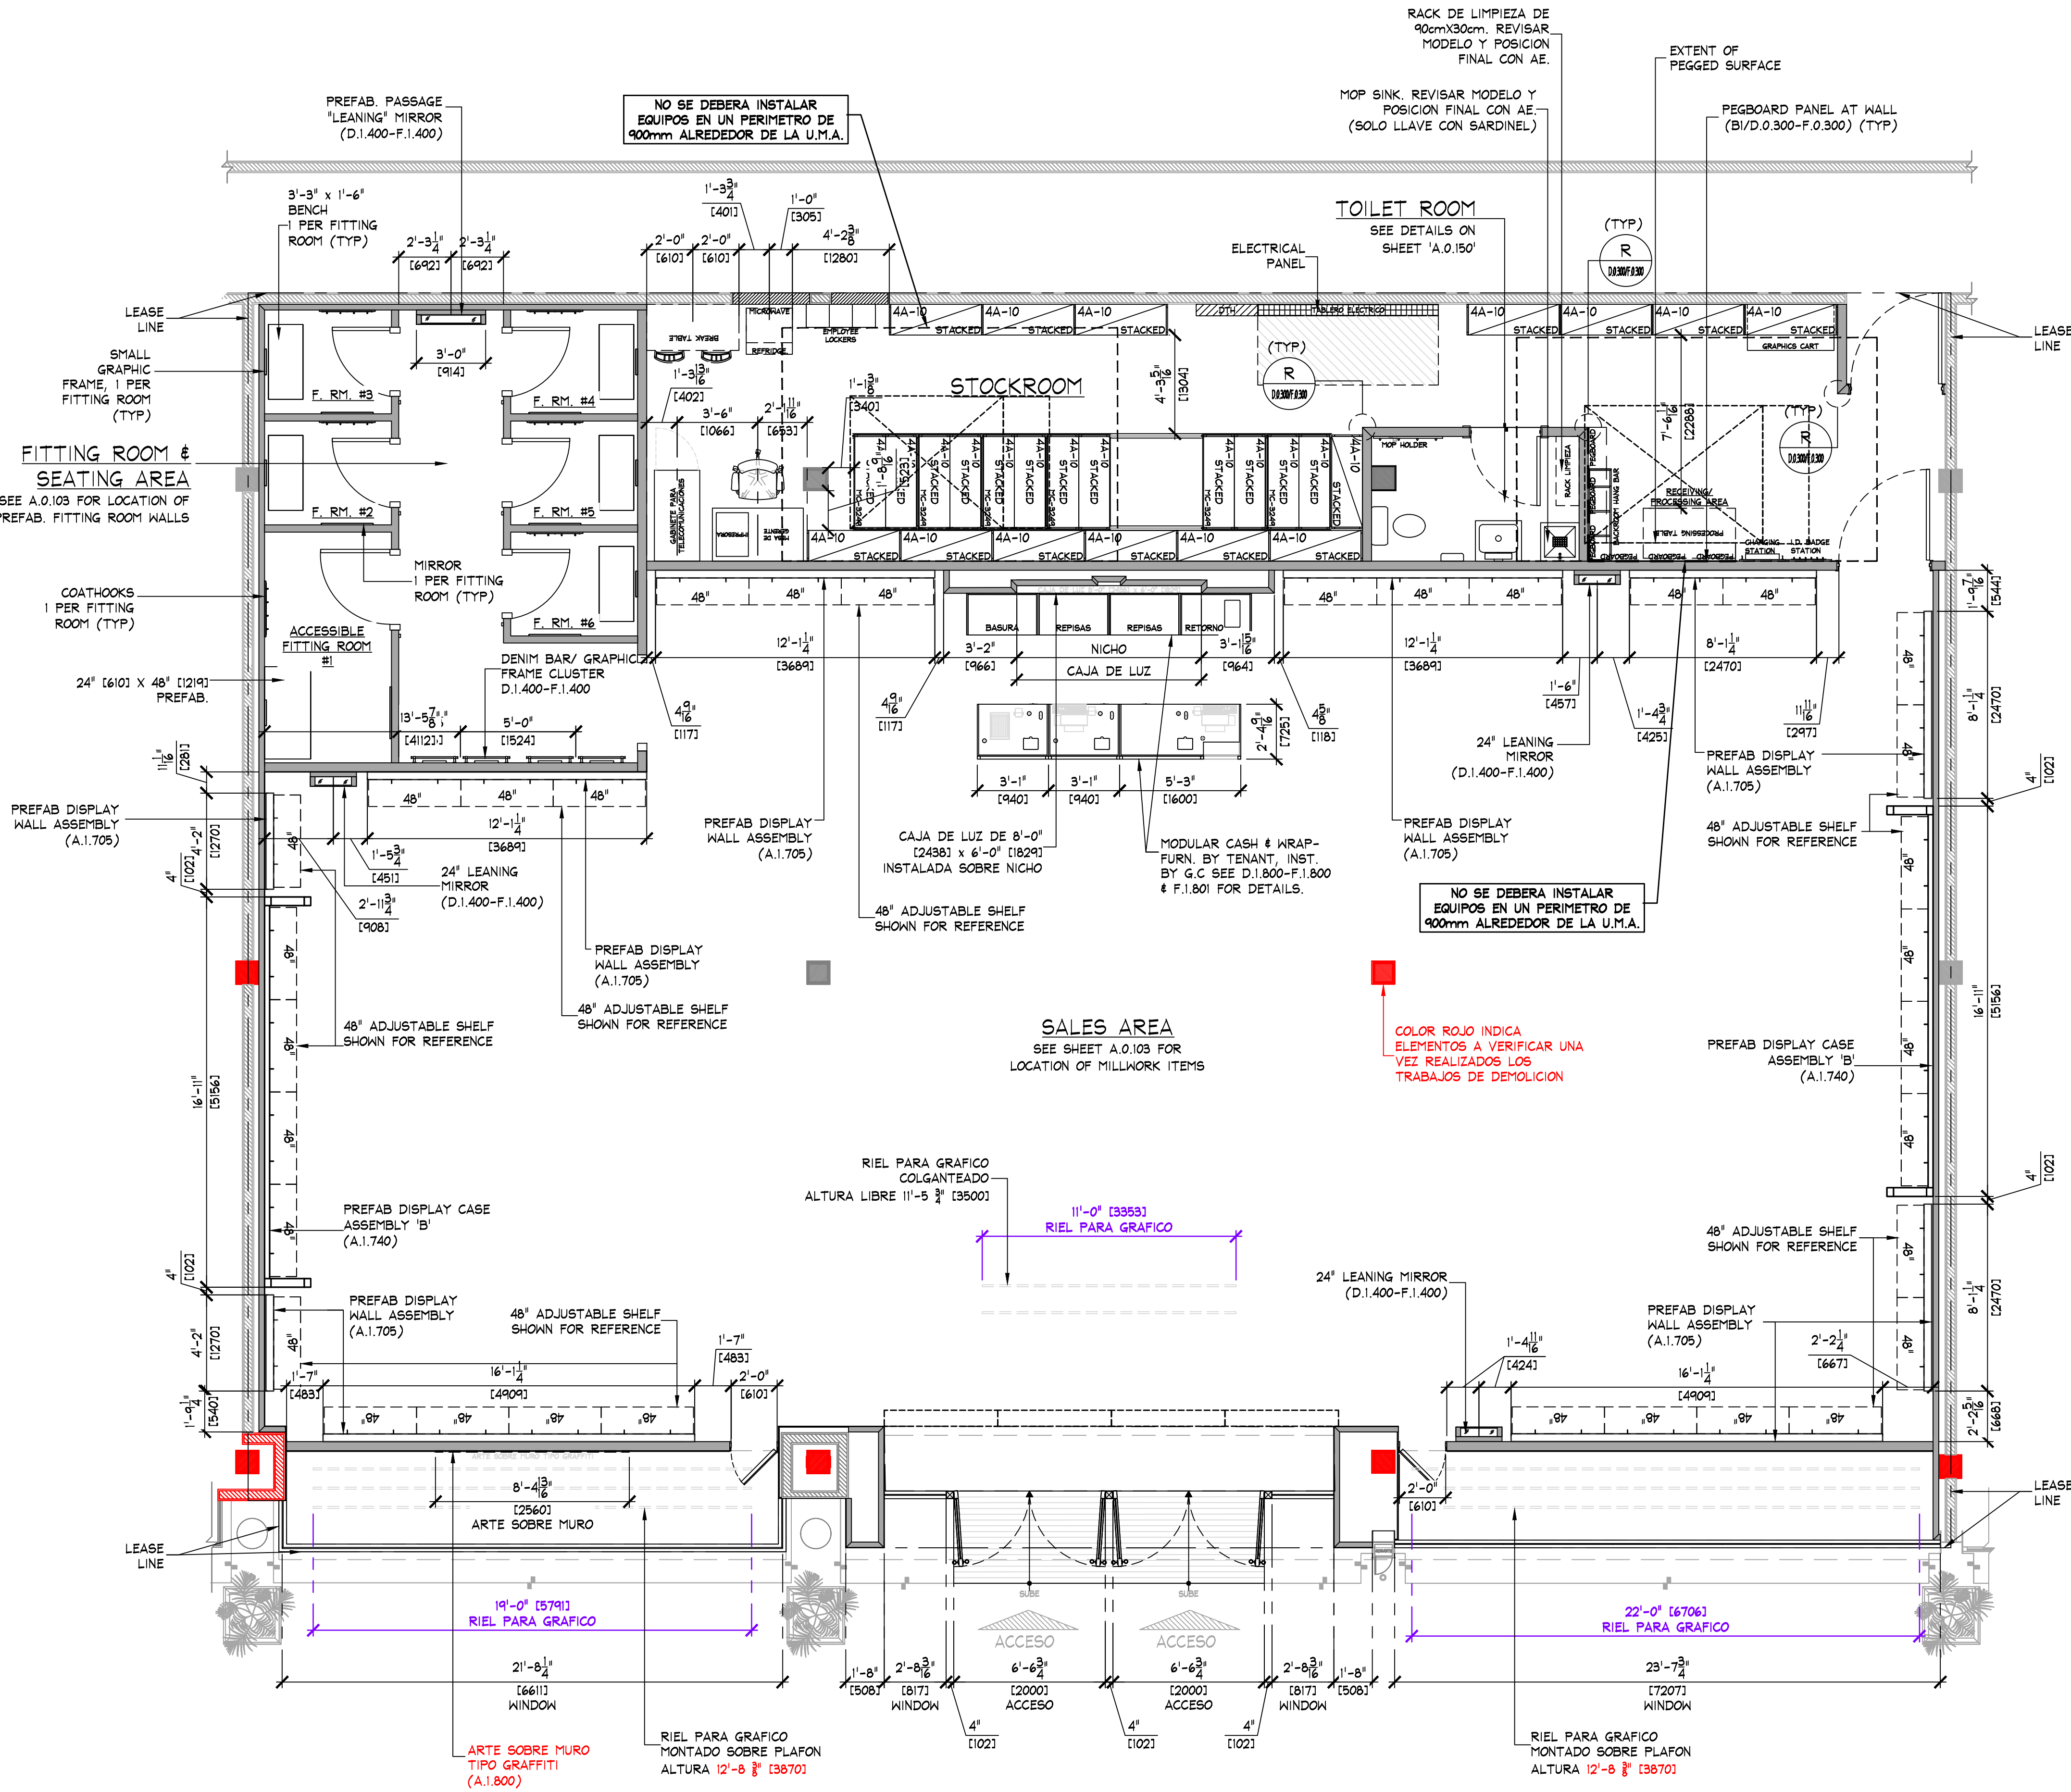

FIXTURE PLAN
SCALE: 1/4" = 1'-0" (1:50)

CONTROL DE CAMBIOS		
BOLETIN	FECHA DE ENTREGA	CAMBIOS GENERALES
1	4 septiembre 2022	Entrega de Proyecto Arquitectonico
2	8 septiembre 2023	Entrega de MEP-HVAC
3	27 septiembre 2023	Cambio de grafica en aparador derecho; cambio de acabados y mobiliario de aerie por AE en area de venta
4	27 septiembre 2023	Cambio de acabado en muro de caja de luz; cambio de especificaciones de letrero AERIE por indicacion AE.
5	3 octubre 2023	Actualizacion de MEP-HVAC con ultima version de Layout
6	9 octubre 2023	Ajuste de sanitario y mobiliario; adiccion de mobiliario en probadores y area de venta; retiro de boton en aparador, por indicaciones AE.
7	12 octubre 2023	Entrega de proyecto ejecutivo IE
8	23 octubre 2023	Actualizacion de proyecto MEP-IE con reubicacion de tablero electrico por recomendacion de IE
9	25 octubre 2023	Ajuste de proyecto con reubicacion de tablero electrico conforme recomendaciones de IE Actualizacion de MEP-HVAC con ultima version de Layout
10	5 diciembre 2023	Cambio de especificacion en acabados de piso conforme a indicacion AE (21 de Noviembre) integracion de mobiliario en area de bodega conforme con informacion AE (27 de Noviembre) Cambio de mobiliario en area de venta conforme indicaciones de AE (29 de Noviembre)
11	14 diciembre 2023	Actualizacion de proyecto HVAC (13 de Diciembre)
12	21 febrero 2024	Actualizacion de proyecto HVAC
13	1 marzo 2024	Actualizacion de proyecto HVAC

NOTAS:
1. PARA VER DETALLE DE CAMBIOS Y PLANOS DONDE SE APLICA, REFERIRSE AL BOLETIN MENCIONADO.
2. LA FECHA INDICADA EN TABLA SE REFIERE A LA ACTUALIZACION EN DRIVE Y ENTREGA DE BOLETIN; PARA REVISAR FECHAS DE REDLINES, REFERIRSE AL ARCHIVO CAD.
3. PARA VER DETALLES DE REDLINES Y SU AREA DE EJECUCION DENTRO DEL PROYECTO EN FORMATO PDF, CONSULTAR LA CARPETA PDF CON NOTAS INTERNAS.

SYMBOL LEGEND

- RECESSED EMERGENCY LIGHT
- SURFACE EMERGENCY LIGHT
- EXIT SIGN
- SHOPPER TRACK
- SECURITY BY OTHERS
ANTENA, VER ALTURA LIBRE A.1.500
ANTENA, ALTURA LIBRE (BODEGA) 2.40m

KEY NOTES:

- STOCKROOM CEILING - NO CEILING, UNLESS REQUIRED BY LANDLORD OR LOCAL BUILDING CODES - (CT-2e). SUSPENSION SYSTEM SHALL BE AS MANUFACTURED BY USG INTERIORS, INC. DOWN CEILING SUSPENSION DXL SERIES, WHITE EXPOSED 2'x4' GRID SYSTEM.
- SIGN - FURNISHED BY SIGN CONSULTANT, INSTALLED BY G.C. SEE SHEET A.1.800 FOR MORE INFORMATION.
- SIGN - FURNISHED BY SIGN CONSULTANT, INSTALLED BY G.C. SEE SHEET A.1.800 FOR MORE INFORMATION.
- REGISTRO EN MURO Y/O PLAFON DE 1'-0" (3053) A.F.F. EN ACABADO A IGUALAR INDICADO EN UBICACION REQUERIDA, POR G.C.
- ACCESS PANELS SHALL BE AS MANUFACTURED BY KIND-LOCK, STEALTH PANEL #TR-AP024 (TYP). G.C. SHALL FURNISH AND INSTALL ACCESS PANELS FOR ALL NEW AND EXISTING ABOVE CEILING COMPONENTS REQUIRING MAINTENANCE ACCESS (e.g. HVAC UNIT CONTROLS, SHUT OFF VALVES, DAMPER CONTROLS, J-BOXES, ETC. - LANDLORD AND/OR TENANT PROVIDED G.C. TO VERIFY IN THE FIELD). COORDINATE ALL LOCATIONS WITH TENANT FIELD REPRESENTATIVE.

NOTE:

- ALL SUPPORT TRACK AND RELATED COMPONENTS, REQUIRED TO SUPPORT TRACK LIGHTING FIXTURES ONLY, ARE TO BE FURNISHED BY TENANT & INSTALLED BY G.C. - G.C. SHALL ENSURE THAT ALL SUPPORT TRACK IS INSTALLED WITH FIRST CLASS WORKMANSHIP, LEVEL, STRAIGHT, & ALIGNED
- ALL OTHER EQUIPMENT/COMPONENT SUPPORTS (UNISTRUT, CLAMPS, NUTS, BOLTS, WASHERS, ETC.) FURN. & INST. BY G.C.

IMPORTANT:

ORANGE COLOR INDICATES STRUCTURAL ELEMENTS.

NOTE:

ALL COMPONENTS REQUIRED TO SUPPORT AND INSTALL THE SUSPENDED CEILING SYSTEM (WHETHER DRYWALL AND/OR ACOUSTIC TILES), ARE TO BE FURNISHED AND INSTALLED BY G.C. - G.C. SHALL CONSULT WITH MALL/BUILDING DEPARTMENT TO DETERMINE REQUIRED METHODS FOR SUPPORTING CEILING FROM MALL STRUCTURE, PRIOR TO SUBMITTING BID.

NOTE:

- NO WIRING SHALL EXTEND FROM SUPPORT TRACK TO ANY OTHER SUPPORT TRACK, WALL, OR PERIMETER CONSTRUCTION. ALL WIRING RUNS SHALL BE STRAIGHT HORIZONTAL OR VERTICAL. STRAP AND SECURE AS REQUIRED TO MAINTAIN ORGANIZED LOOK.
- ALL WIRING AT PERIMETER WALLS SHALL BE STRAPPED NEATLY HORIZONTAL OR VERTICAL AS REQUIRED.
- ALL VALANCE OR PERIMETER WIRING SHALL BE STRAPPED TIGHTLY TO THE TOP OF VALANCE CASE TO ELIMINATE VIEW FROM SALES FLOOR.
- ALL ELECTRICAL BOXES SHOULD BE HELD TIGHT TO WALLS.

NOTE:

ALL EMERGENCY LIGHTING SHALL BE WIRED "HOT" UN-SWITCHED.

NOTE:

SEE SHEET 'A.0.200' FOR FIXTURE LOCATING DIMENSIONS.

NOTE:

SECURE ALL LIGHTING TRACK TO CEILING WITH TOGGLE BOLTS WHERE OCCURS.

NOTE:

SEE SHEET A.0.200 FOR ALL CEILING HEIGHTS.

NOTE:

SEE SHEET E.0.400 AND/OR E.0.401 FOR ELECTRICAL INSTALLATION DETAILS.

NOTE:

ALL HVAC INSTALLATION SHALL BE GRAY COLOR TO MATCH (P-5e); ALL DIFFUSERS SHALL BE WHITE COLOR.

NOTE:

- G.C. TO PAINT EVERYTHING ABOVE 11'-0" (P-5e)
- DO NOT PAINT EQUIPMENT INFORMATION TAGS!!

NOTE:

REFER TO SHEET E.0.500 FOR ALL CEILING MOUNTED LOW VOLTAGE DEVICES. REFER TO SHEET E.0.501 FOR INSTALLATION OF LOW VOLTAGE DEVICES.

NOTE:

SEE SHEET E.0.101 FOR LIGHTING FIXTURE AND TRACK SCHEDULES.

NOTE:


PRIOR TO START ANY INSTALLATION WORK, G.C. SHALL VERIFY FINAL LOCATION SYSTEM PLANS AS REQUIRED FOR THIS PROJECT (CCTV, SENSORIATIC, ETC.)

NOTA:


SE DEBERA REVISAR LA ALTURA TOTAL EXISTENTE EN LOCAL.

BT

Salida electrica carga normal para botonera visual o audible.
ALTURA LIBRE H=2.74m
SIEMPRE VERIFICAR CON AE

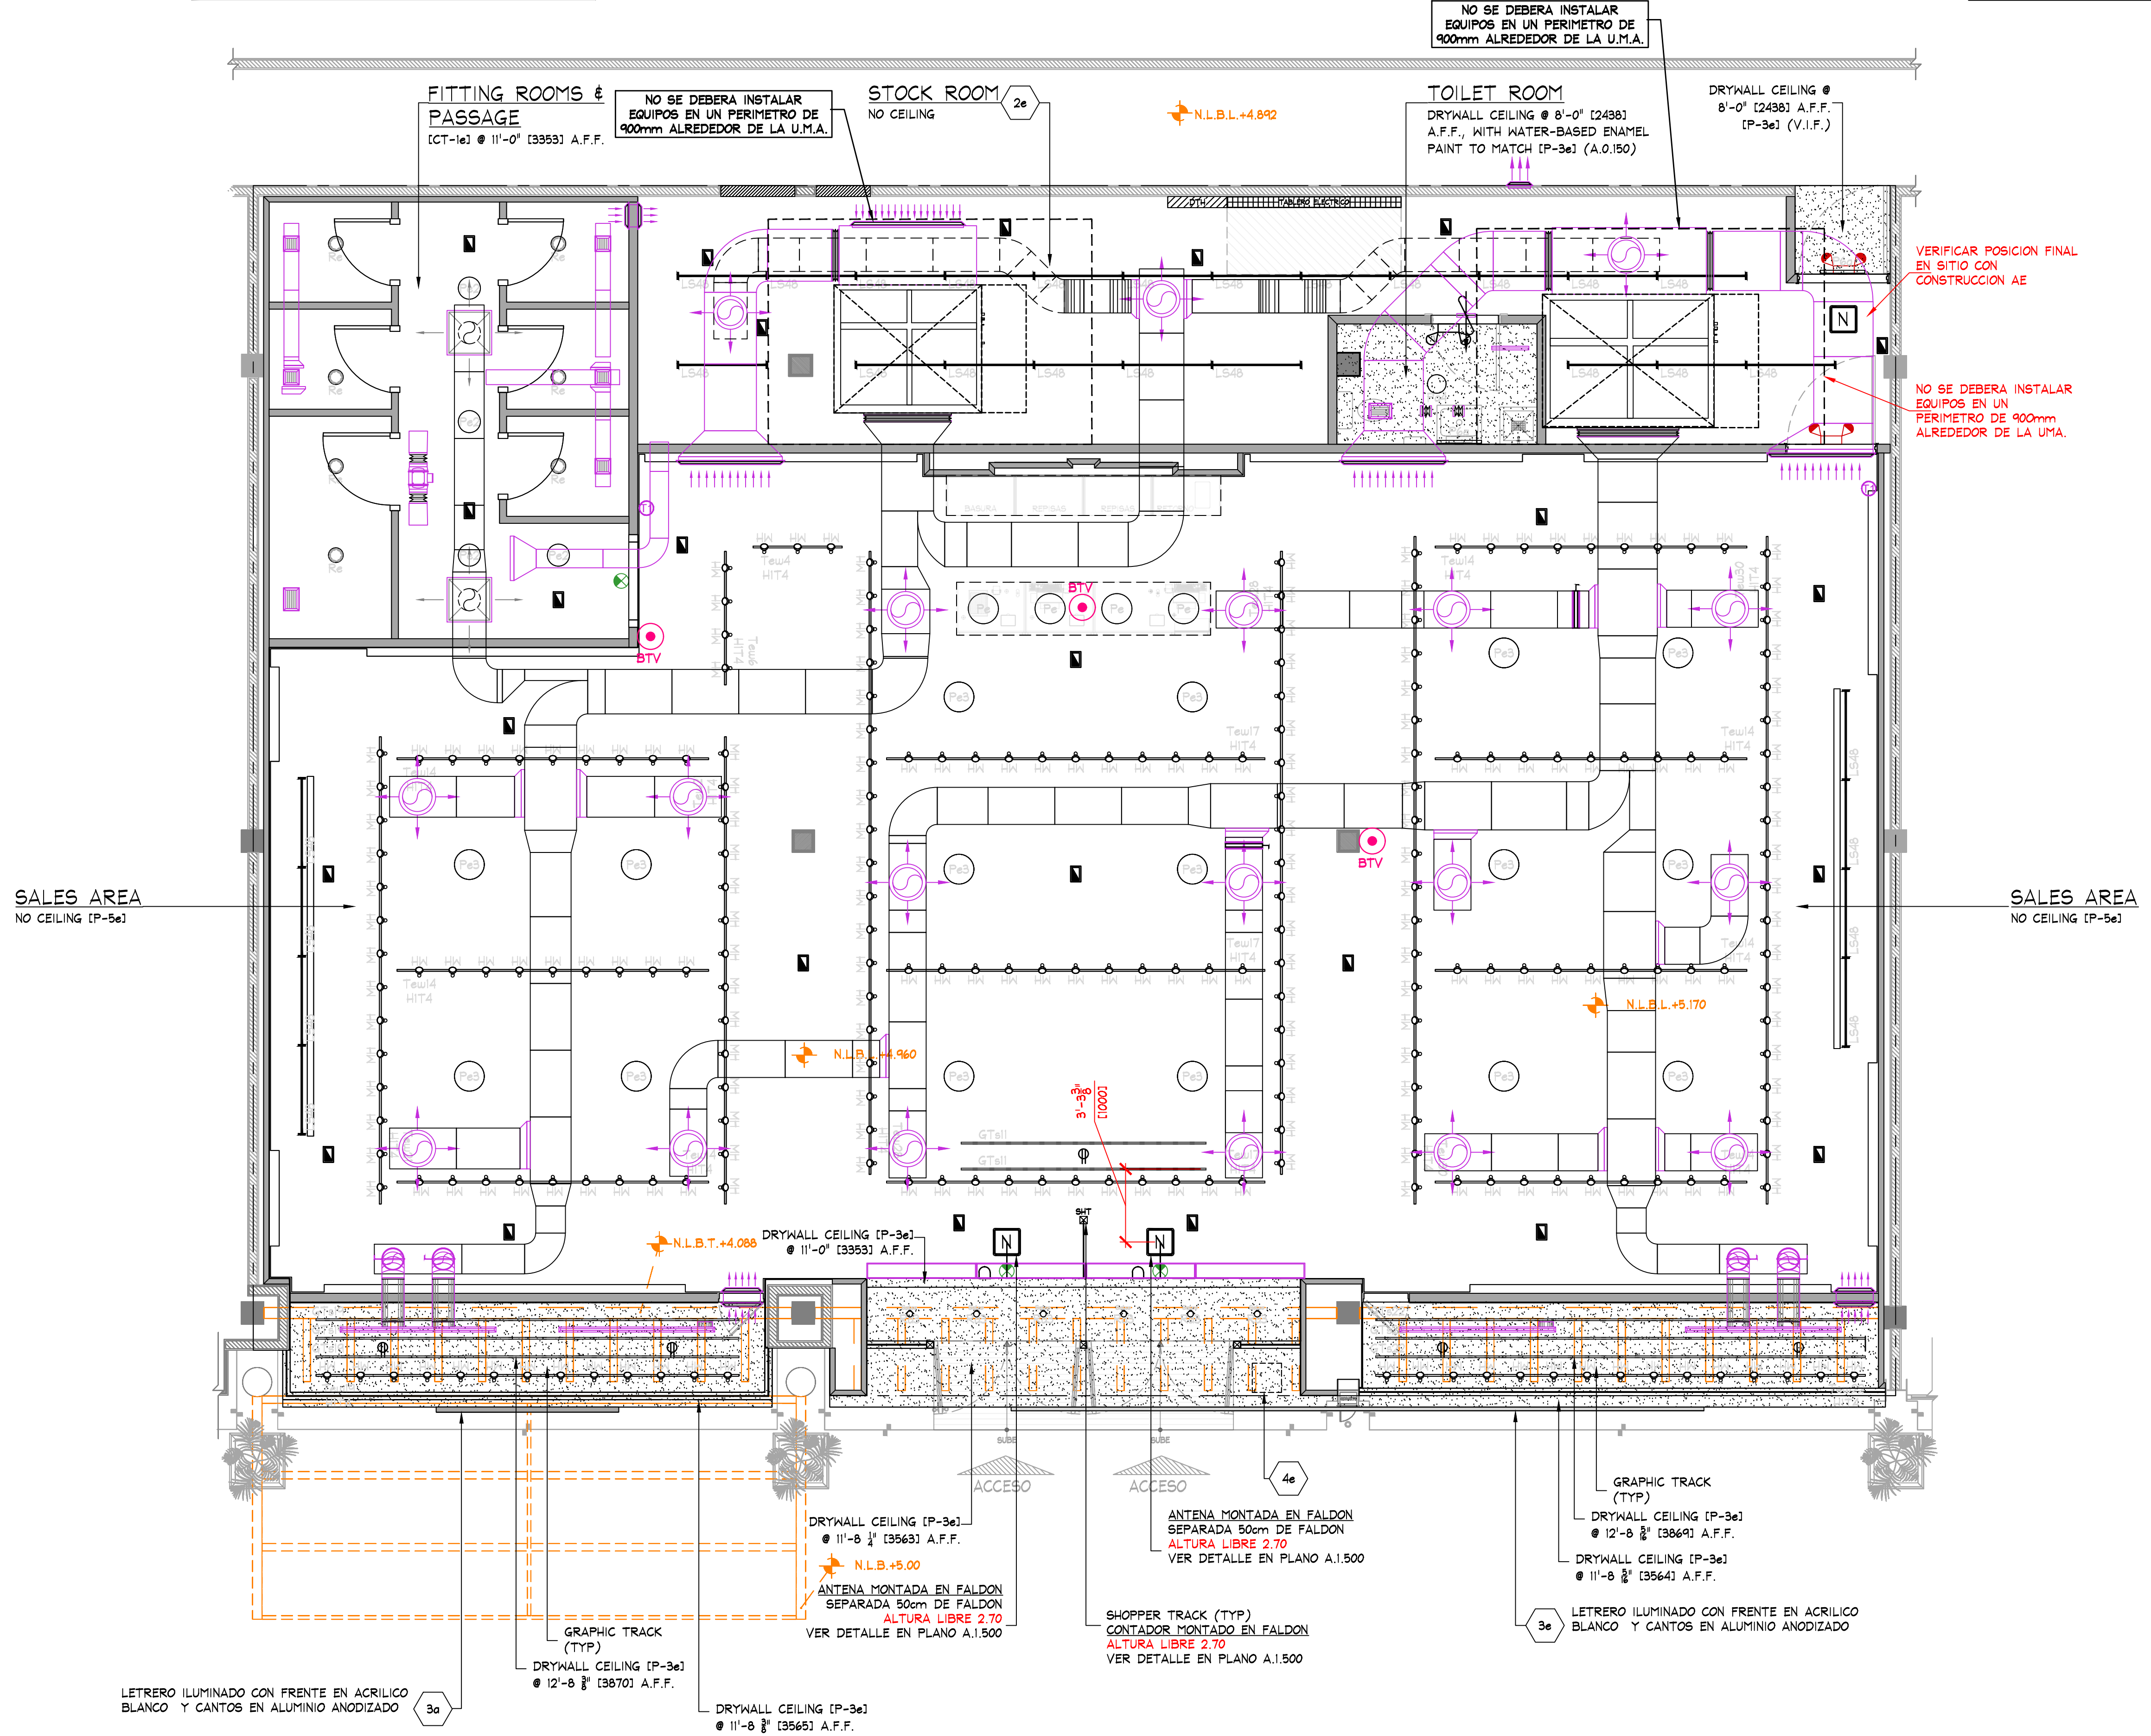

DEVICE COORDINATION REFLECTED CEILING PLAN
SCALE: 1/4" = 1'-0" (1:500)

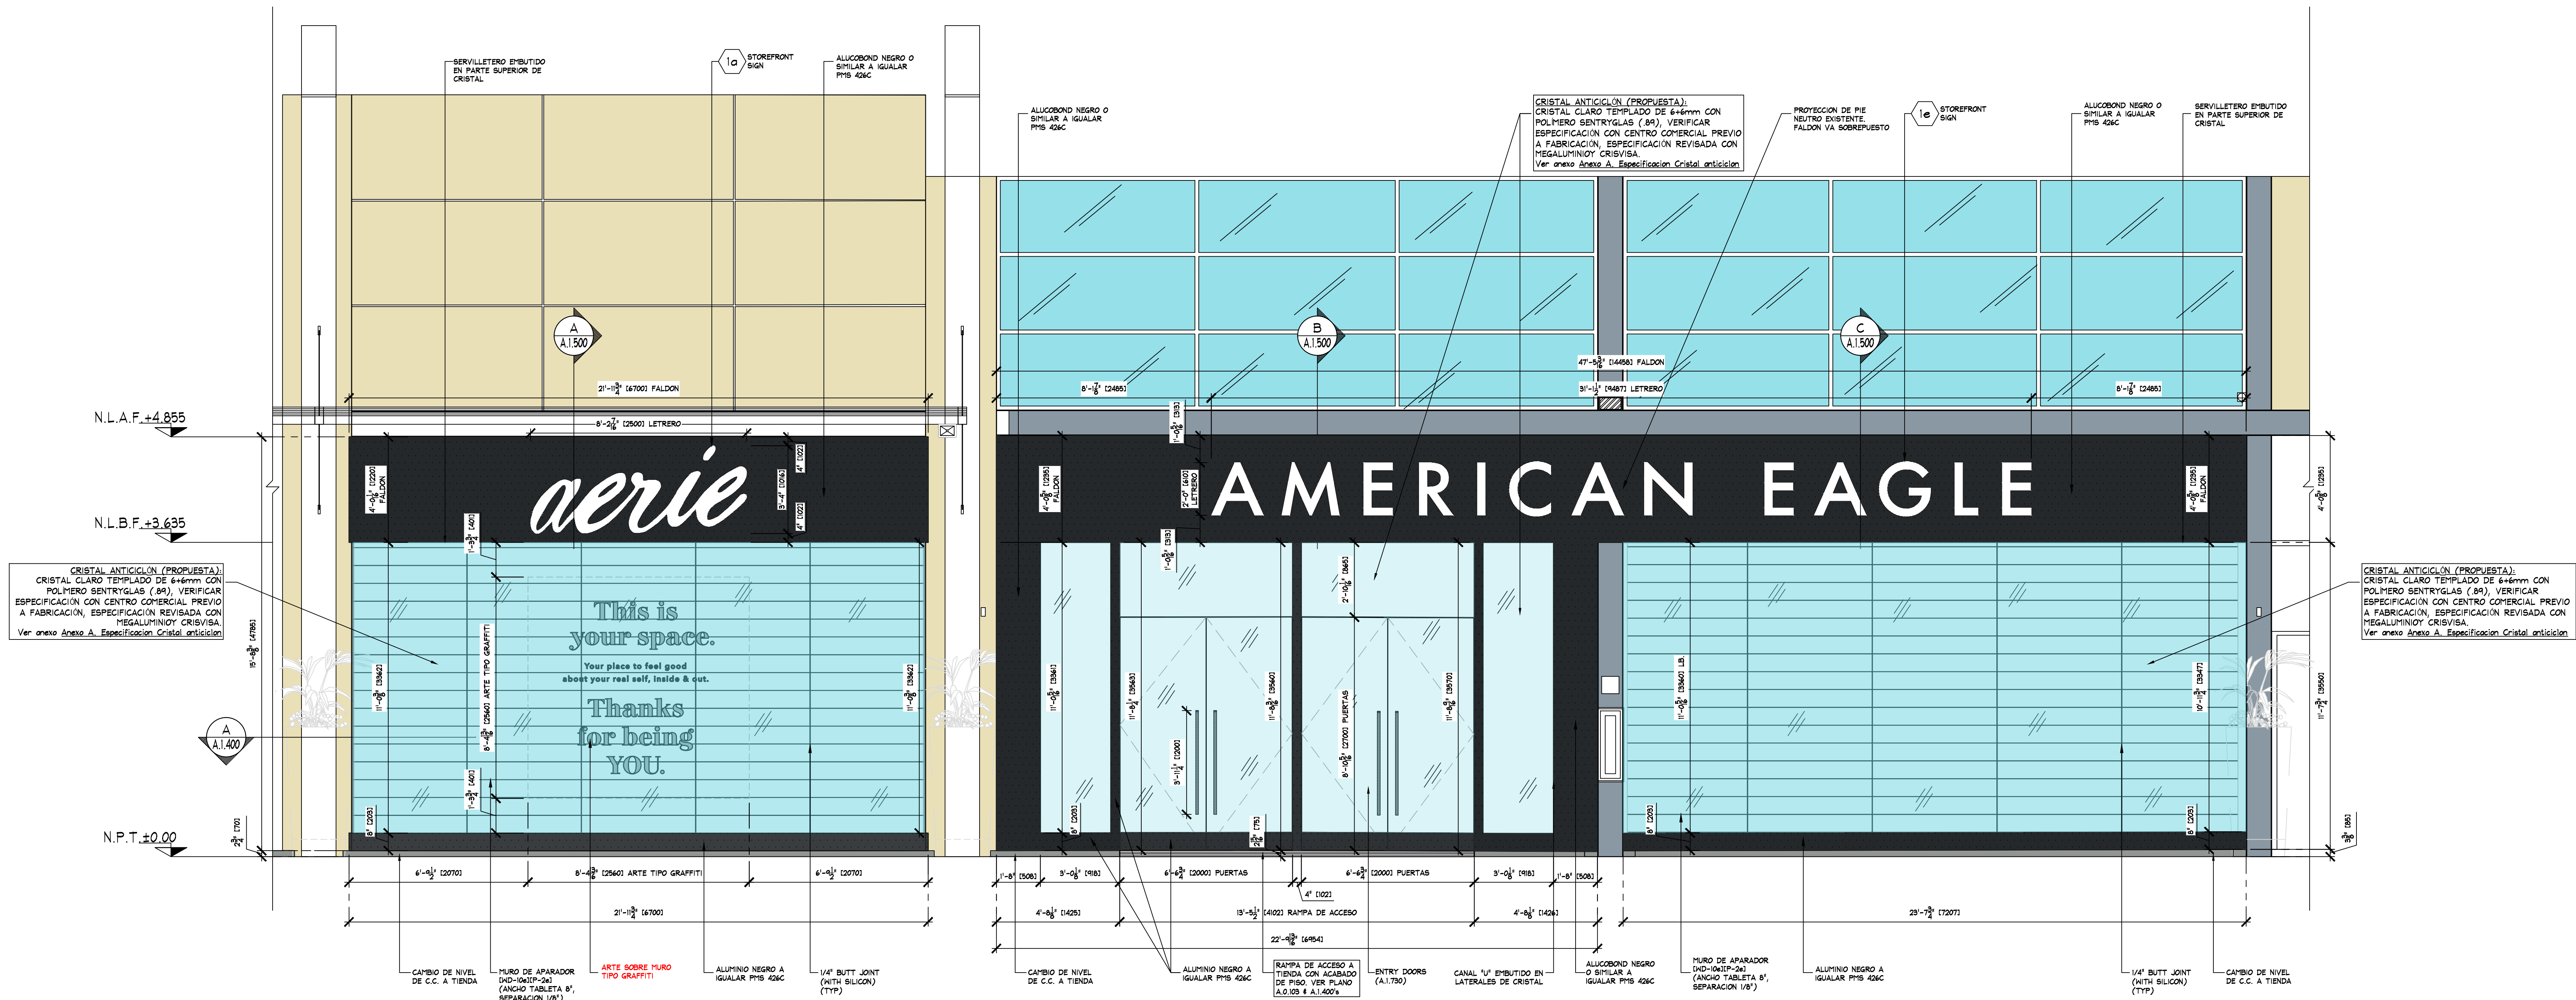


STOREFRONT ELEVATION
SCALE: 3/8" = 1'-0" (1:30)

NOTE:
EXIT DOORS SHALL BE OPENABLE
FROM INSIDE WITHOUT USE OF KEY
OR SPECIAL KNOWLEDGE OR EFFORT.

NOTE:
PAINTING CONTRACTOR SHALL
CAULK ALL INSIDE WOOD CORNERS
AND JOINTS BETWEEN TRIM AND
WALL PRIOR TO PAINTING.

NOTE:
ALL PREFABRICATED COMPONENTS
(PILASTERS, COLUMNS, VALANCES,
CEILING BEAMS, NAILERS, ETC.)
FURN. BY MILLWORK SUPPLIER,
INSTALLED BY G.C.

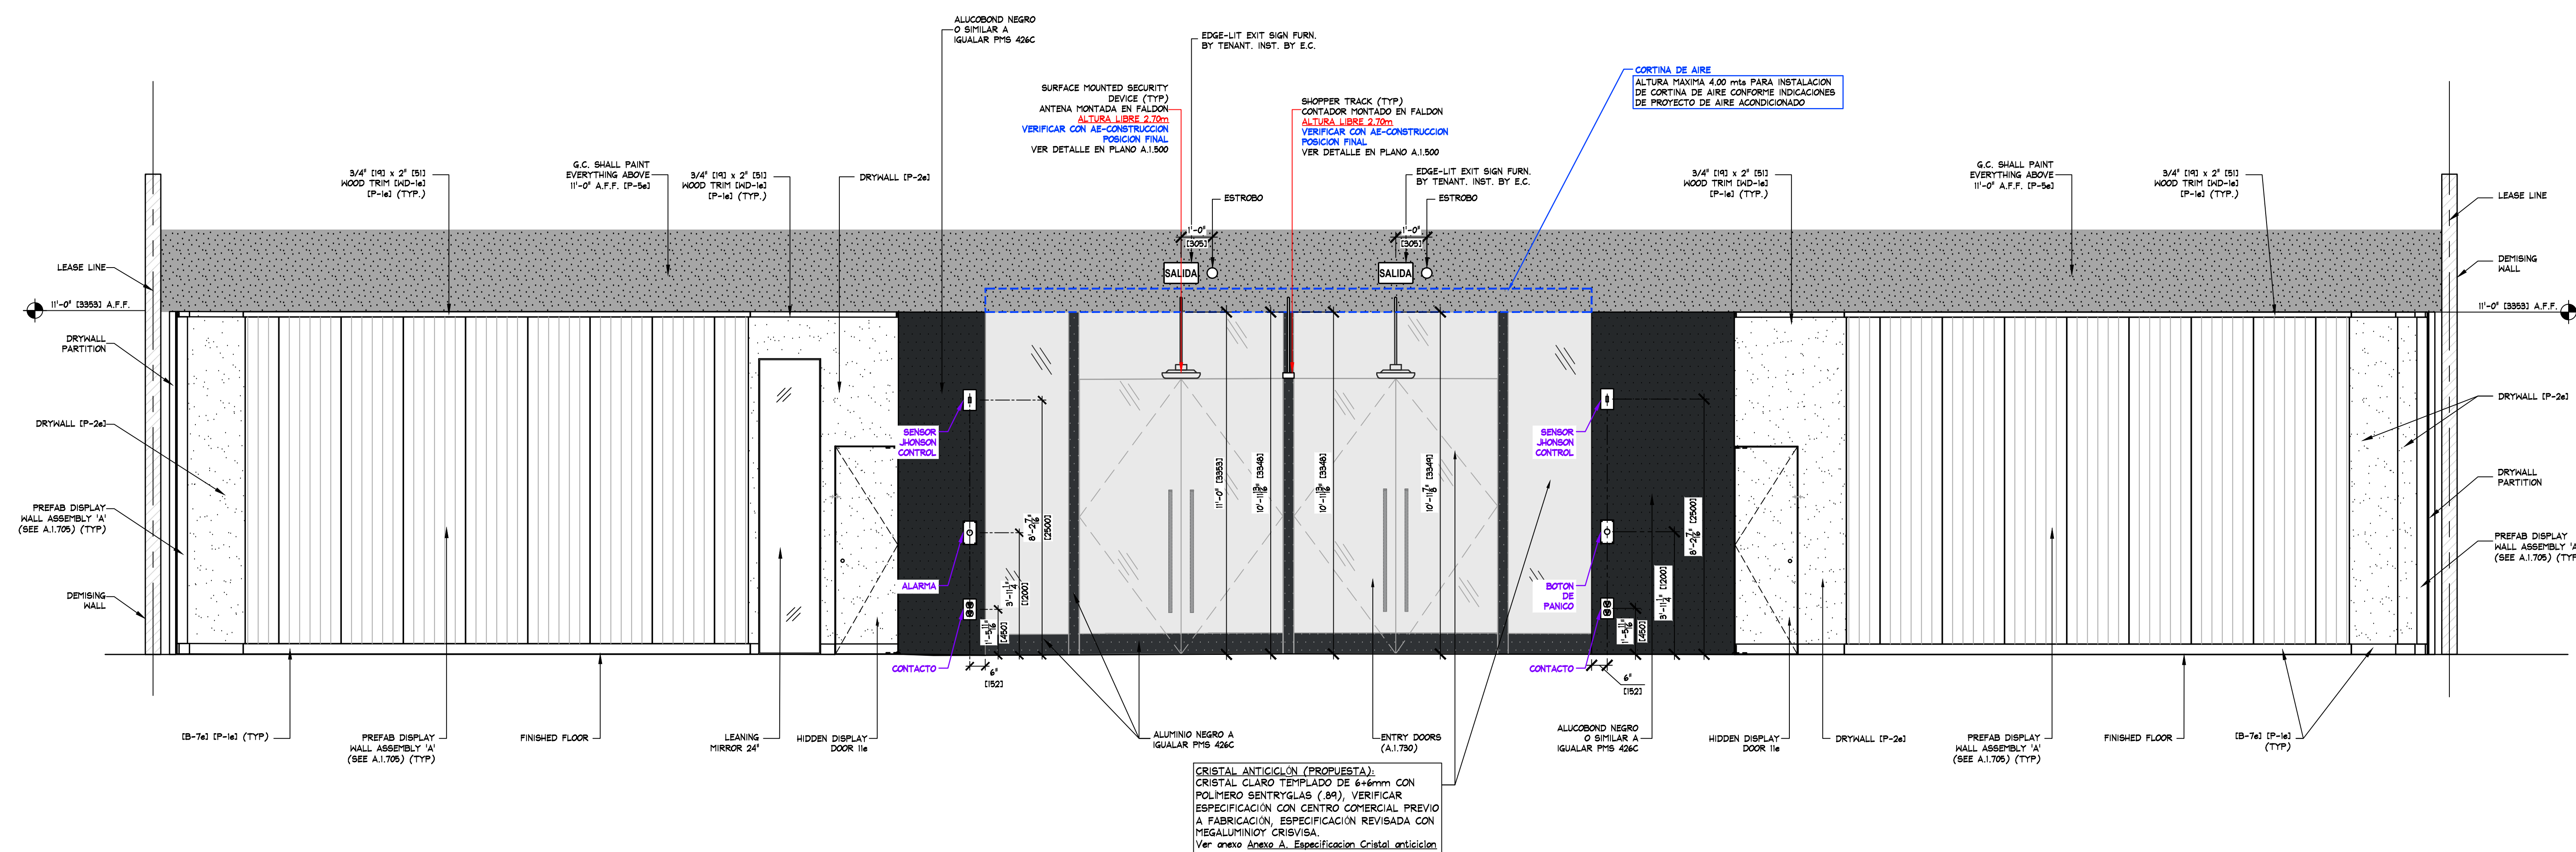

INT. STOREFRONT ELEVATION

STOREFRONT ELEVATIONS

AMERICAN EAGLE OUTFITTERS
Los Plazas Outlet Cancun
Cancun, Quintana Roo Space # L22/L24

Store No.

9275

Drawn by:


Drawing No.


A.1.301

THINK ARCHITECTURE S.A. DE C.V.
Descartes 93, 1er piso Col. Anzures
Miguel Hidalgo C.P. 11590 Mexico

THINK
ARCHITECTURE

AMERICAN EAGLE OUTFITTERS, INC.
777 Hot Metal Street
Pittsburgh, PA 15203
(412)-432-3300

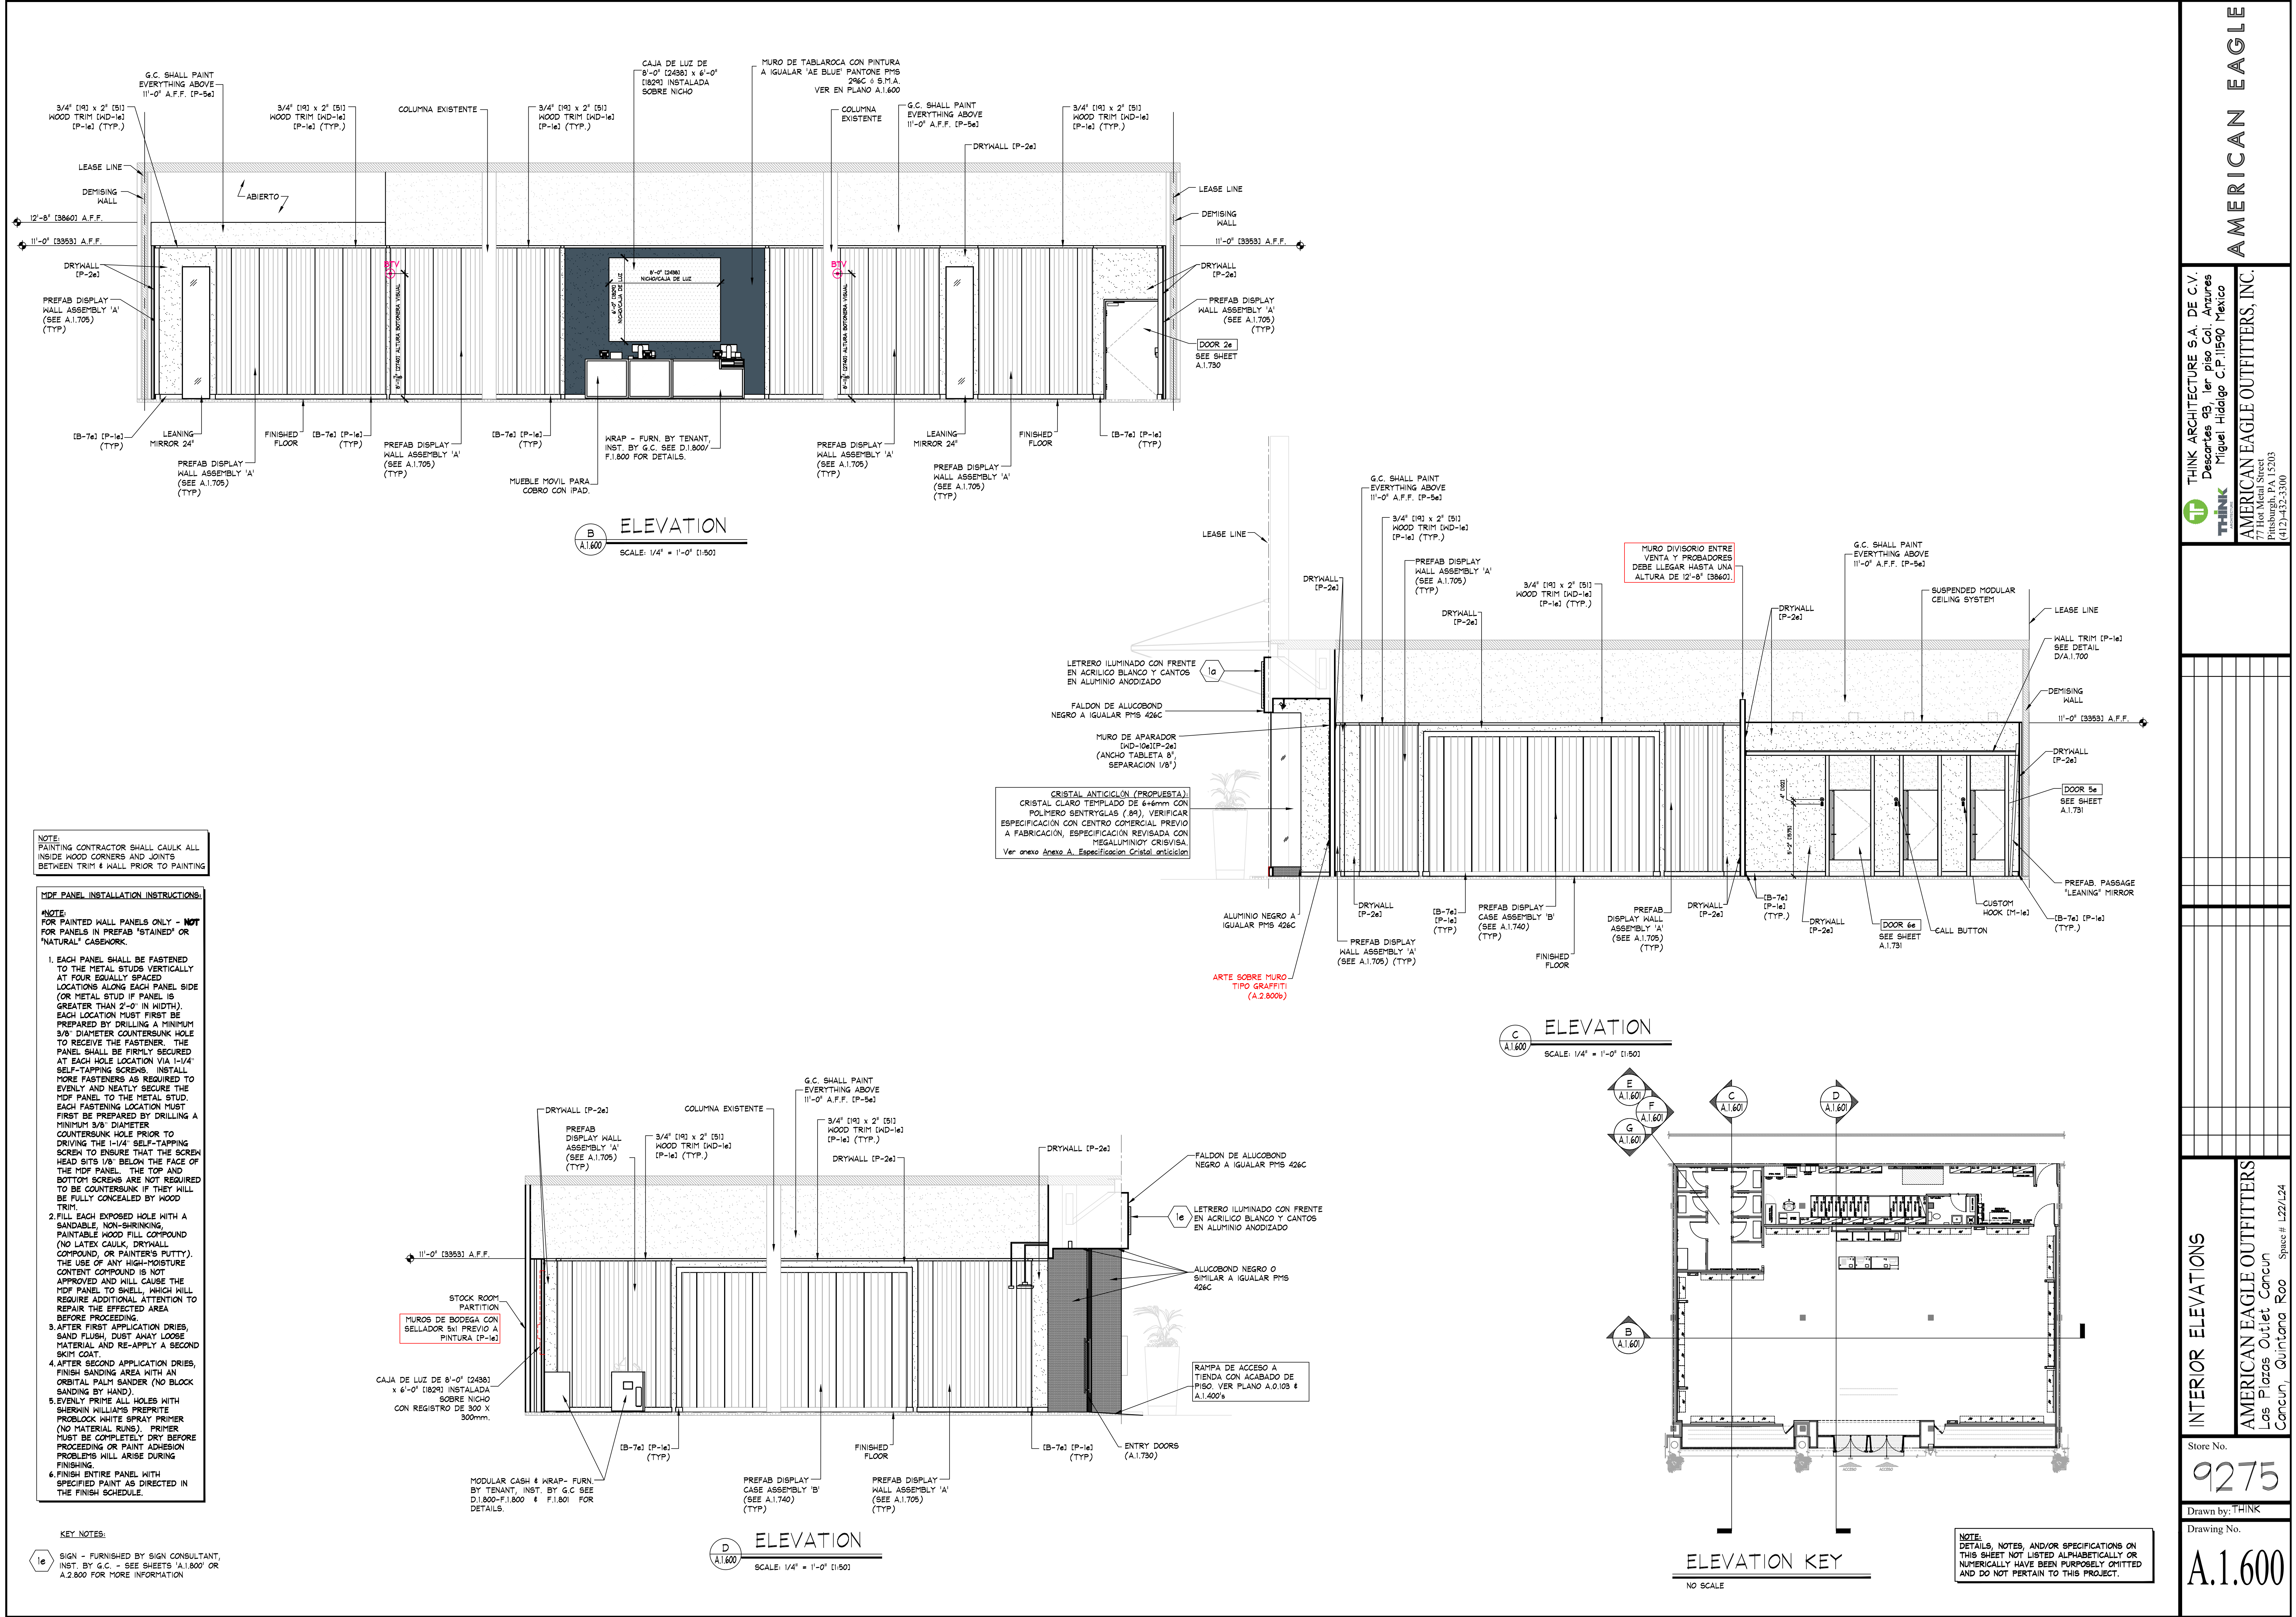


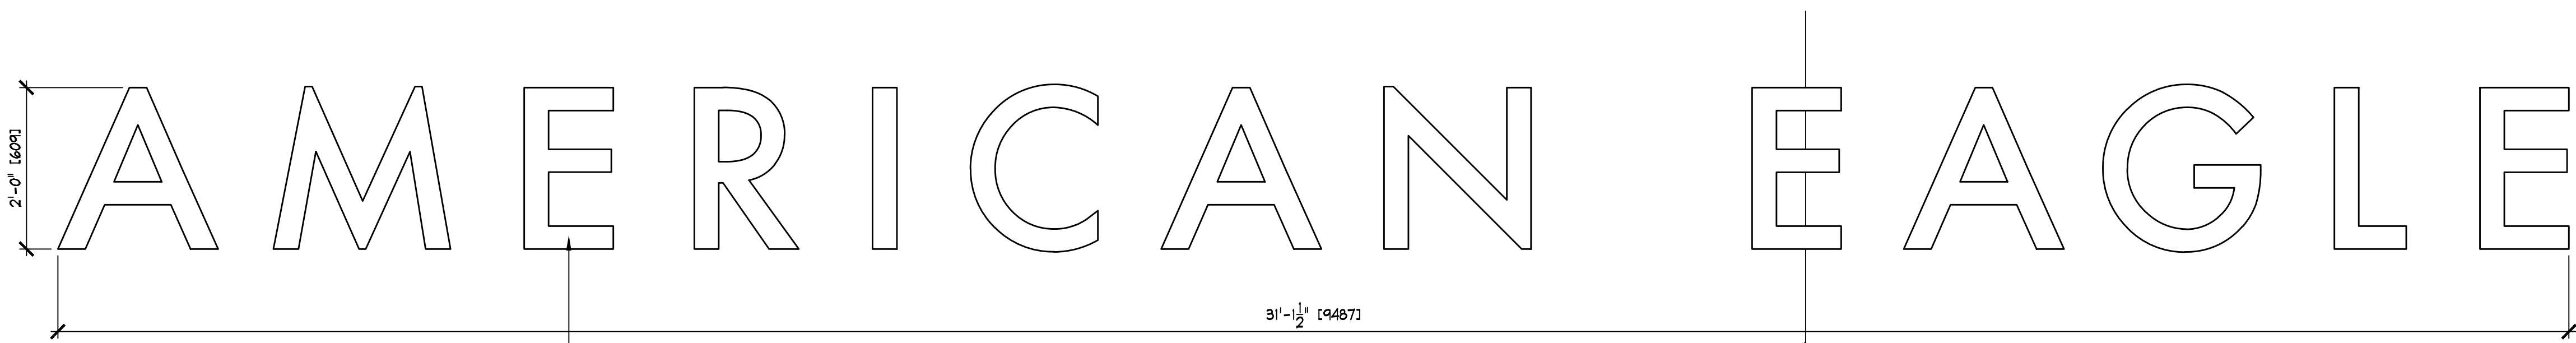

LETRERO ILUMINADO CON FRENTE
EN ACRILICO BLANCO Y CANTOS
EN ALUMINIO ANODIZADO
TEMPERATURA DE LETRERO 4000K


A STOREFRONT SIGN DETAIL
A.1.800 SCALE: 3/4" = 1'-0" (1:16)

B
A.1.800

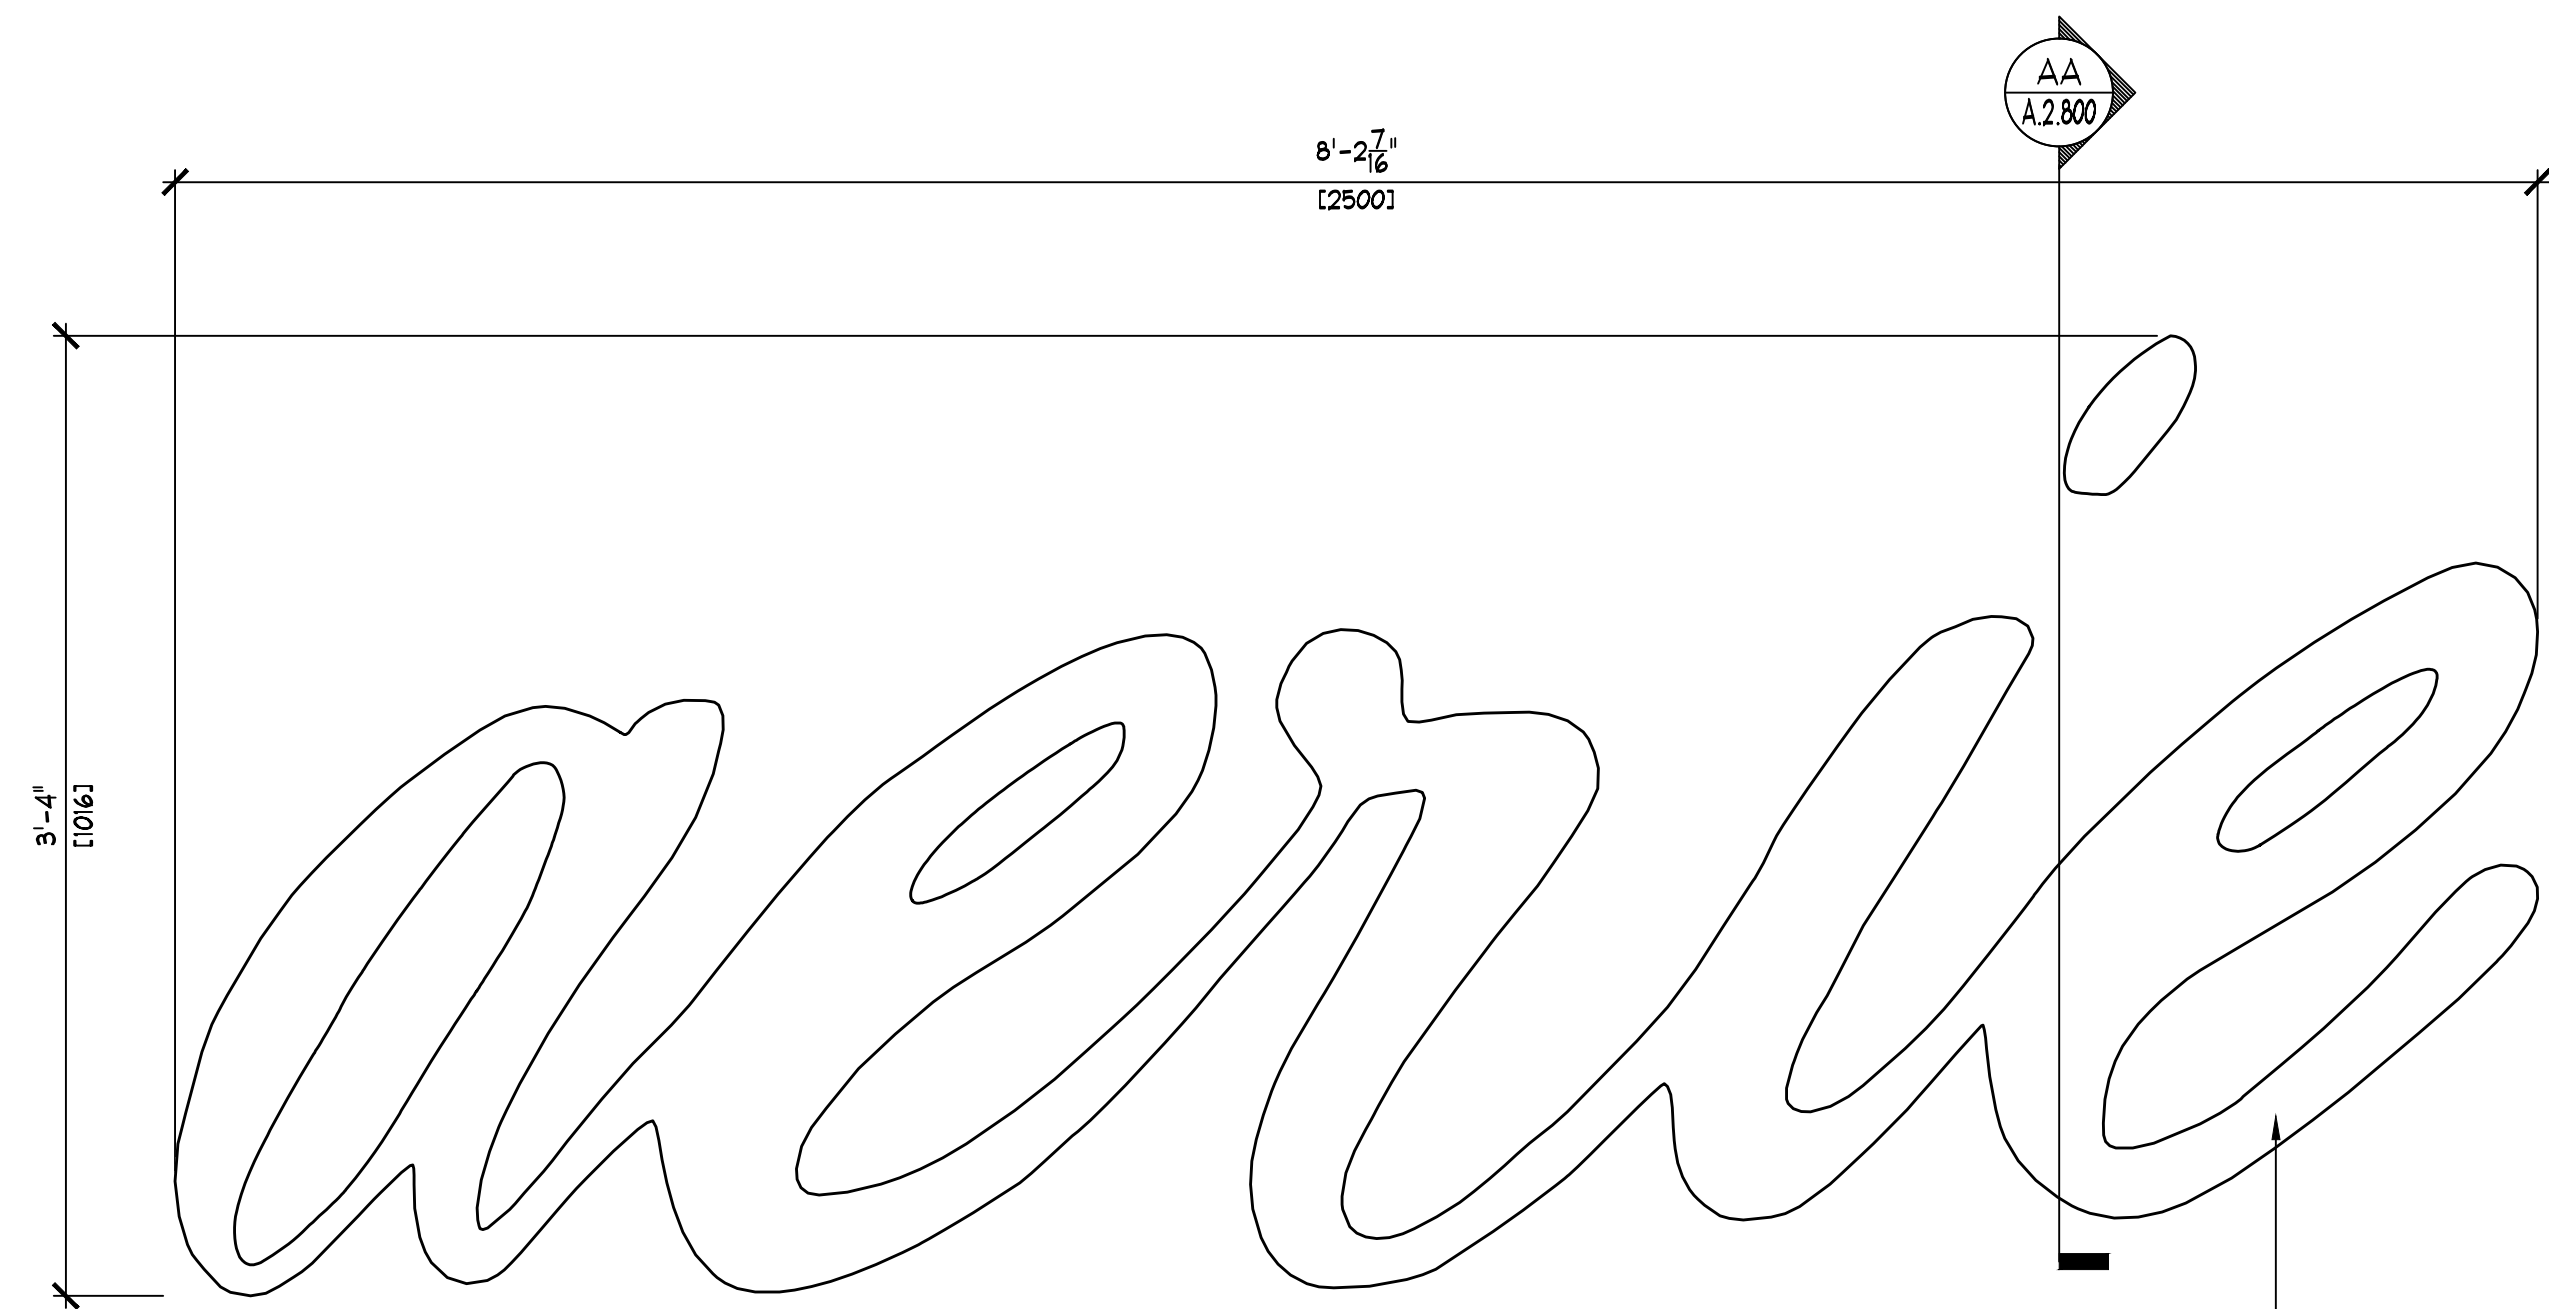


A STOREFRONT SIGN DETAIL
A.1.800 SCALE: 1 1/2" = 1'-0" (1:8)

LETRERO ILUMINADO CON FRENTE EN ACRILICO
BLANCO Y CANTOS EN ALUMINIO ANODIZADO
TEMPERATURA DE LETRERO 4000K

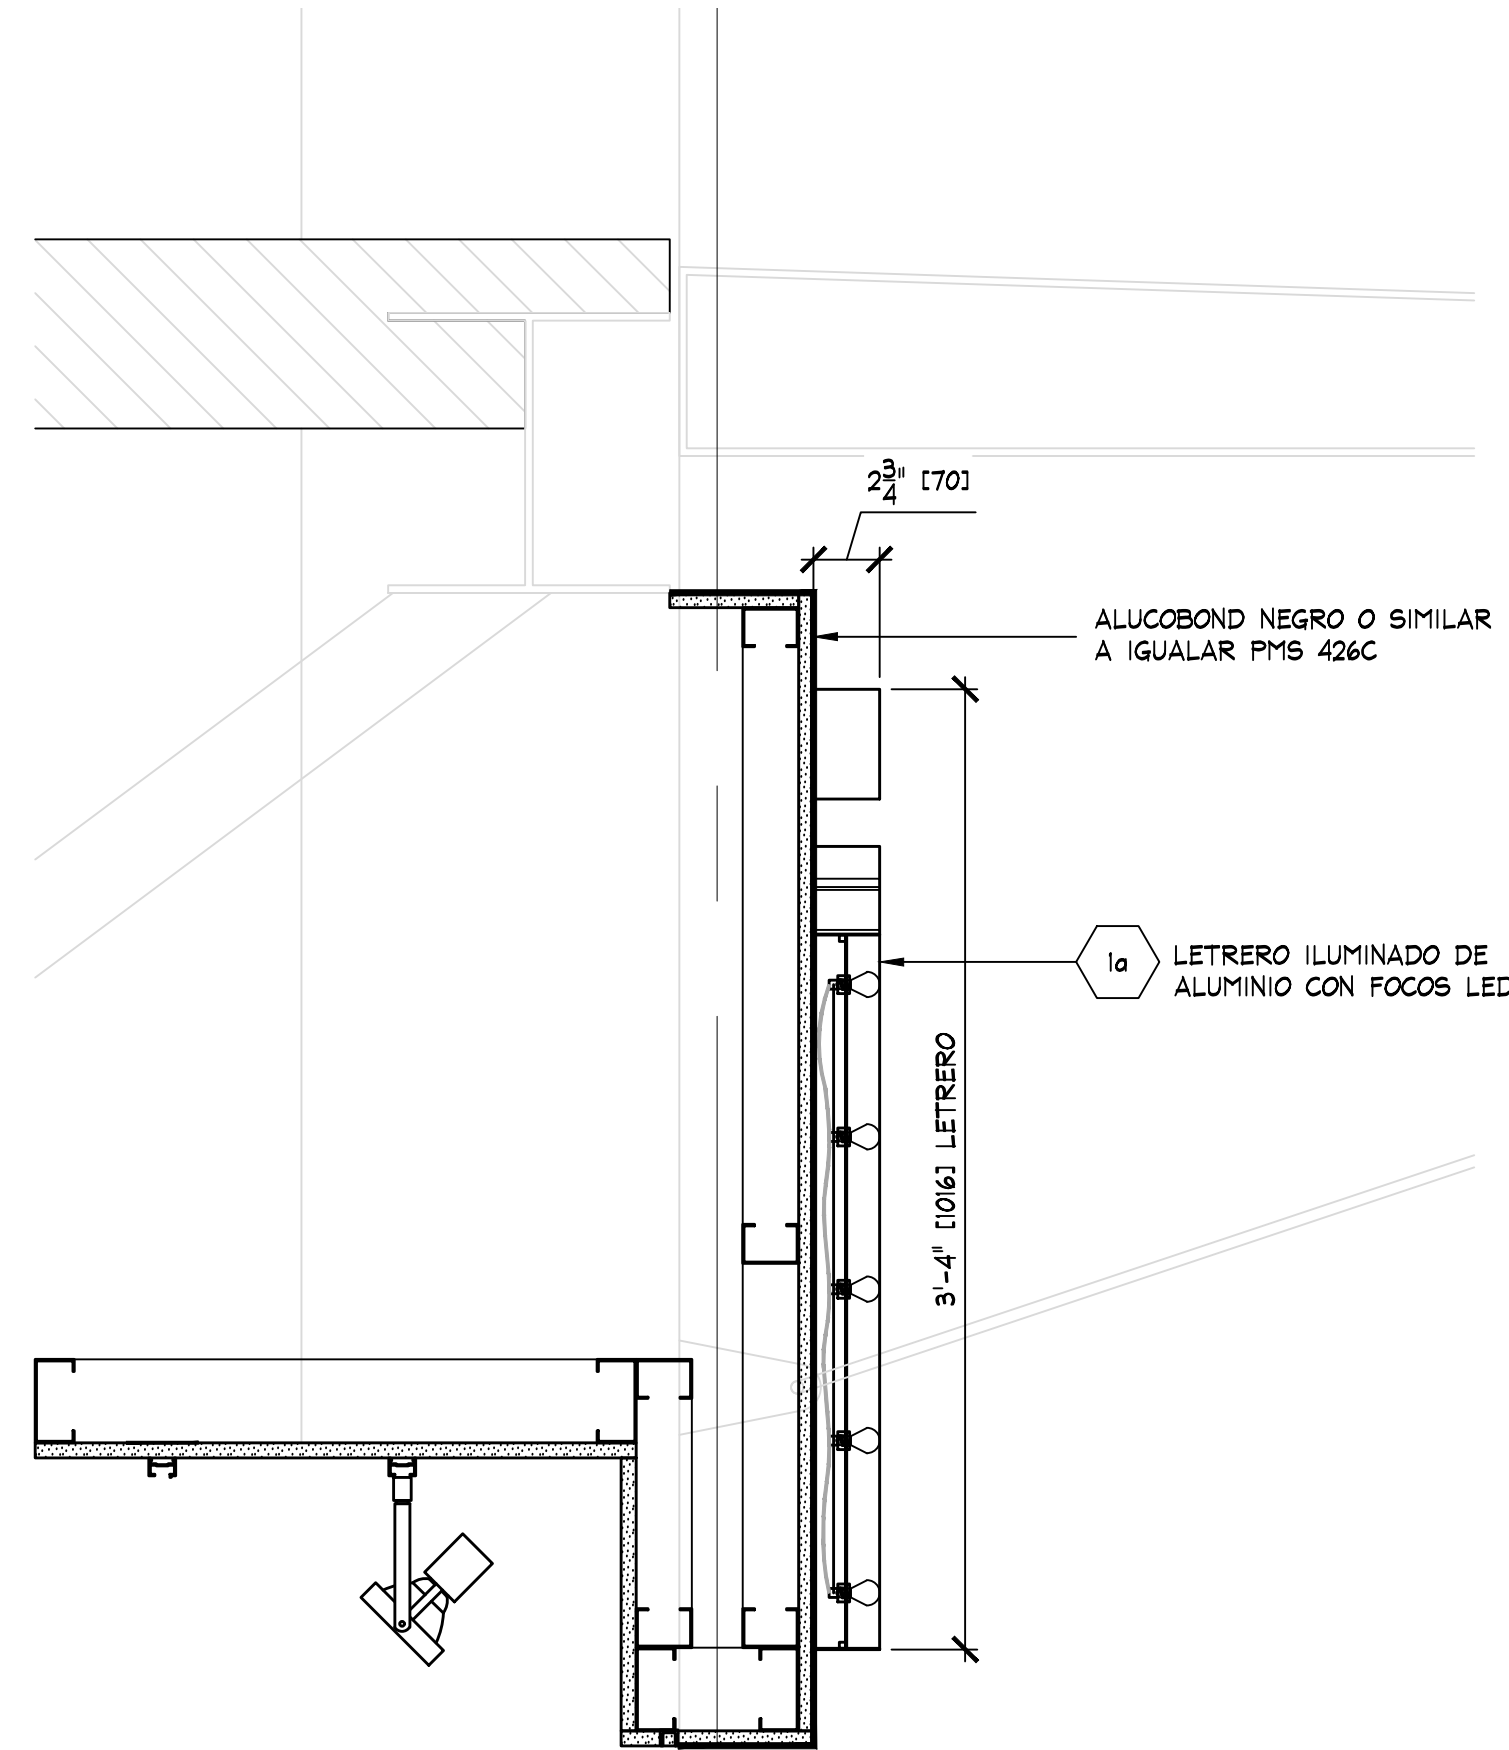


AA SECTION DETAIL @ ENTRY SIGN
A.2.800 SCALE: 1 1/2" = 1'-0" (1:8)

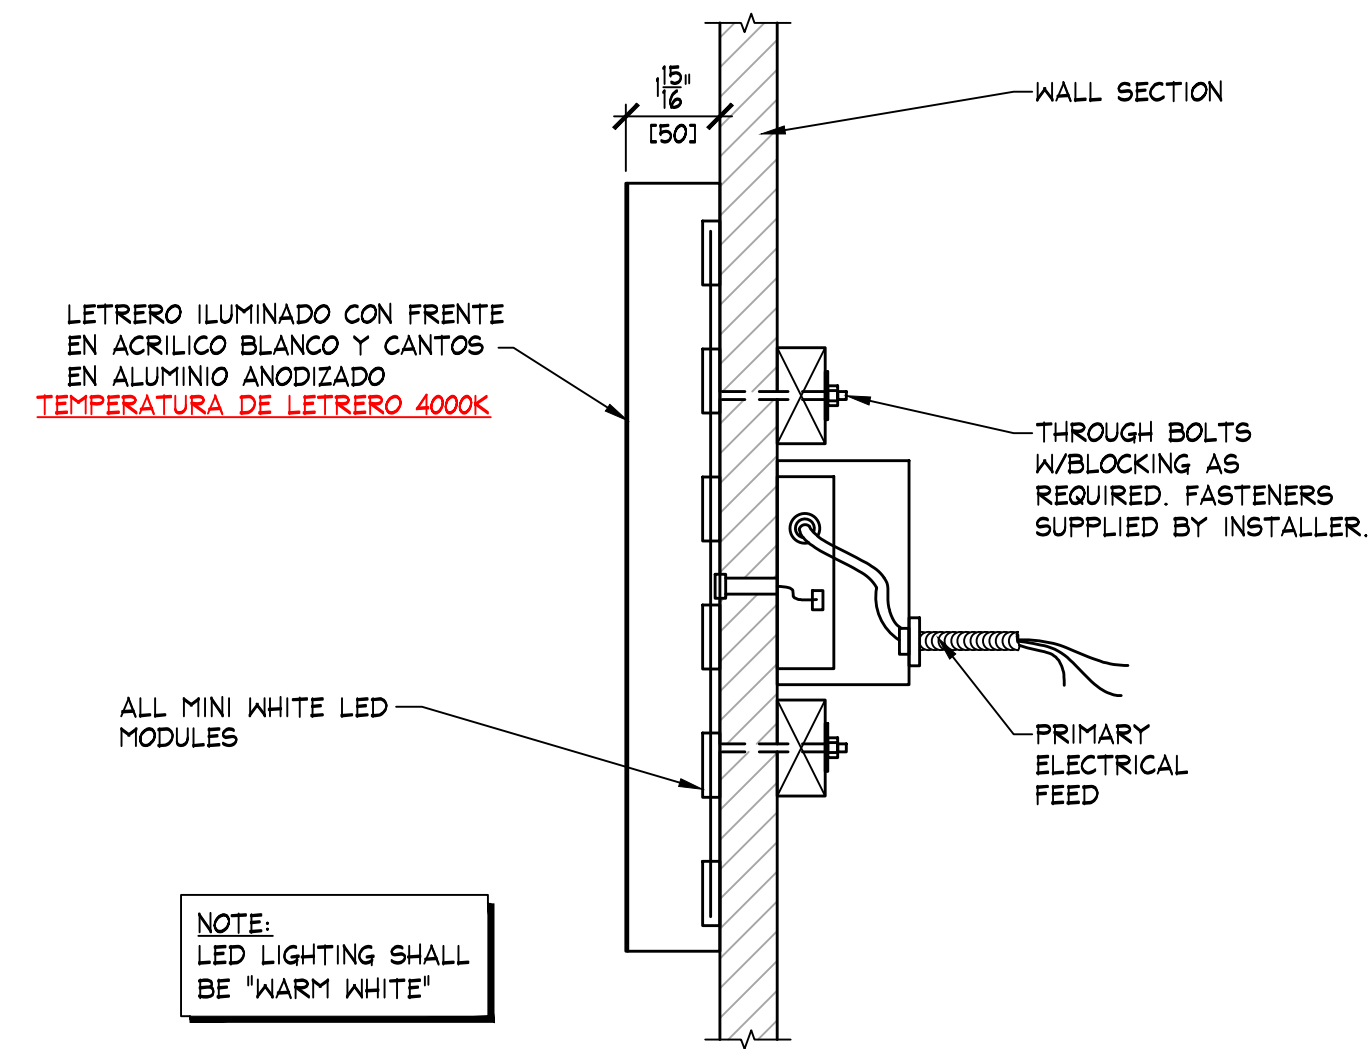

NOTE:
LED LIGHTING SHALL
BE "WARM WHITE"


B SECTION VIEW
A.1.800 SCALE: 3" = 1'-0" (1:4)

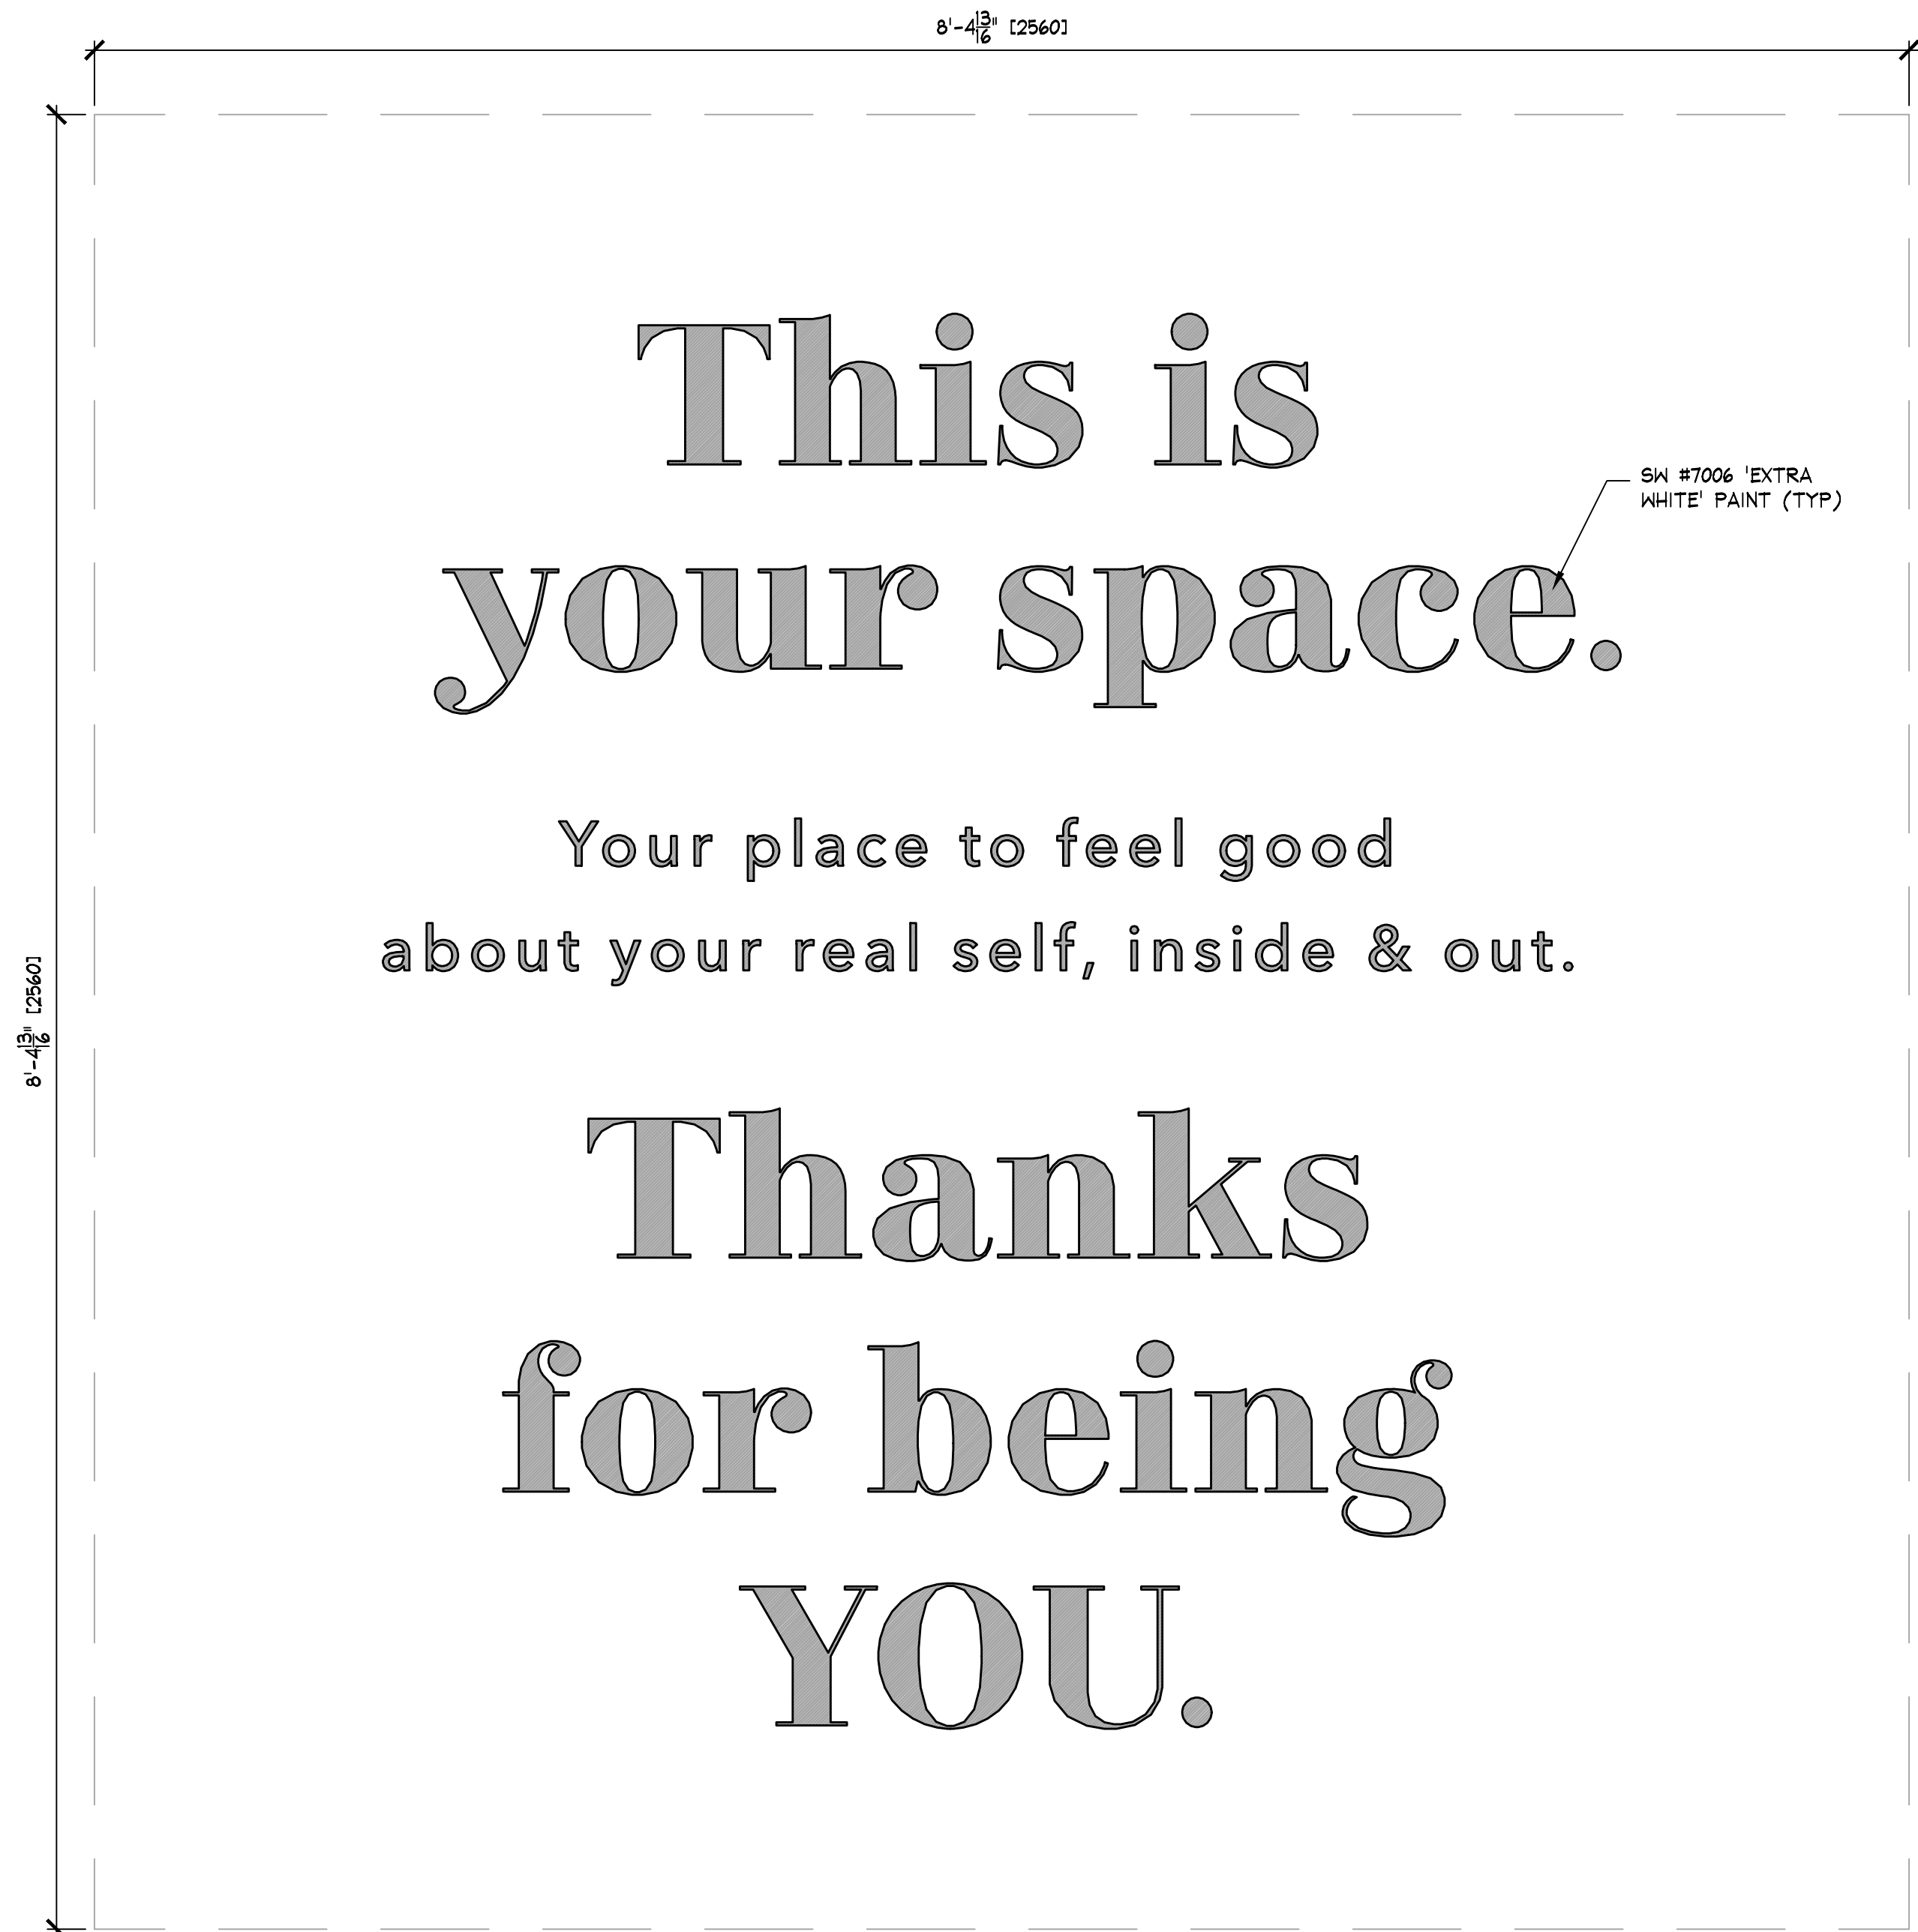


Your place to feel good
about your real self, inside & out.

Thanks
for being
YOU.

R 'BRAND STORY' ARTWORK
A.2.800 SCALE: 1 1/2" = 1'-0" (1:8)

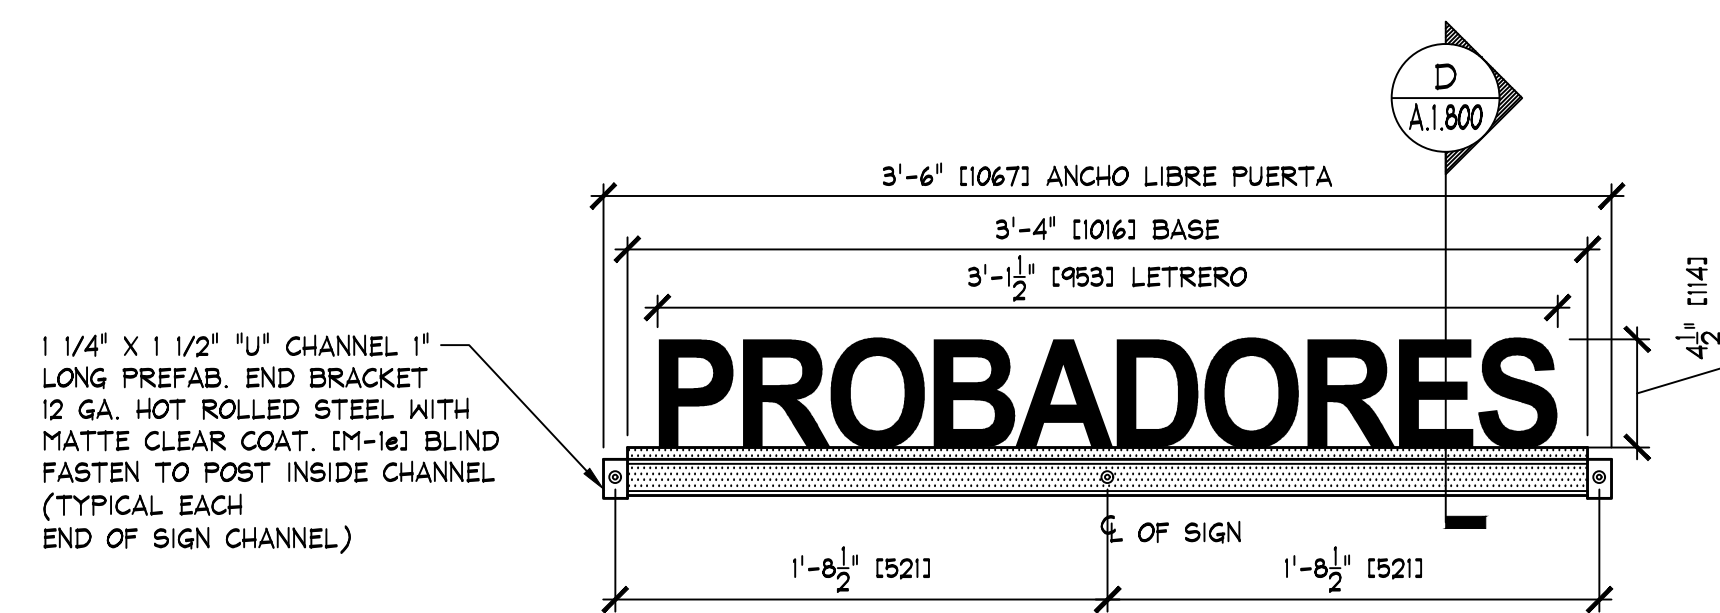

C LETRERO PROBADORES
A.1.800 SCALE: 1 1/2" = 1' - 0"

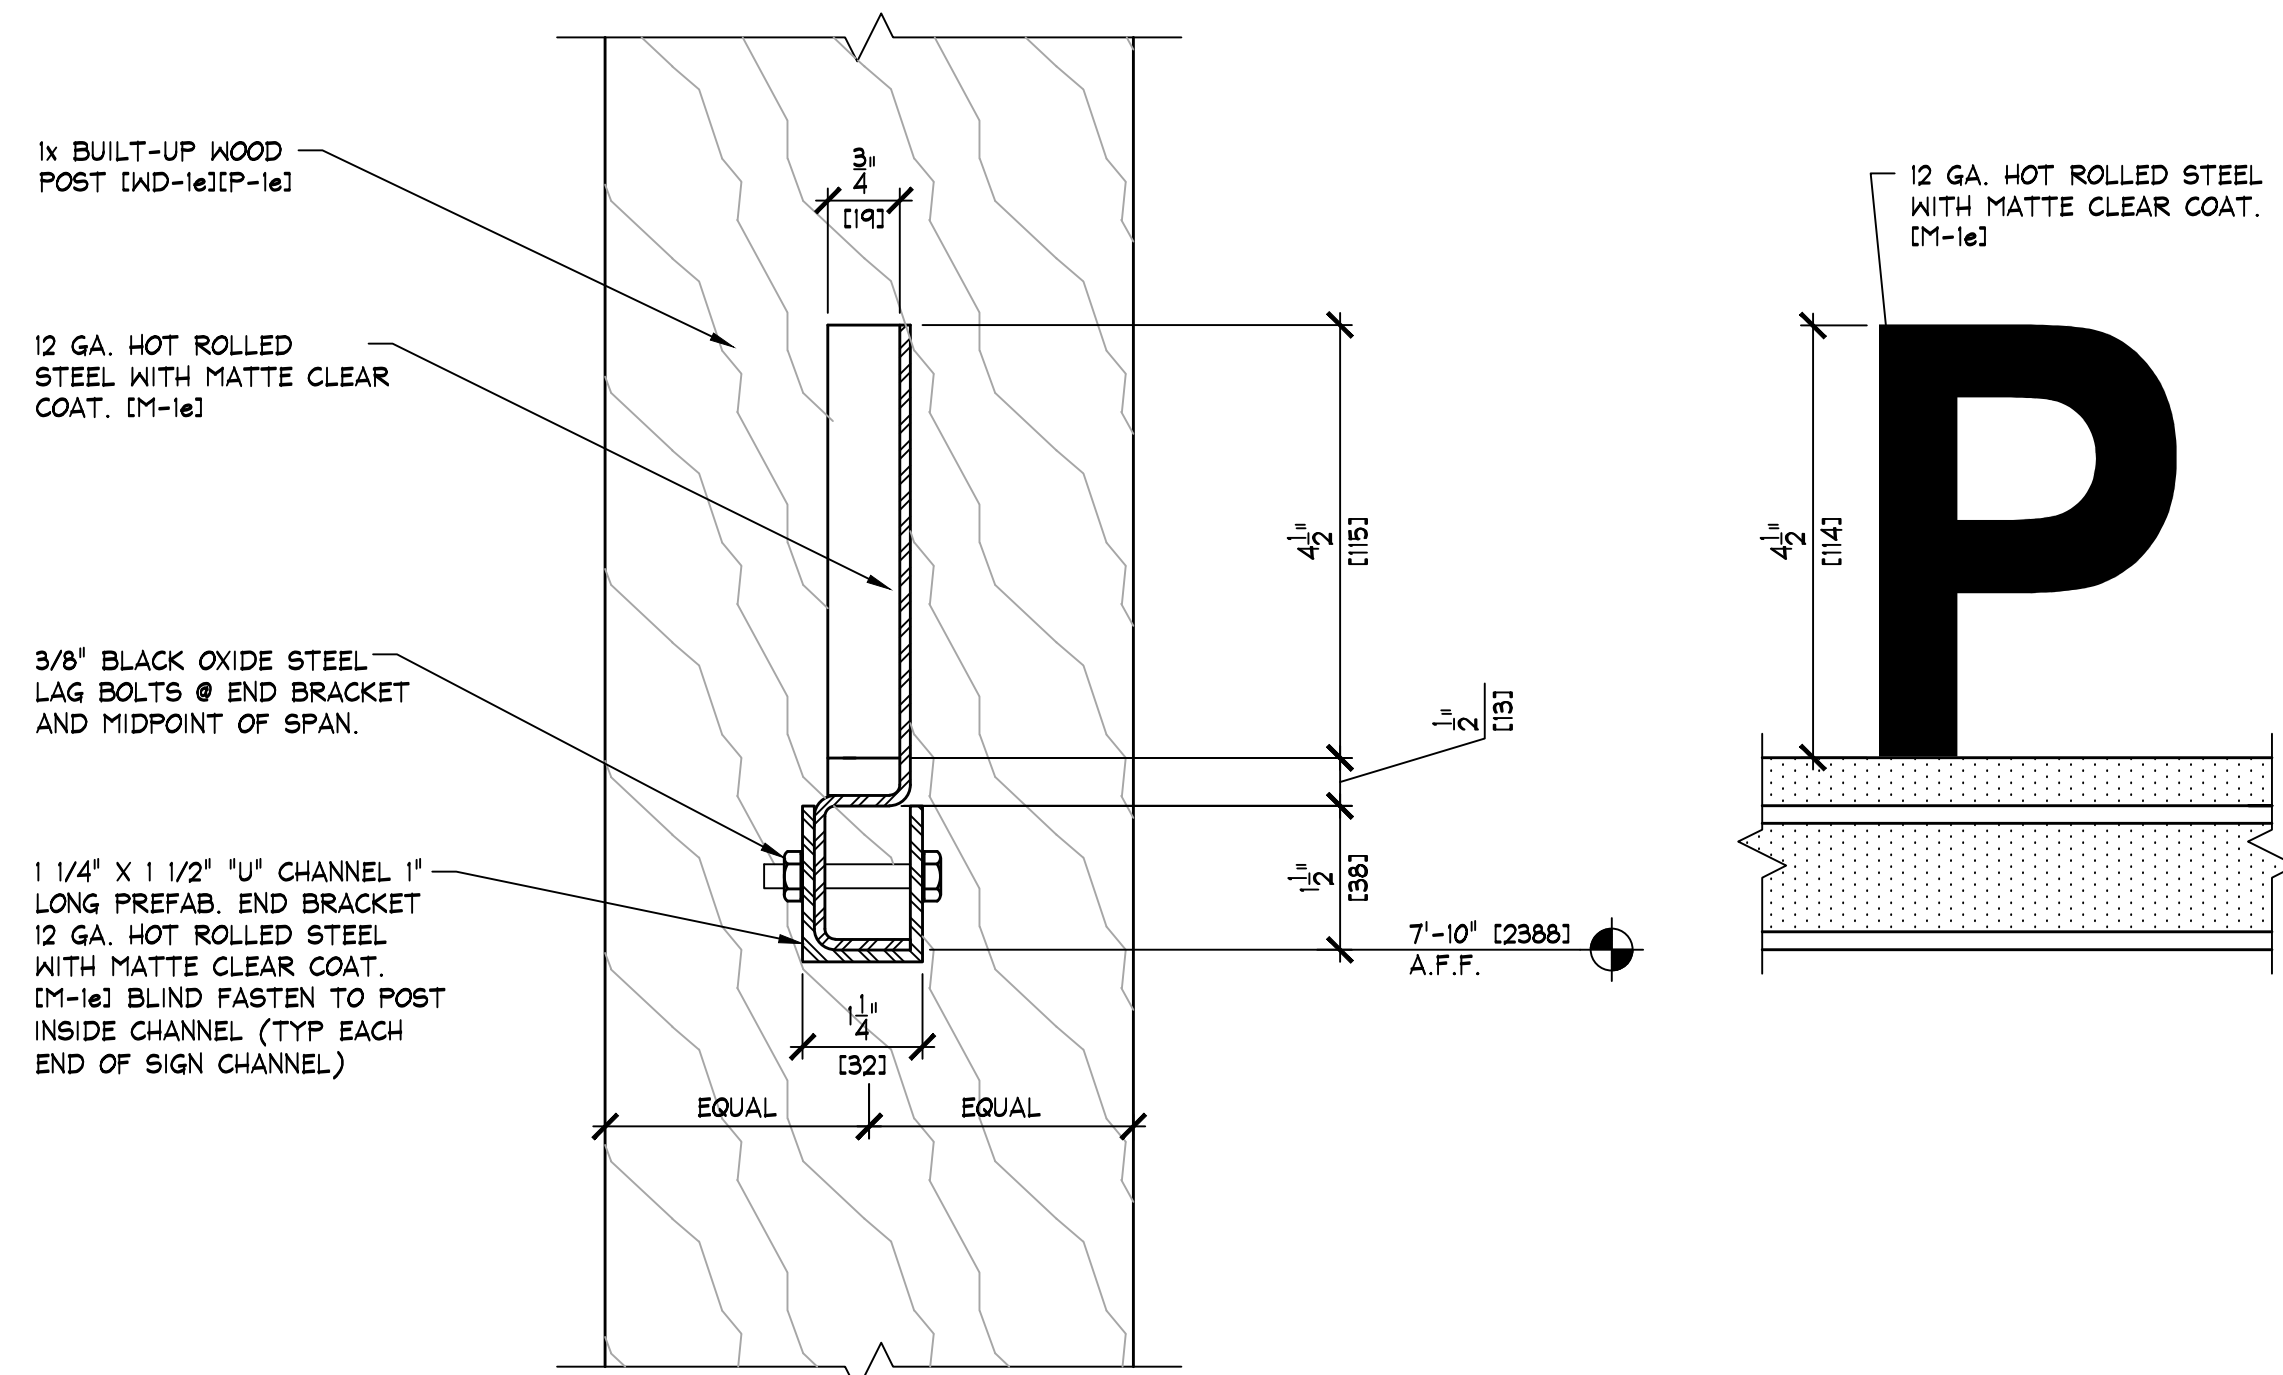

D SECTION THRU FITTING ROOM SIGN
A.1.800 HALF FULL SCALE

AMERICAN EAGLE

THINK ARCHITECTURE S.A. DE C.V.
Descartes 99, 1er. piso Col. Anzures
Miguel Hidalgo C.P. 11550 Mexico
THINK
AMERICAN EAGLE OUTFITTERS, INC.
77 Hot Metal Street
Pittsburgh, PA 15203
(412) 432-3300

SIGN SHOP DETAILS

AMERICAN EAGLE OUTFITTERS
Los Plazos Outlet Cancun
Cancun, Quintana Roo Space #: L221/L24

Store No.

9275

Drawn by:

Drawing No.

A.1.800

